
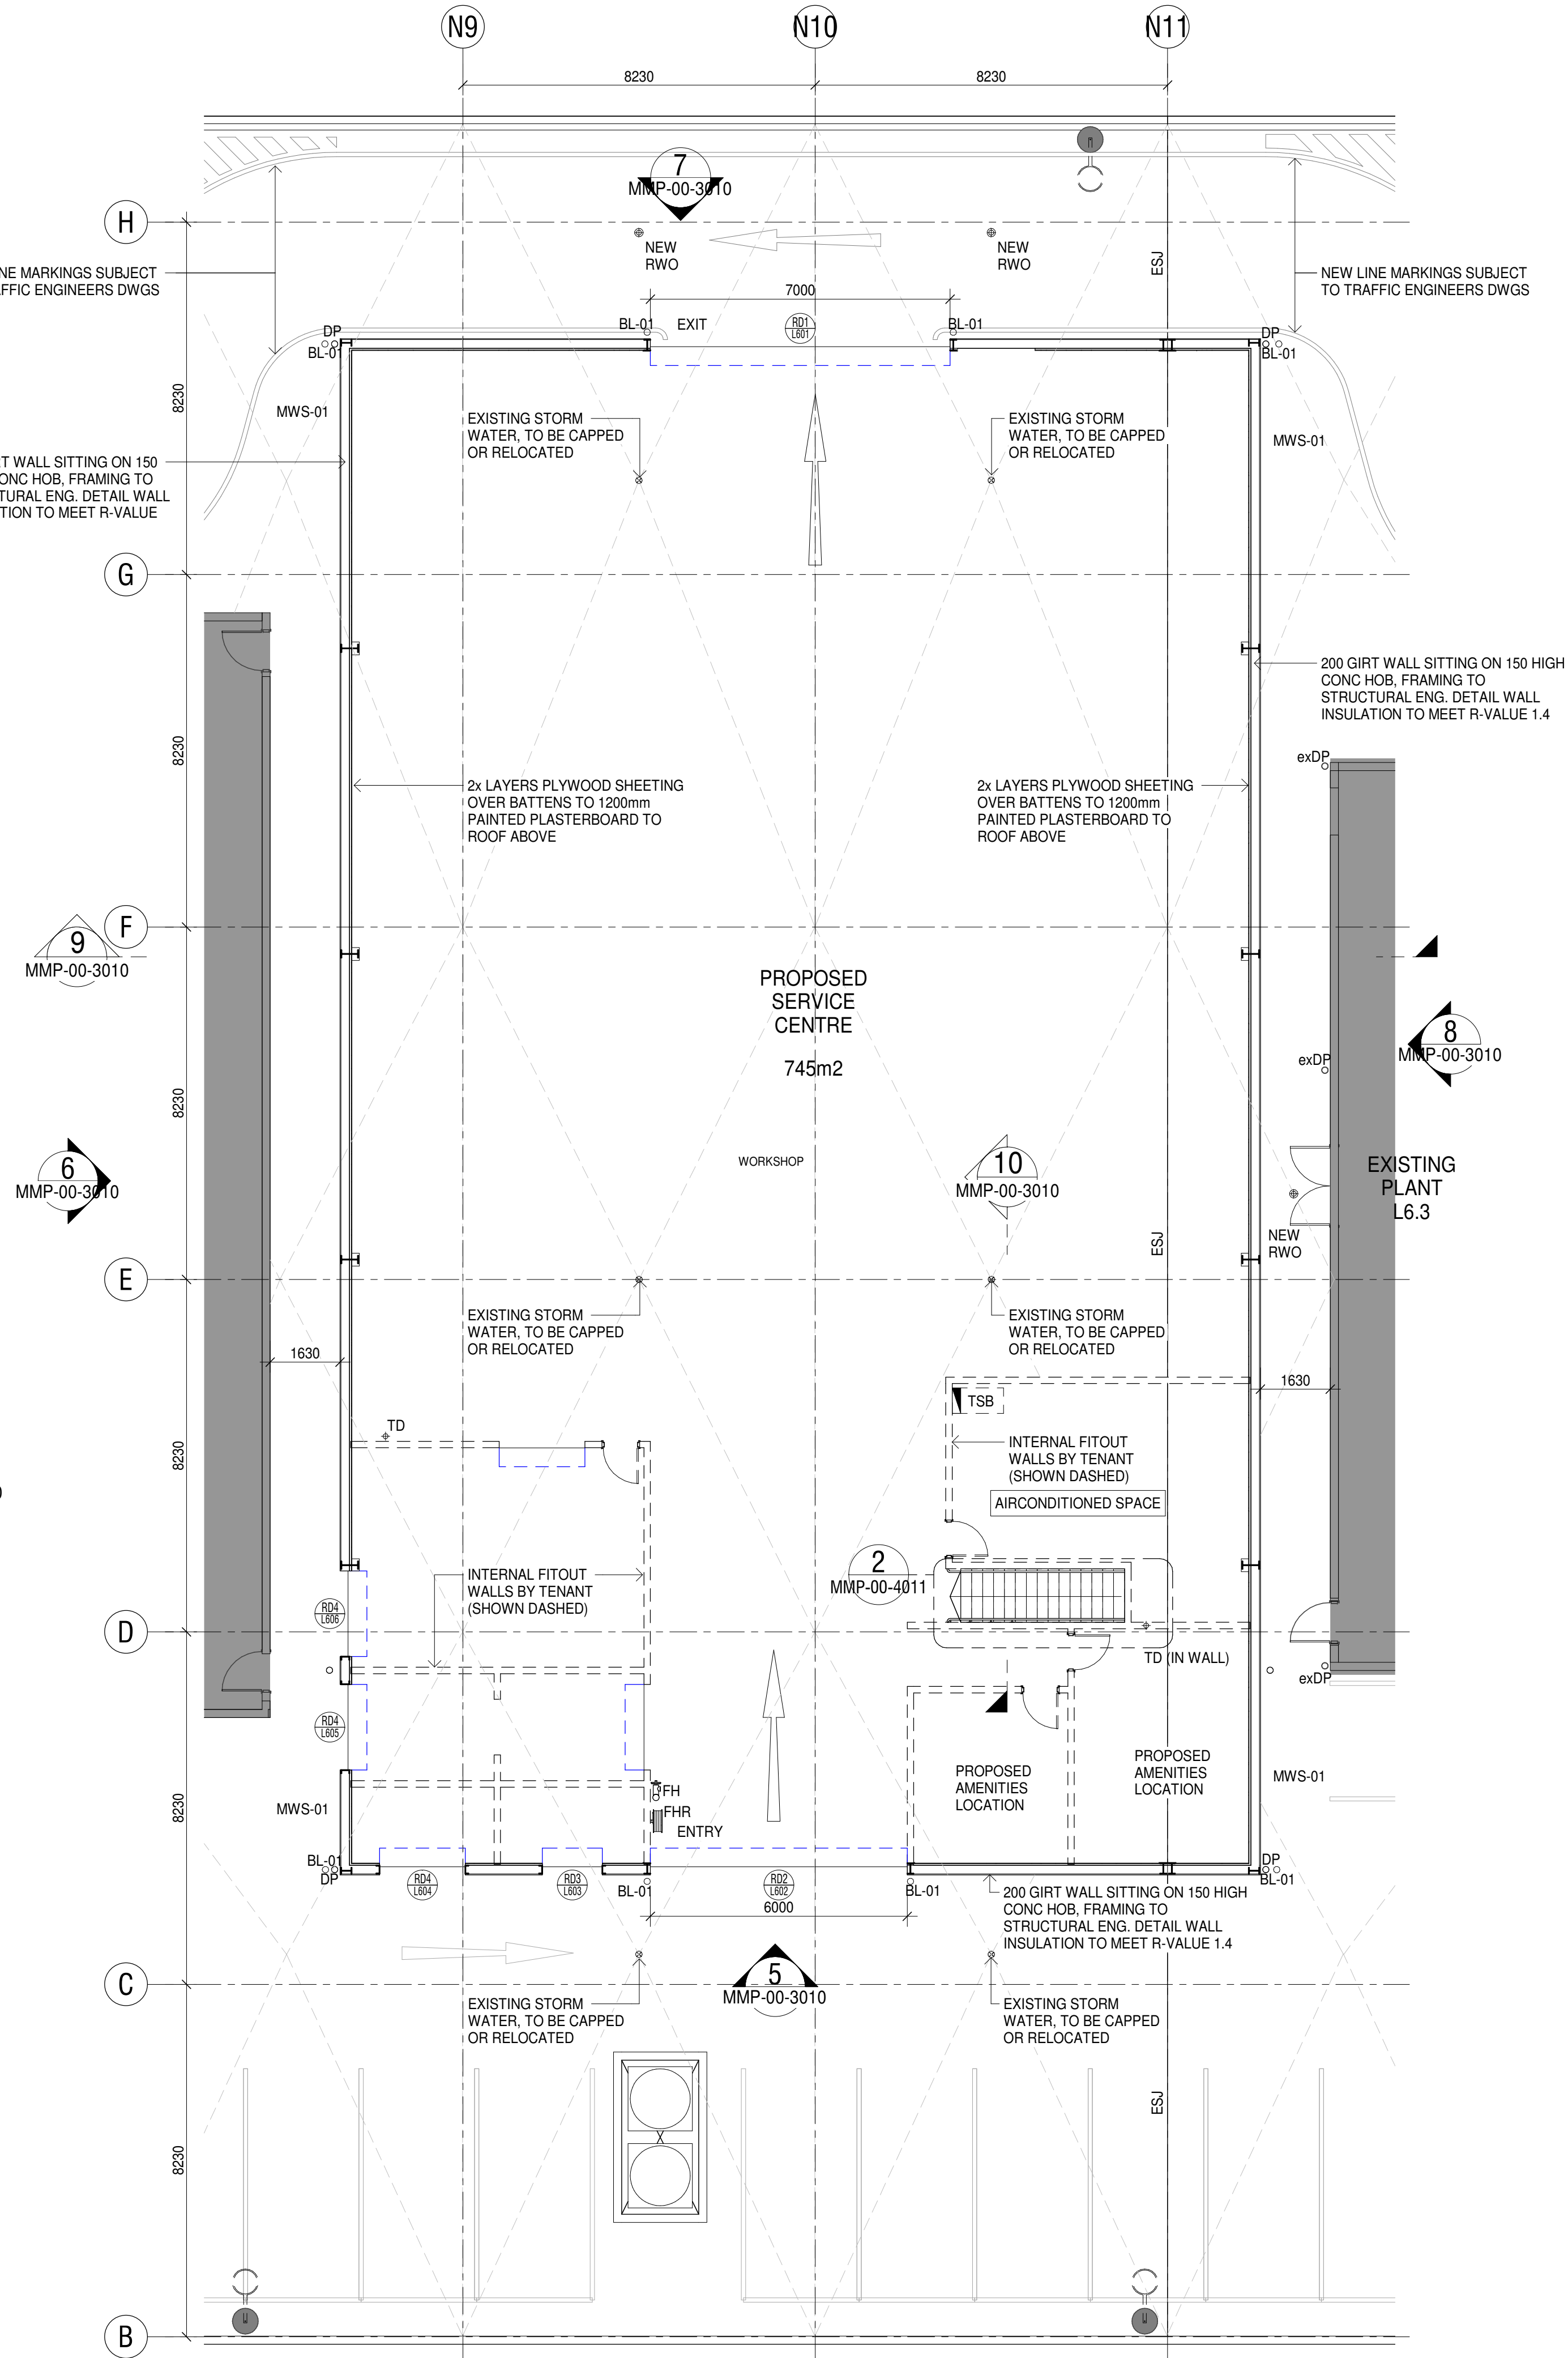


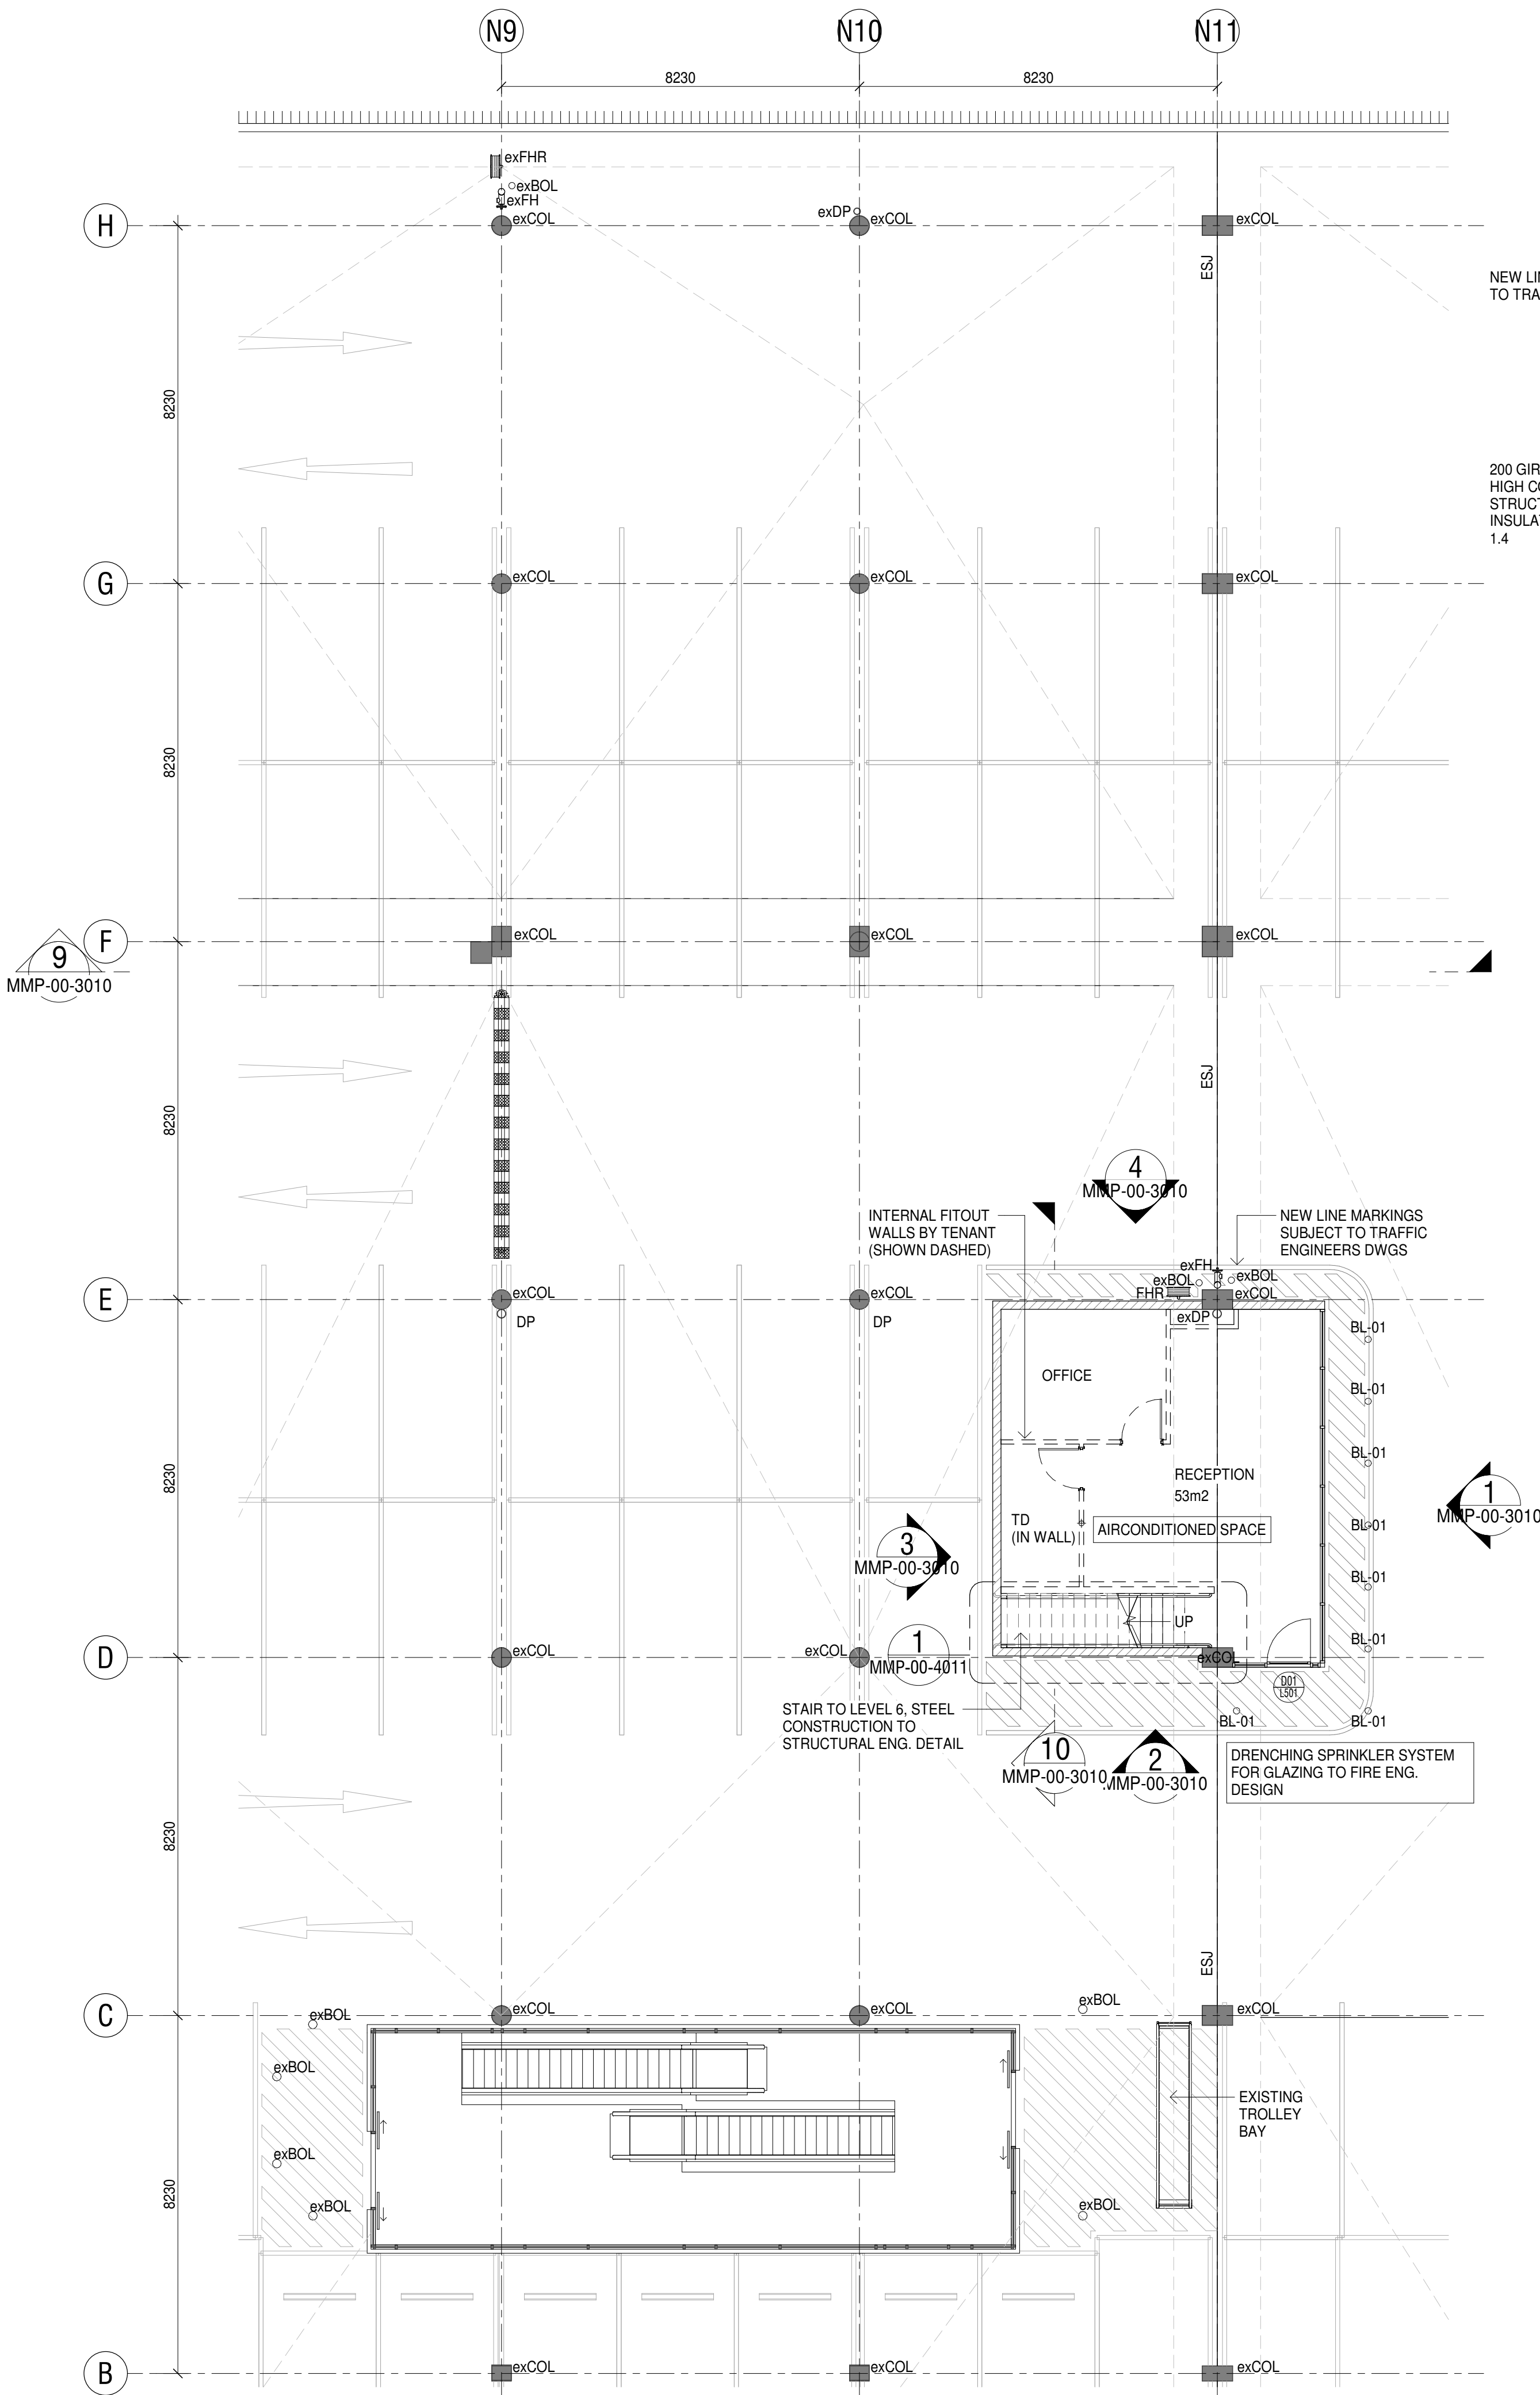

Rev.	Date	Description	Iss.	App.
A	14.02.20	FOR INFORMATION	LC	BN
B	25.02.20	FOR INFORMATION	LC	BN
C	26.02.20	FOR INFORMATION	LC	BN
D	14.03.20	PRELIMINARY	DC	BN
E	20.03.20	FOR TENDER	DC	BN

Do not scale this drawing. Verify all dimensions on site before commencing any work. Copyright © 2020 Buchan. This drawing remains the property of The Buchan Group Australia Pty Ltd. Reproduction in whole or in part without prior consent is forbidden.

File: 717167_INDOOROPILLY_DD_2019

LEGEND - MMP	
BL-01	BOLLARD - TYPE A
DP	DOWNPIPES TO HYDRAULIC ENG. DESIGN
exBOL	EXISTING BOLLARD
exCOL	EXISTING COLUMN - REFER TO STRUCTURAL DRAWINGS
exDP	EXISTING DOWNPIPE
exFH	EXISTING FIRE HYDRANT
exFHR	EXISTING FIRE HOSE REEL
FH	FIRE SERVICES
FHR	NEW FIRE HOSE REEL
MWS-01	PROFILED METAL WALL SHEETING
I.T	INTER-TENANCY
PROPOSED LEASE LINE	
exCOL	EXISTING COLUMN (CONCRETE)
exSC	EXISTING COLUMN (STEEL)
ESJ	EXISTING SLAB JOINT
exSSL	EXISTING STRUCTURAL SLAB LEVEL
SSL	STRUCTURAL SLAB LEVEL
C.O.S	CHECK ON SITE
exDP	EXISTING DOWNPIPE
DP	DOWNPIPE
FHR	FIRE HOSE REEL
TSB	TENANCY SWITCH BOARD REFER ELECTRICAL SERVICES DRAWINGS FOR DETAILS
TD	TUNDISH REFER HYDRAULIC SERVICES DRAWINGS
RWO	RAIN WATER OUTLET REFER HYDRAULIC SERVICES DRAWINGS

Project
INDOOROPILLY
INDOOROPILLY SHOPPING CENTRE

Project Number
717167
Status
FOR TENDER
Date Plotted
25/03/2020 2:36:22 PM
Date Issued
20.03.20
Scale
As indicated @A1
Drawing Title
PROPOSED FLOOR PLAN - LEVEL 5 & 6 SERVICE CENTRE MMP

Drawing Number
A-DD-MMP-L5-1121
Revision
E

BUCHAN
Brisbane Studio
+ 61 7 3859 9222 / buchangroup.com.au

1 PROPOSED FLOOR PLAN - LEVEL 5
CP-XX-2050 1:100

2 PROPOSED FLOOR PLAN - LEVEL 6
CP-XX-2050 1:100

FOR TENDER