

CLIENT :BRENDAN COURT & REBECCA MAJOR

PROJECT :PROPOSED RESIDENCE

ADDRESS :LOT 10 LEIGHTON CRESCENT,
GORDONVALE



SHEET REGISTER	
WD01	SITE PLAN
WD02	FLOOR PLAN
WD03	ELEVATIONS
WD04	ELEVATIONS
WD05	SLAB SET-OUT PLAN
WD06	PLUMBING SET-OUT PLAN
WD07	FOOTING PLAN
WD08	FOOTING DETAILS
WD09	TYPICAL SECTION
WD10	TRUSS TIE-DOWN DETAILS
WD11	ELECTRICAL PLAN
WD12	ROOF BATTEN O/H DETAILS

SUSTAINABLE HOUSING INFORMATION

ALL AIR CONDITIONERS MUST HAVE AN EER OF AT LEAST 2.90.
SHOWER ROSES WILL BE AAA RATED. WATER PRESSURE WILL NOT EXCEED 500Kpa, OR A PRESSURE LIMITING DEVICE WILL BE FITTED.4-STAR WATER EFFICIENCY LABELING AND STANDARDS (WELS) SCHEME RATED TOILETS (PREVIOUSLY 3-STAR WELS RATED).
THE WATER EFFICIENCY REQUIREMENTS ALSO APPLY FOR RETROFITTING OF EXISTING FEATURES IN HOMES WHERE THE HOUSEHOLD RENOVATIONS INVOLVE BOTH A BUILDING AND PLUMBING APPROVAL. MINIMUM 3-STAR WELS RATED TAPWARE FOR KITCHEN SINKS, BATHROOM BASINS AND LAUNDRY TROUGHS (NEW). WATER EFFICIENT IRRIGATION SYSTEM (IF AN OUTDOOR IRRIGATION SYSTEM IS INSTALLED) WITH A MAXIMUM FLOW RATE OF NINE LITRES PER MINUTE.5 STAR RATED HOT WATER SYSTEM WILL BE INSTALLED. 80% OF THE NUMBER OF LIGHT FITTINGS TO BE FITTED EXCLUSIVELY WITH ENERGY EFFICIENT GLOBES. A CERTIFICATE WILL BE PROVIDED BY THE PLUMBER TO CERTIFY THAT THE ABOVE ITEMS HAVE BEEN COMPLIED WITH MINIMUM 4-STAR MINIMUM ENERGY PERFORMANCE STANDARD (MEPS) RATED AIR CONDITIONERS (WHERE NEW AND REPLACEMENT SYSTEMS ARE INSTALLED). A CERTIFICATE FROM THE BUILDER CONFIRMING THAT THE ABOVE ITEM HAS BEEN COMPLIED WITH. A CERTIFICATE WILL BE PROVIDED BY THE ELECTRICIAN TO CERTIFY THAT 80% OF THE TOTAL ENCLOSED FLOOR AREA IS FITTED WITH FLUORESCENT LIGHTING.



PH:- (07) 4033 7426

QBCC:- 70164

ABN:- 74 056 137 574

200 C.M. BLOCKWORK REINFORCING :-

DOTS IN 200 C.M. WALLS INDICATE N12 VERTICAL. REINF. BARS AT 1200 MAX. CRS. AS NOTED ON FLOOR PLAN, AT ALL CORNERS ADJACENT TO ALL OPENINGS & UNDER ALL GIRDER TRUSSES (WHERE APPLICABLE) 2-N12 BARS BESIDE ALL OPENINGS GREATER THAN 1800.

DOOR TO WC TO BE MOUNTED ON REMOVABLE HINGES.

INTERNAL TIMBER WALLS (N.L.B.)

70/90x35 MGP10 STUDS AT 450 MAX. CRS. U.N.O.
70/90x35 MGP10 TOP & BOTTOM PLATES U.N.O.
70/90x35 MGP10 NOGGING AT 1350 MAX. CRS.

RB1 - 125x75x4.0 RHS ROOF BEAM

RB2 - 125x75x5.0 RHS ROOF BEAM

L1

400x200 C.M. LINTEL
2-N16 BARS TOP
2-N16 BARS BOTTOM
W8 LIGS AT 200 CRS.

L2


400x200 C.M. LINTEL
1-N16 BAR TOP
1-N16 BAR BOTTOM
W8 LIGS AT 200 CRS.

NOTE:-

GARAGE PANEL LIFT DOOR & FIXINGS ARE TO BE C1 CYCLONE WIND RATED TO AS 4505

⊕ S.A. (SMOKE ALARM)

- i) BE PHOTOELECTRIC (AS 3786-2014); AND
ii) NOT ALSO CONTAIN AN IONISATION SENSOR; AND
iii) BE HARDWIRED TO THE MAINS POWER SUPPLY WITH A SECONDARY POWER SOURCE (i.e. BATTERY); AND
iv) BE INTERCONNECTED WITH EVERY OTHER SMOKE ALARM IN THE DWELLING SO ALL ACTIVE TOGETHER
LOCATION OF ALARMS IS INDICATIVE ONLY & ARE TO COMPLY WITH RELEVANT PARTS OF THE BCA

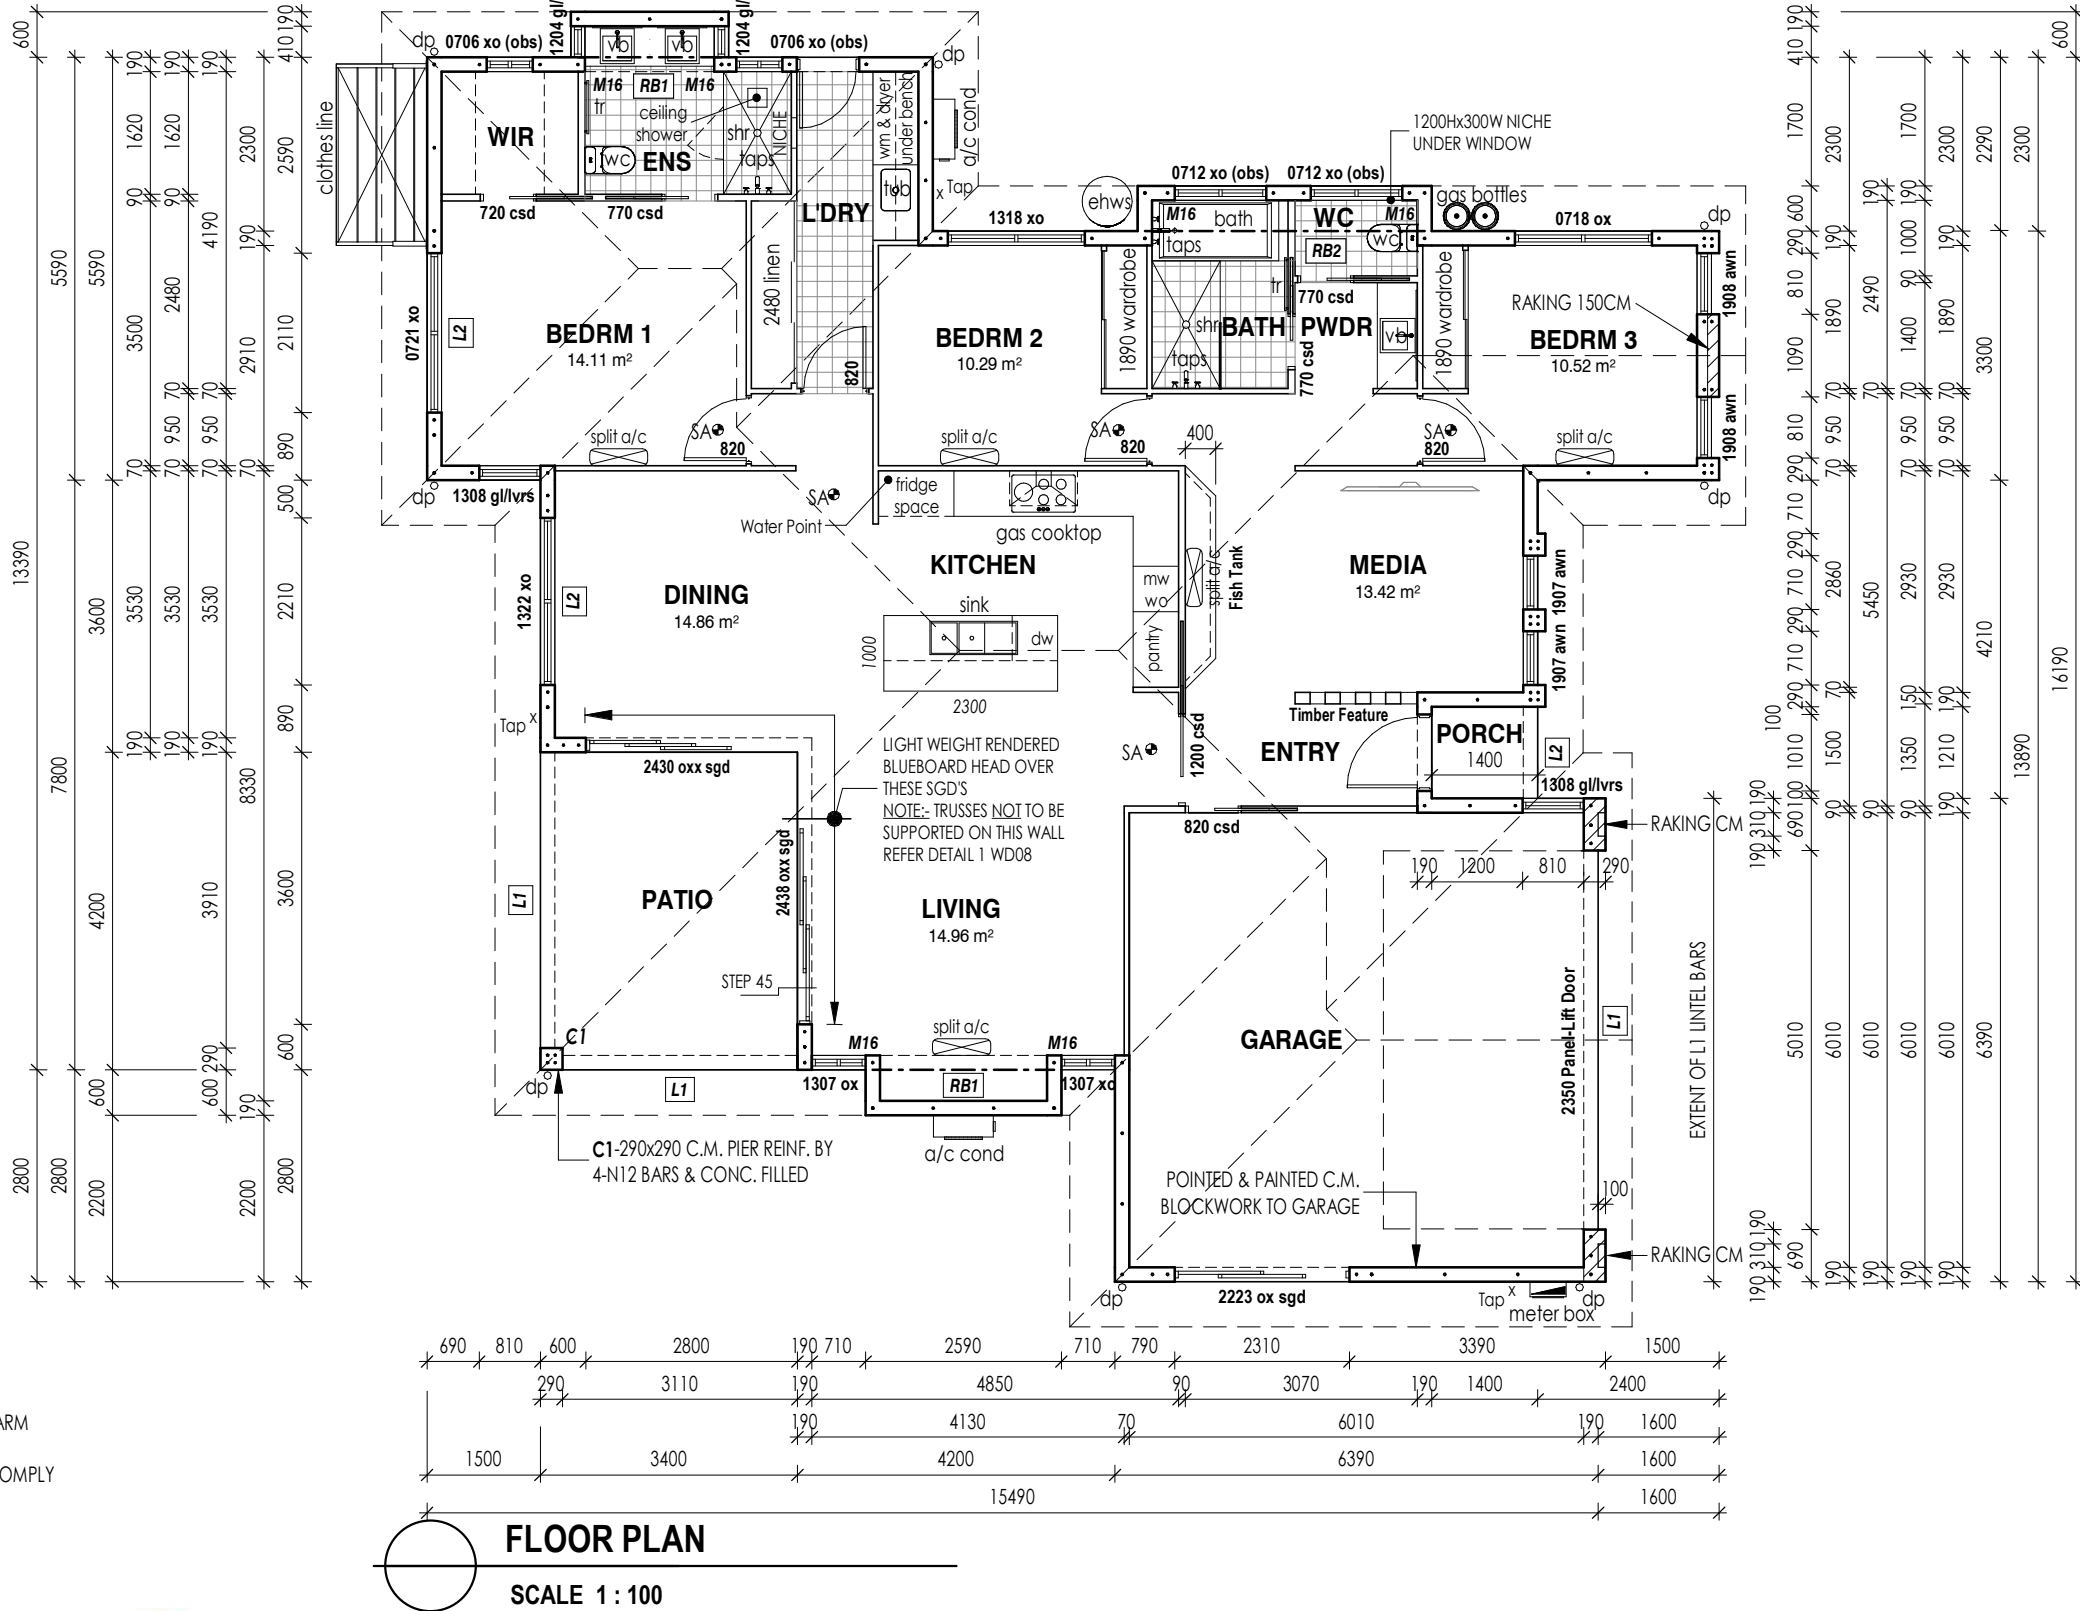

FLOOR PLAN

SCALE 1 : 100

AREAS:	(APPROX)
LIVING	144.71 m²
GARAGE	39.39 m²
PATIO	14.28 m²
PORCH	1.69 m²
GRAND TOTAL	200.07 m²

WE HEREBY CERTIFY THE STRUCTURAL DETAILS AS SHOWN IN THESE DRAWINGS FOR CONSTRUCTION IN TERRAIN CATEGORY **C1**

C.M.G. CONSULTING ENGINEERS PTY. LTD.
A.C.N. 011 049 375
208 BUCHAN ST.
CAIRNS QLD. 4870
PH 07 4031 2775
FAX 07 4051 9013

© COPYRIGHT 2020 TO RICHARDSONS BUILDING SERVICE
THIS DESIGN REMAINS THE PROPERTY OF RICHARDSONS BUILDING SERVICE & CANNOT BE COPIED OR REPRODUCED IN WHOLLY OR IN PART WITHOUT THE WRITTEN PERMISSION OR CONSENT FROM RICHARDSONS BUILDING SERVICE



RICHARDSONS BUILDING SERVICE

PH:- (07) 4033 7426

QBCC:- 70164

ABN:- 74 056 137 574

PROJECT :-
PROPOSED RESIDENCE

CLIENT :-
**BRENDAN COURT &
REBECCA MAJOR**

PROJECT ADDRESS :-
**LOT 10 LEIGHTON CRESCENT,
GORDONVALE**

DRAWN :-
L. OZOLINS

ENGINEER :-
CMG CONSULTING
ENGINEERS

BUILDER :-
RICHARDSONS
BUILDING SERVICE


SCALE @ A3:
1 : 100

DESIGN WIND VELOCITY :-


C1

CLASSIFICATION

REVISION	DATE	ISSUE	DATE :- 30/07/2020
DRAFTING ISSUE	07/08/2020	A	DRAWING No :- L010LEI
ENGINEERING ISSUE	02/10/2020	B	
CONSTRUCTION ISSUE	06/10/2020	C	
			SHEET No :- WD02

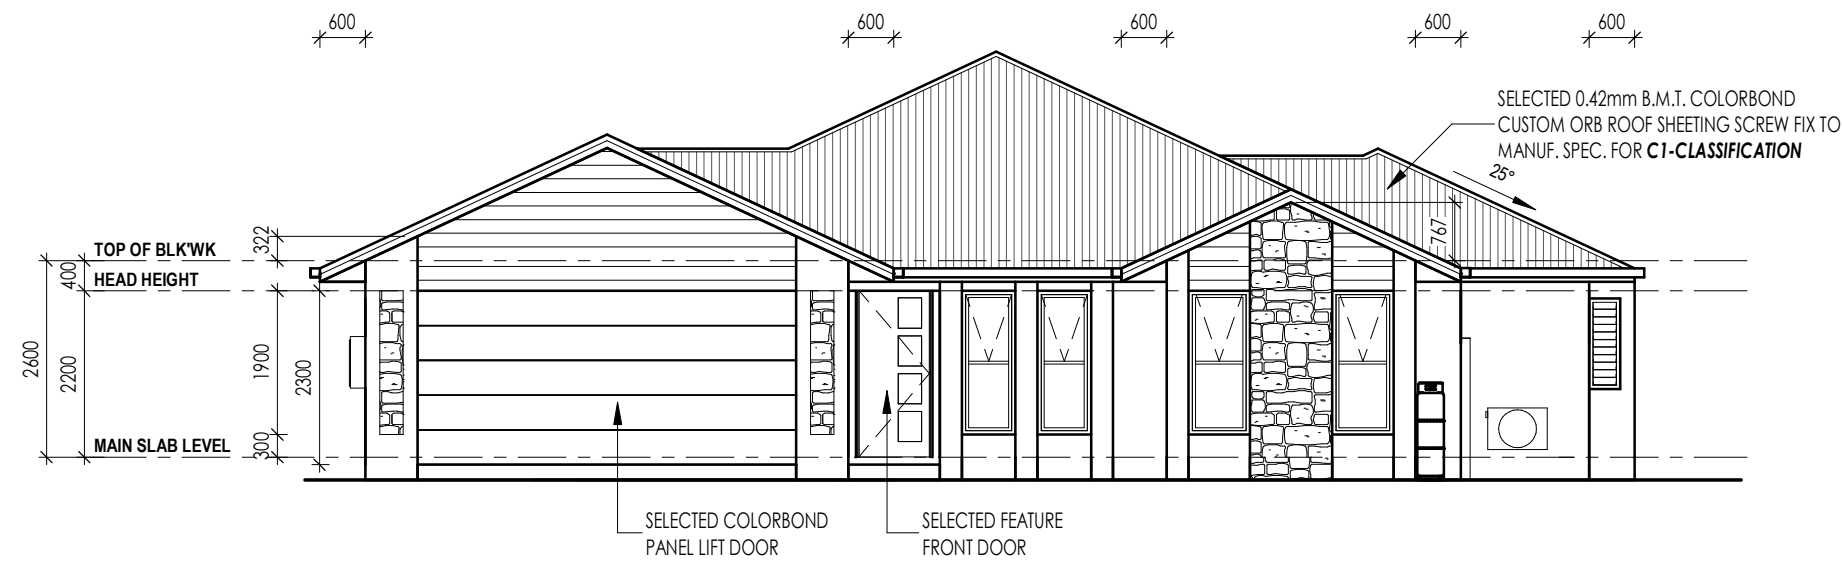

FRONT ELEVATION
SCALE 1 : 100

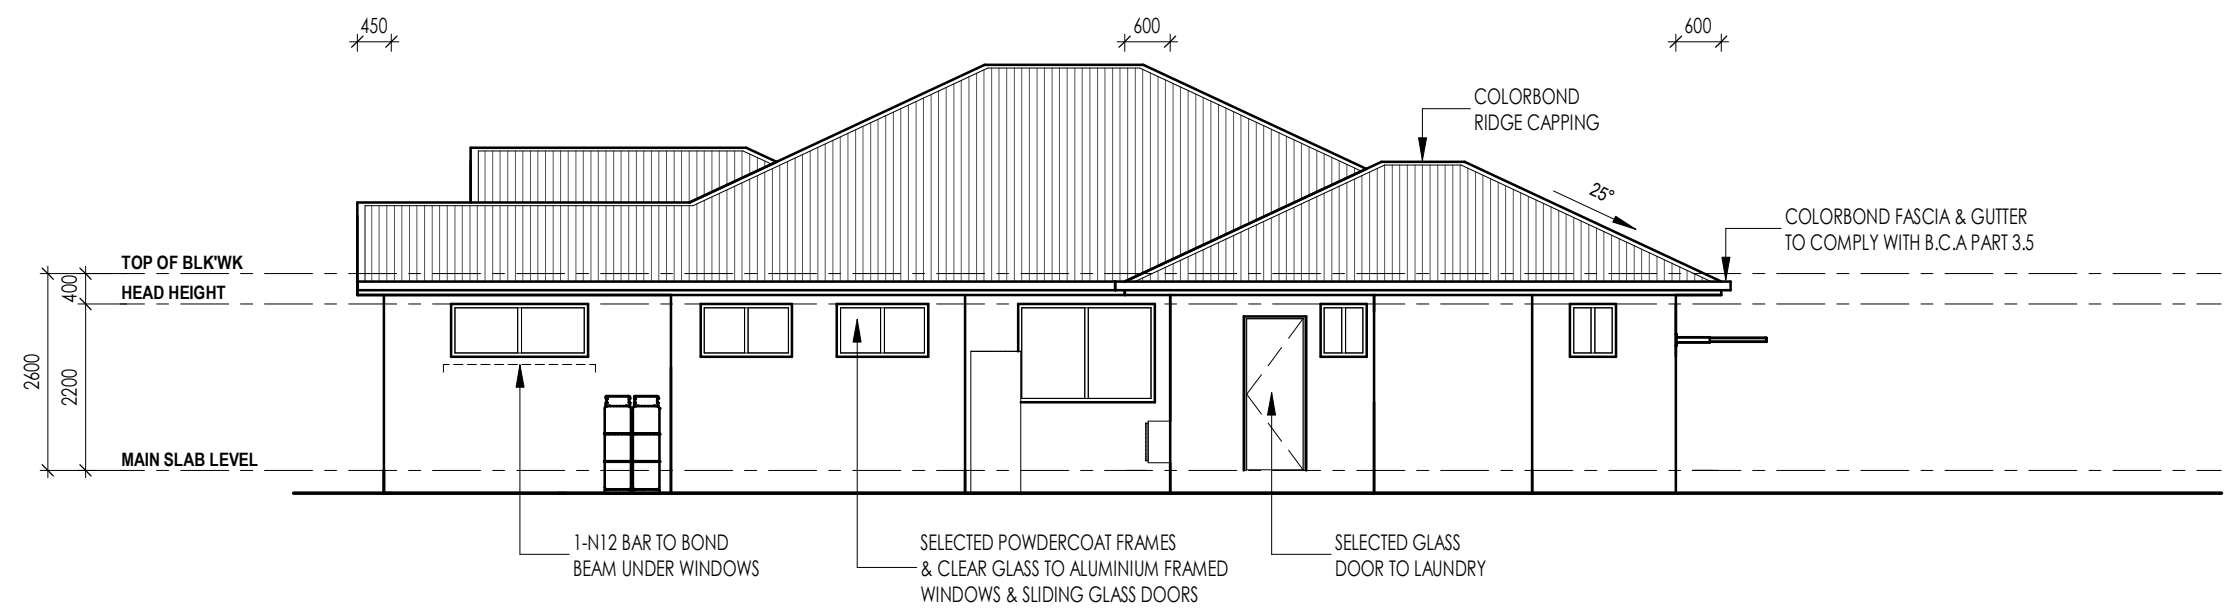


RIGHT SIDE ELEVATION
SCALE 1 : 100

WE HEREBY CERTIFY THE STRUCTURAL DETAILS AS SHOWN IN THESE DRAWINGS FOR CONSTRUCTION IN TERRAIN CATEGORY **C1**


C.M.G. CONSULTING ENGINEERS PTY. LTD.
A.C.N. 011 049 375

208 BUCHAN ST.
CAIRNS QLD. 4870
PH 07 4031 2775
FAX 07 4051 9013

© COPYRIGHT 2020 TO RICHARDSONS BUILDING SERVICE THIS DESIGN REMAINS THE PROPERTY OF RICHARDSONS BUILDING SERVICE & CANNOT BE COPIED OR REPRODUCED IN WHOLLY OR IN PART WITHOUT THE WRITTEN PERMISSION OR CONSENT FROM RICHARDSONS BUILDING SERVICE	rbs DESIGN & CONSTRUCTION RICHARDSONS BUILDING SERVICE	PH:- (07) 4033 7426	PROJECT :-	PROJECT ADDRESS :- LOT 10 LEIGHTON CRESCENT, GORDONVALE	DRAWN :- L. OZOLINS	SCALE @ A3: 1 : 100	REVISION	DATE	ISSUE	DATE :- 30/07/2020
		QBCC:- 70164	PROPOSED RESIDENCE		ENGINEER :- CMG CONSULTING ENGINEERS	DESIGN WIND VELOCITY :- C1 CLASSIFICATION	DRAFTING ISSUE	07/08/2020	A	DRAWING No :- L010LEI
							ENGINEERING ISSUE	02/10/2020	B	
							CONSTRUCTION ISSUE	06/10/2020	C	
ABN:- 74 056 137 574	CLIENT :- BRENDAN COURT & REBECCA MAJOR	BUILDER :- RICHARDSONS BUILDING SERVICE					SHEET No :- WD03			

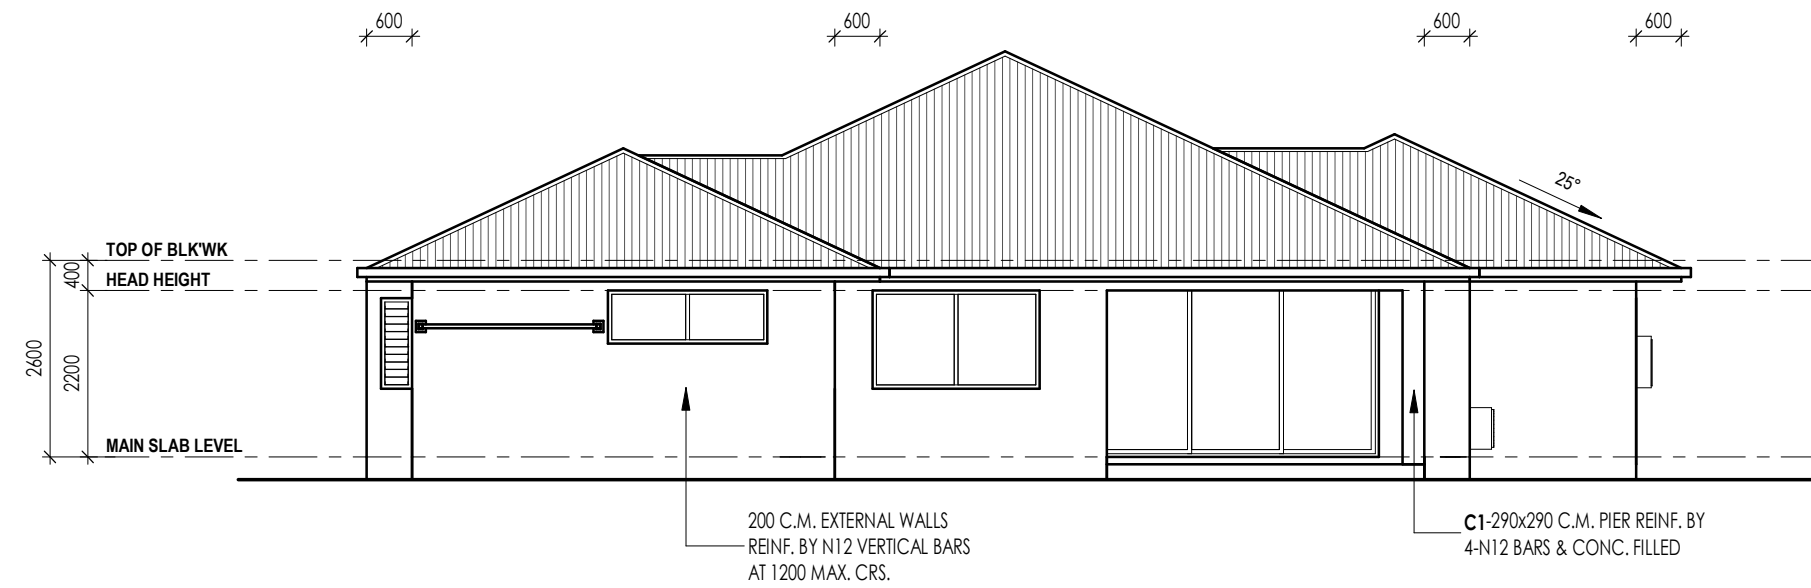

REAR ELEVATION
SCALE 1 : 100

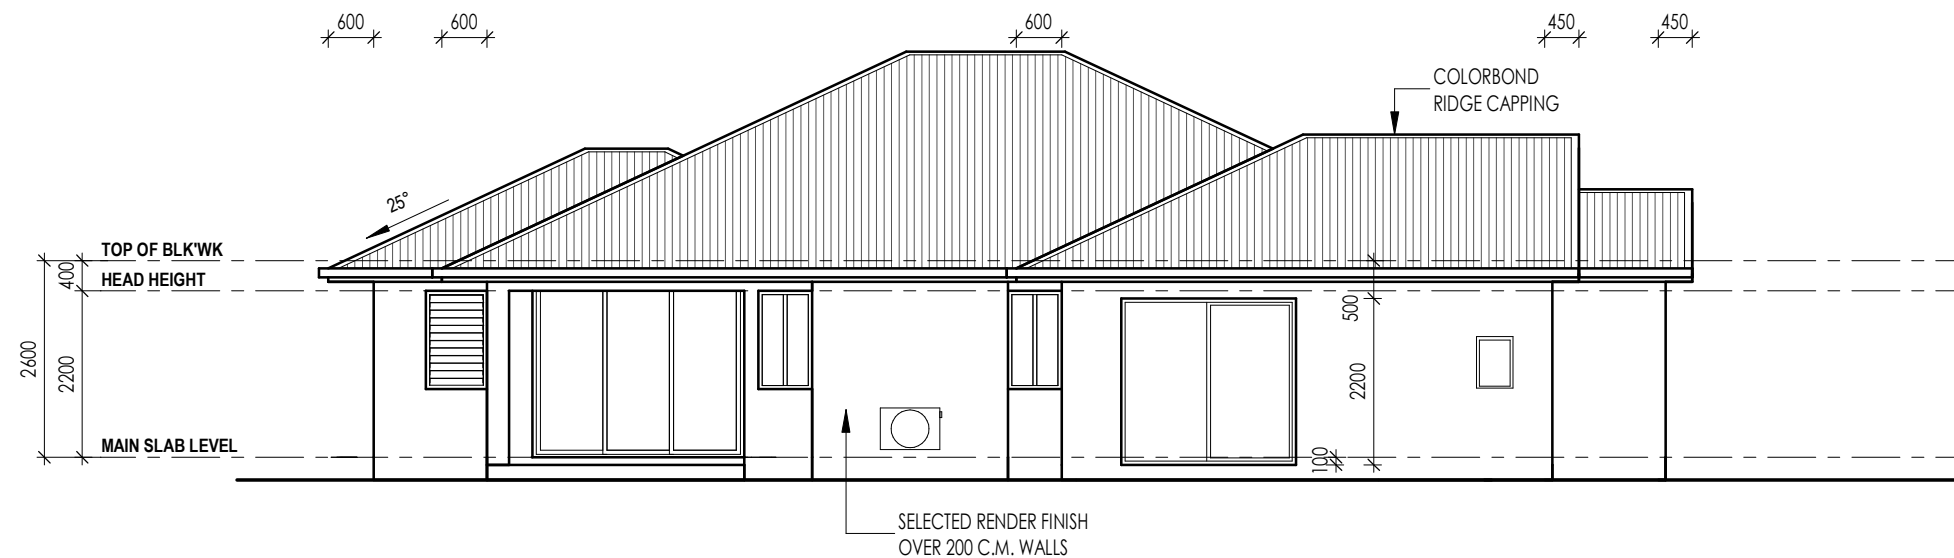


LEFT SIDE ELEVATION
SCALE 1 : 100


WE HEREBY CERTIFY THE STRUCTURAL DETAILS AS SHOWN IN THESE DRAWINGS FOR CONSTRUCTION IN TERRAIN CATEGORY **C1**


C.M.G. CONSULTING ENGINEERS PTY. LTD.
A.C.N. 011 049 375

208 BUCHAN ST.
CAIRNS QLD. 4870
PH 07 4031 2775
FAX 07 4051 9013


© COPYRIGHT 2020 TO RICHARDSONS BUILDING SERVICE THIS DESIGN REMAINS THE PROPERTY OF RICHARDSONS BUILDING SERVICE & CANNOT BE COPIED OR REPRODUCED IN WHOLLY OR IN PART WITHOUT THE WRITTEN PERMISSION OR CONSENT FROM RICHARDSONS BUILDING SERVICE	 RICHARDSONS BUILDING SERVICE	PH:- (07) 4033 7426	PROJECT :- PROPOSED RESIDENCE	PROJECT ADDRESS :- LOT 10 LEIGHTON CRESCENT, GORDONVALE	DRAWN :- L. OZOLINS	SCALE @ A3: 1 : 100	REVISION	DATE	ISSUE	DATE :- 30/07/2020
		QBCC:- 70164	CLIENT :- BRENDAN COURT & REBECCA MAJOR		ENGINEER :- CMG CONSULTING ENGINEERS		DRAFTING ISSUE	07/08/2020	A	DRAWING No :- L010LEI
		ABN:- 74 056 137 574			BUILDER :- RICHARDSONS BUILDING SERVICE		ENGINEERING ISSUE	02/10/2020	B	
							CONSTRUCTION ISSUE	06/10/2020	C	

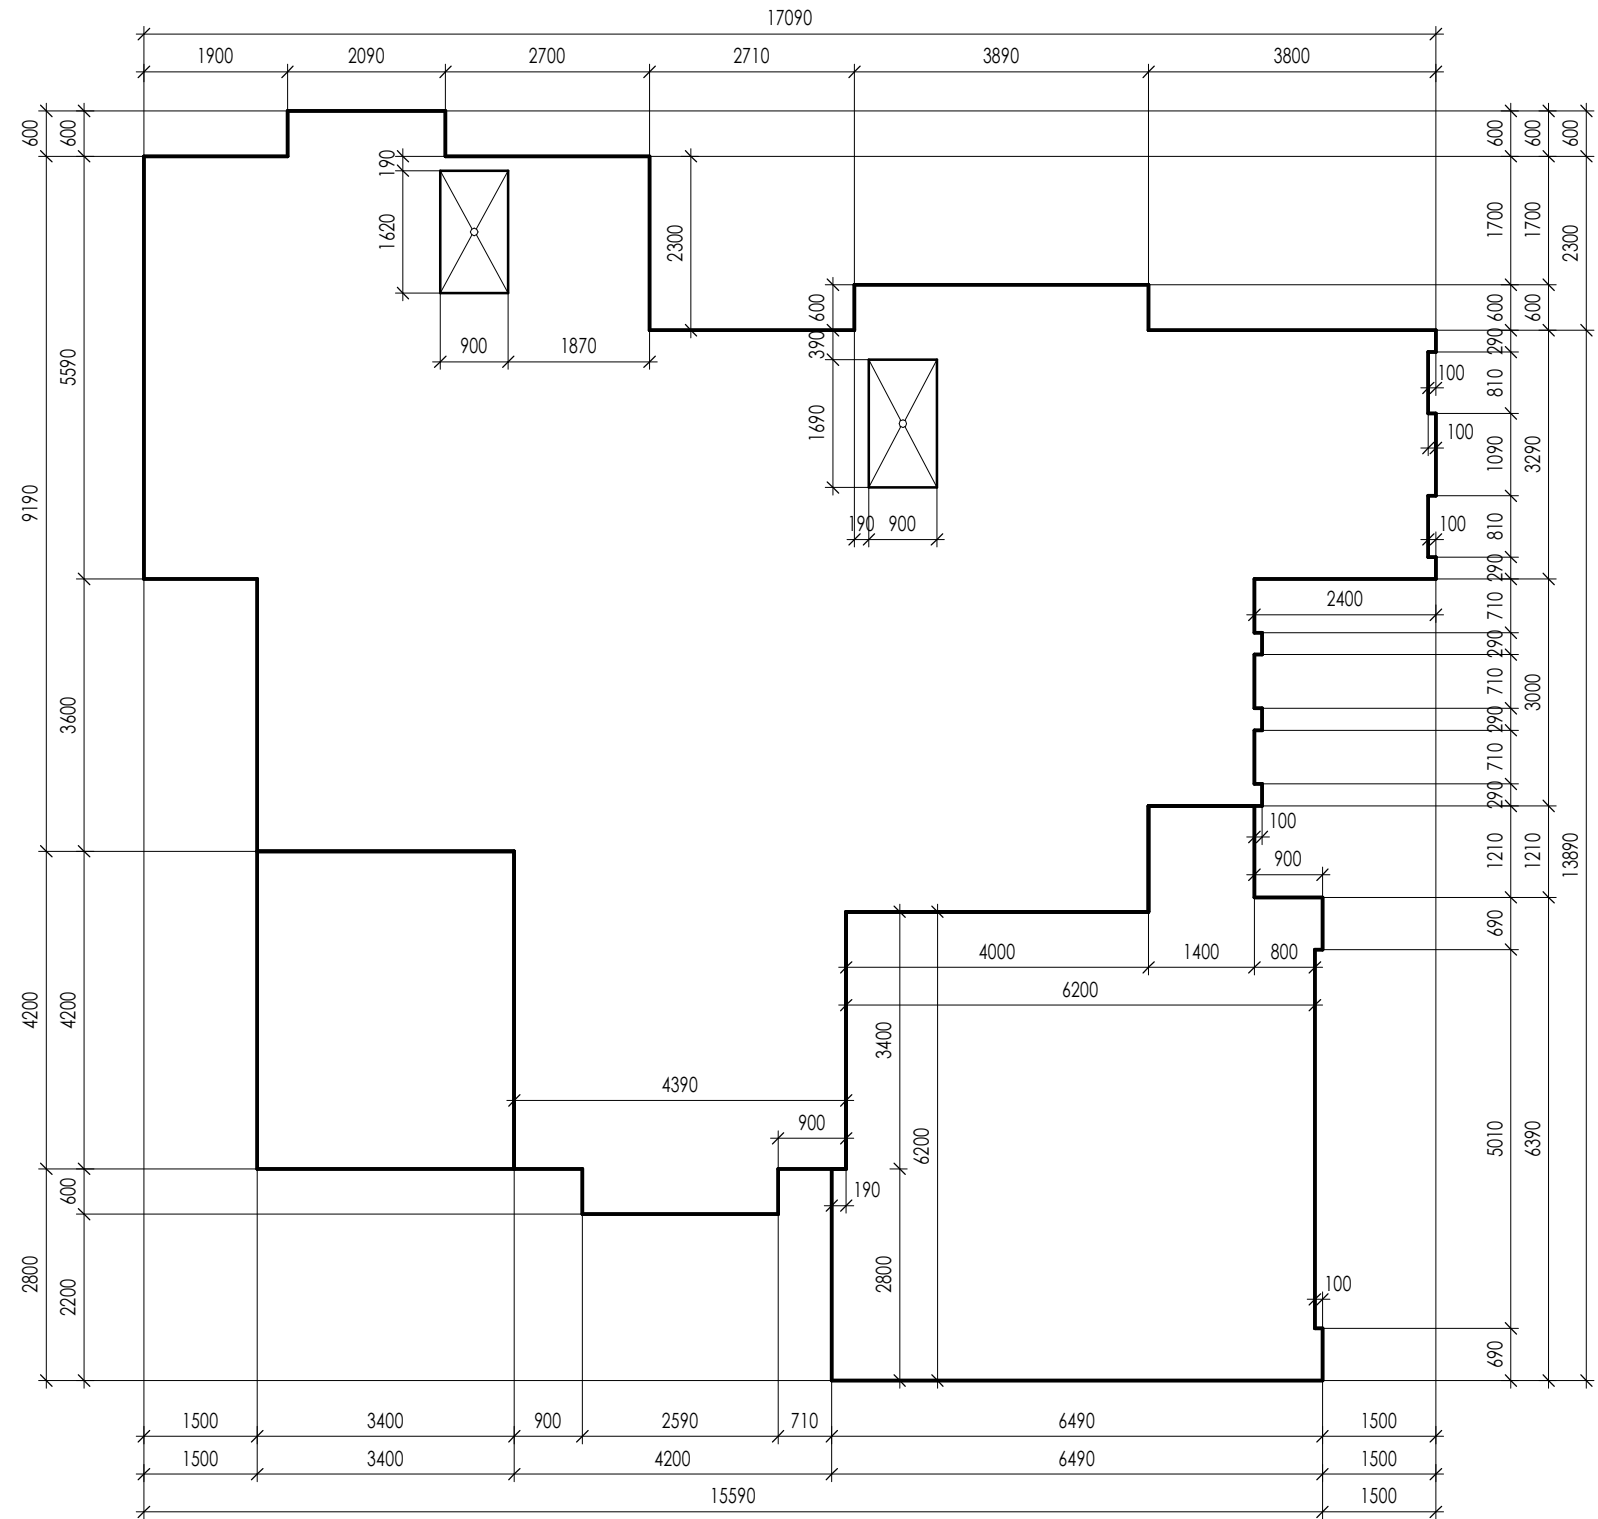


  **SLAB SET-OUT PLAN**
SCALE 1 : 100

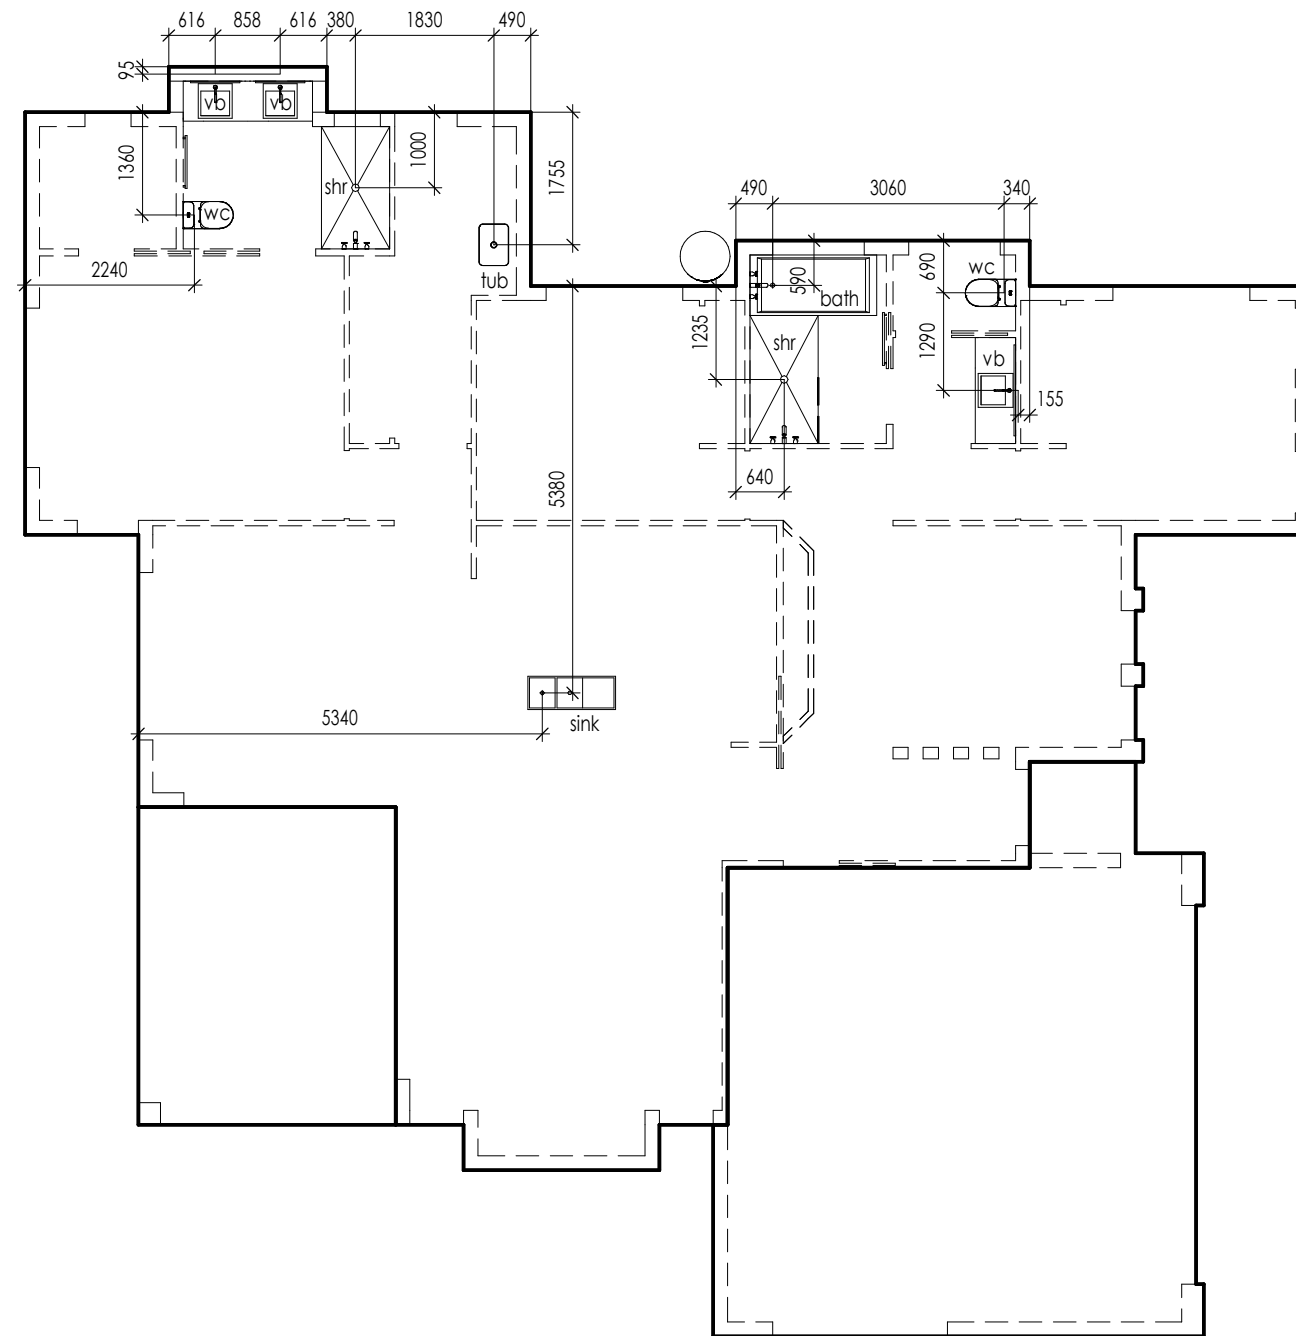


 NOTE :
ALL DIMENSIONS ARE APPROX. ONLY
BUILDER TO CHECK & CONFIRM ON SITE


 **PLUMBING SET-OUT PLAN**
SCALE 1 : 100

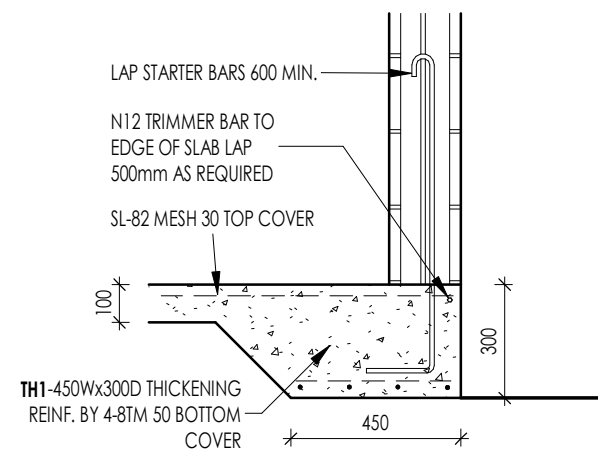


TH1
WD07
SCALE 1 : 20

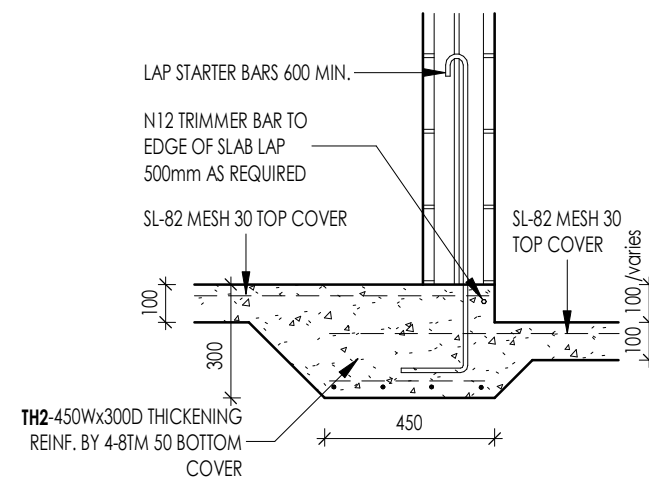


TH2
WD07 SCALE 1 : 20

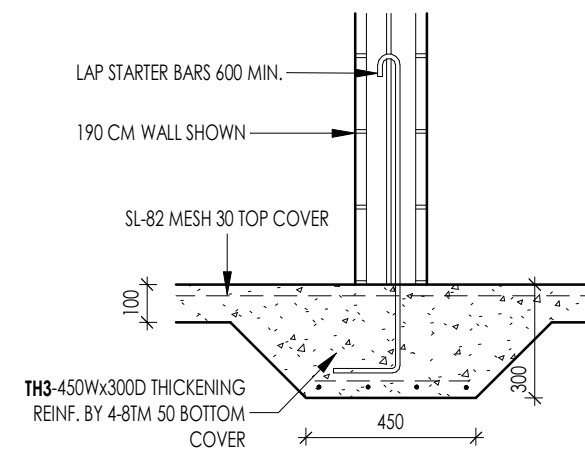


TH3
WD07
SCALE 1 : 20

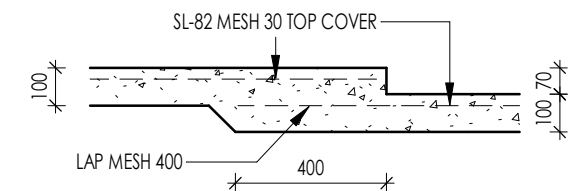

TH4
WD07
SCALE 1 : 20

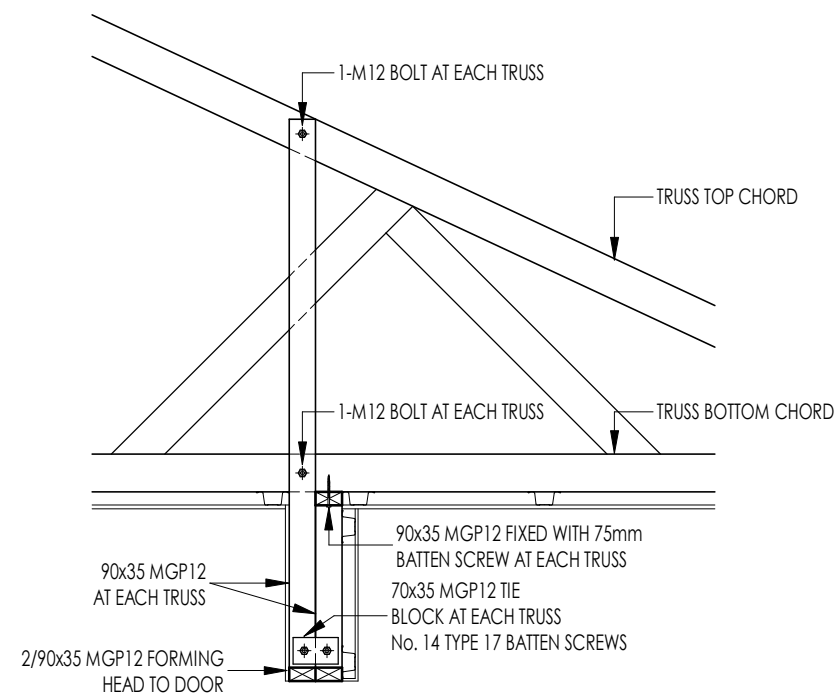

DETAIL 1
SCALE 1 : 20


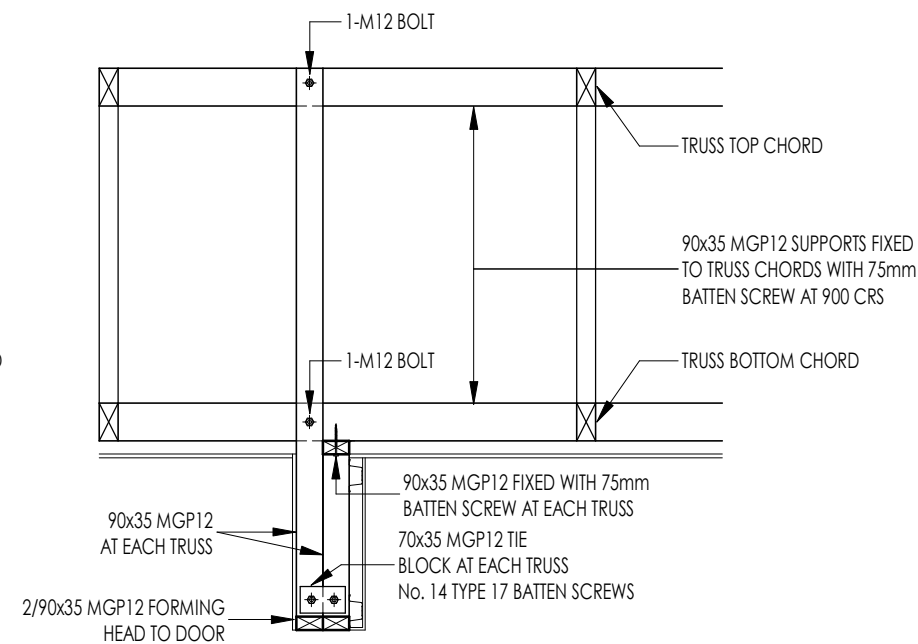


WE HEREBY CERTIFY THE STRUCTURAL DETAILS AS SHOWN IN THESE DRAWINGS FOR CONSTRUCTION IN TERRAIN CATEGORY **C1**

C.M.G. CONSULTING
A.C.N. 011 049 375

ENGINEERS PTY. LTD.





208 BUCHAN ST.
CAIRNS QLD. 4870
PH 07 4031 2775
FAX 07 4051 9013

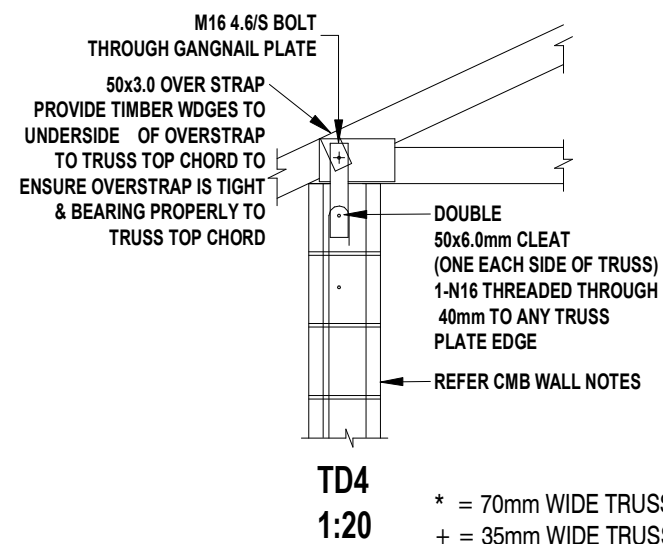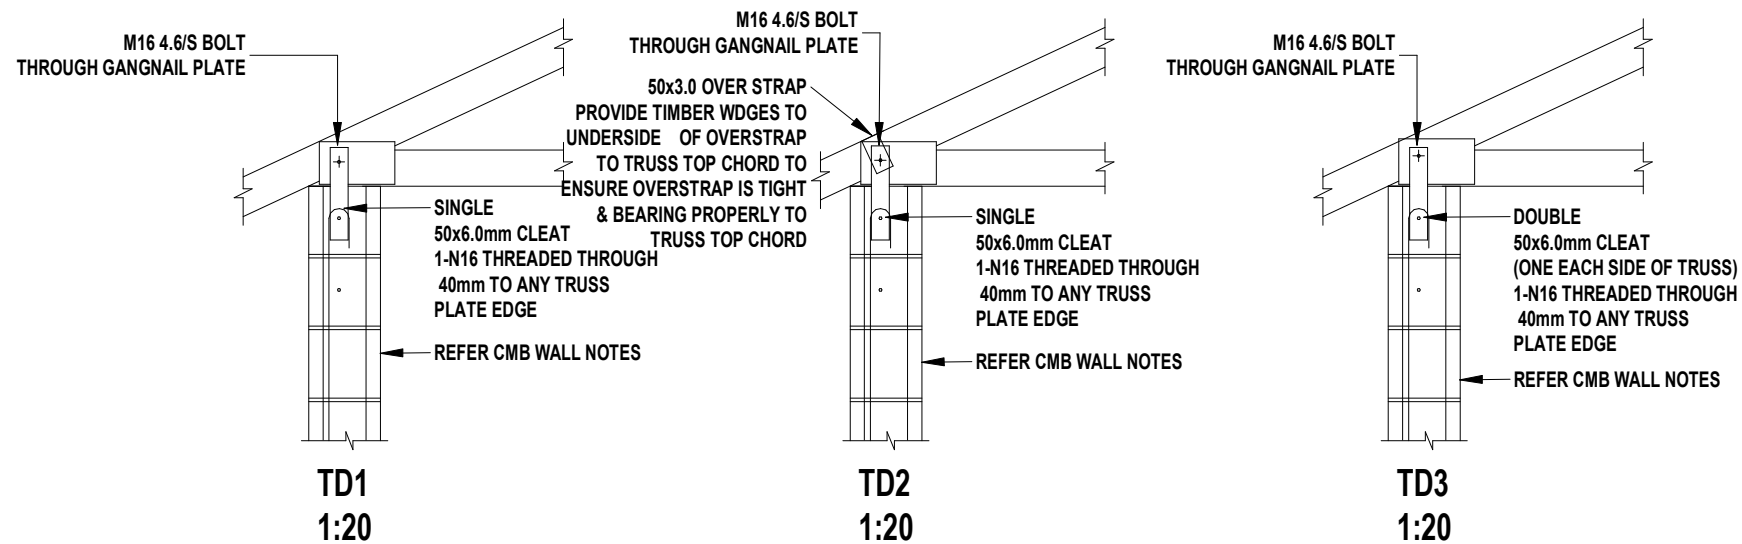

UPLIFT RESISTANCE kN
(ULTIMATE LIMIT STATE)

TYPE	TRUSS JOINT GROUP					
	J2	J3	J4	JD4	JD5	JD6
TD1	20	15	10	16	11	8
TD2	35	25	16	23	18	15
TD3	49	44	28	36	36	28
TD4	76	54	34	54	43	34
TD5	20	15	10	18	11	8
TD6	49	44	28	36	36	28
TD7*	76	72	53	70	61	53
TD7+	52	42	33	38	36	24
TD8*	102	102	73	38	94	73

NOTE: PROVIDE 2-N12 (MIN.) VERTICAL REINF. BARS ADJACENT TO CLEATS WITH TIE-DOWN LOADS GREATER THAN 80kN

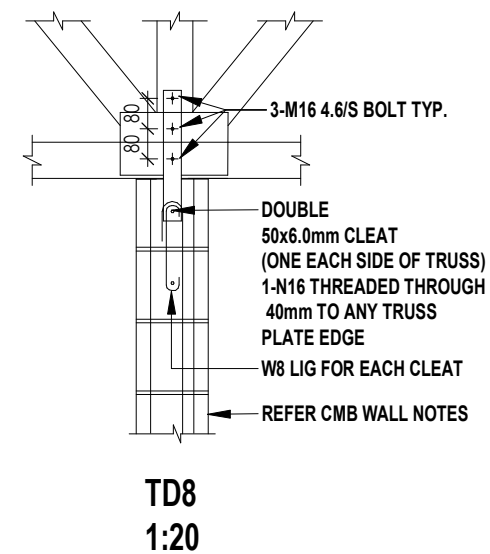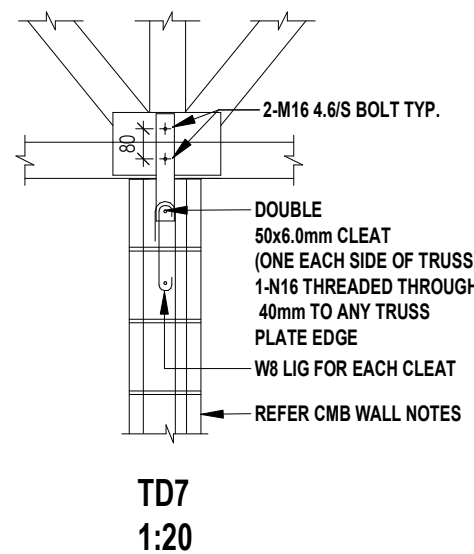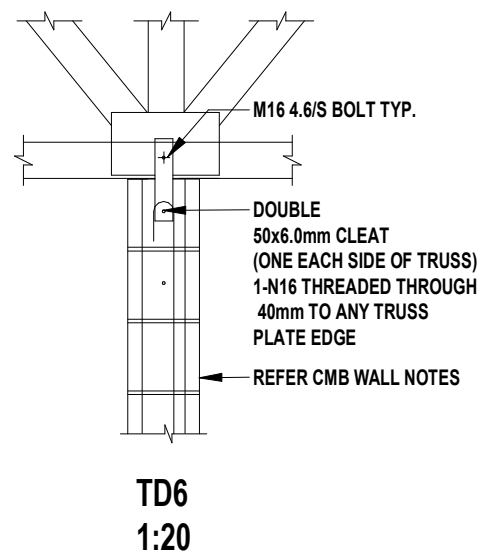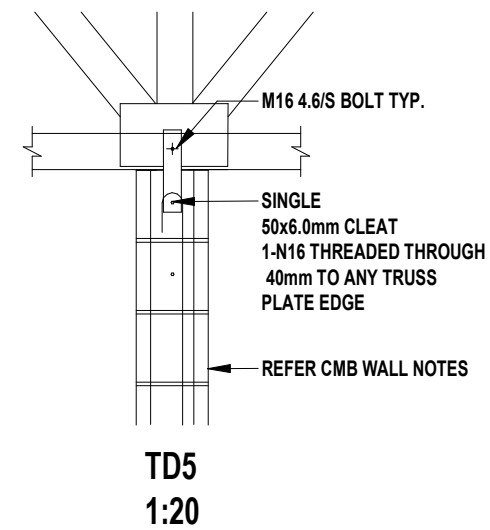


TRUSS TIE-DOWN (CM WALLS)
SCALE 1 : 20

NOTE: CLEAT SIZES AND CONNECTIONS SIMILAR FOR RHS BEAMS

(REFER TRUSS MANUF. LAYOUT AND UPLIFT LOADING) ALL BOLTS 4.6/S BOLTS (FUF=400 mPa)

WE HEREBY CERTIFY THE STRUCTURAL DETAILS AS SHOWN IN THESE DRAWINGS FOR CONSTRUCTION IN TERRAIN CATEGORY **C1**

C.M.G. CONSULTING ENGINEERS PTY. LTD.
A.C.N. 011 049 375
208 BUCHAN ST. CAIRNS QLD. 4870
PH 07 4031 2775 FAX 07 4051 9013

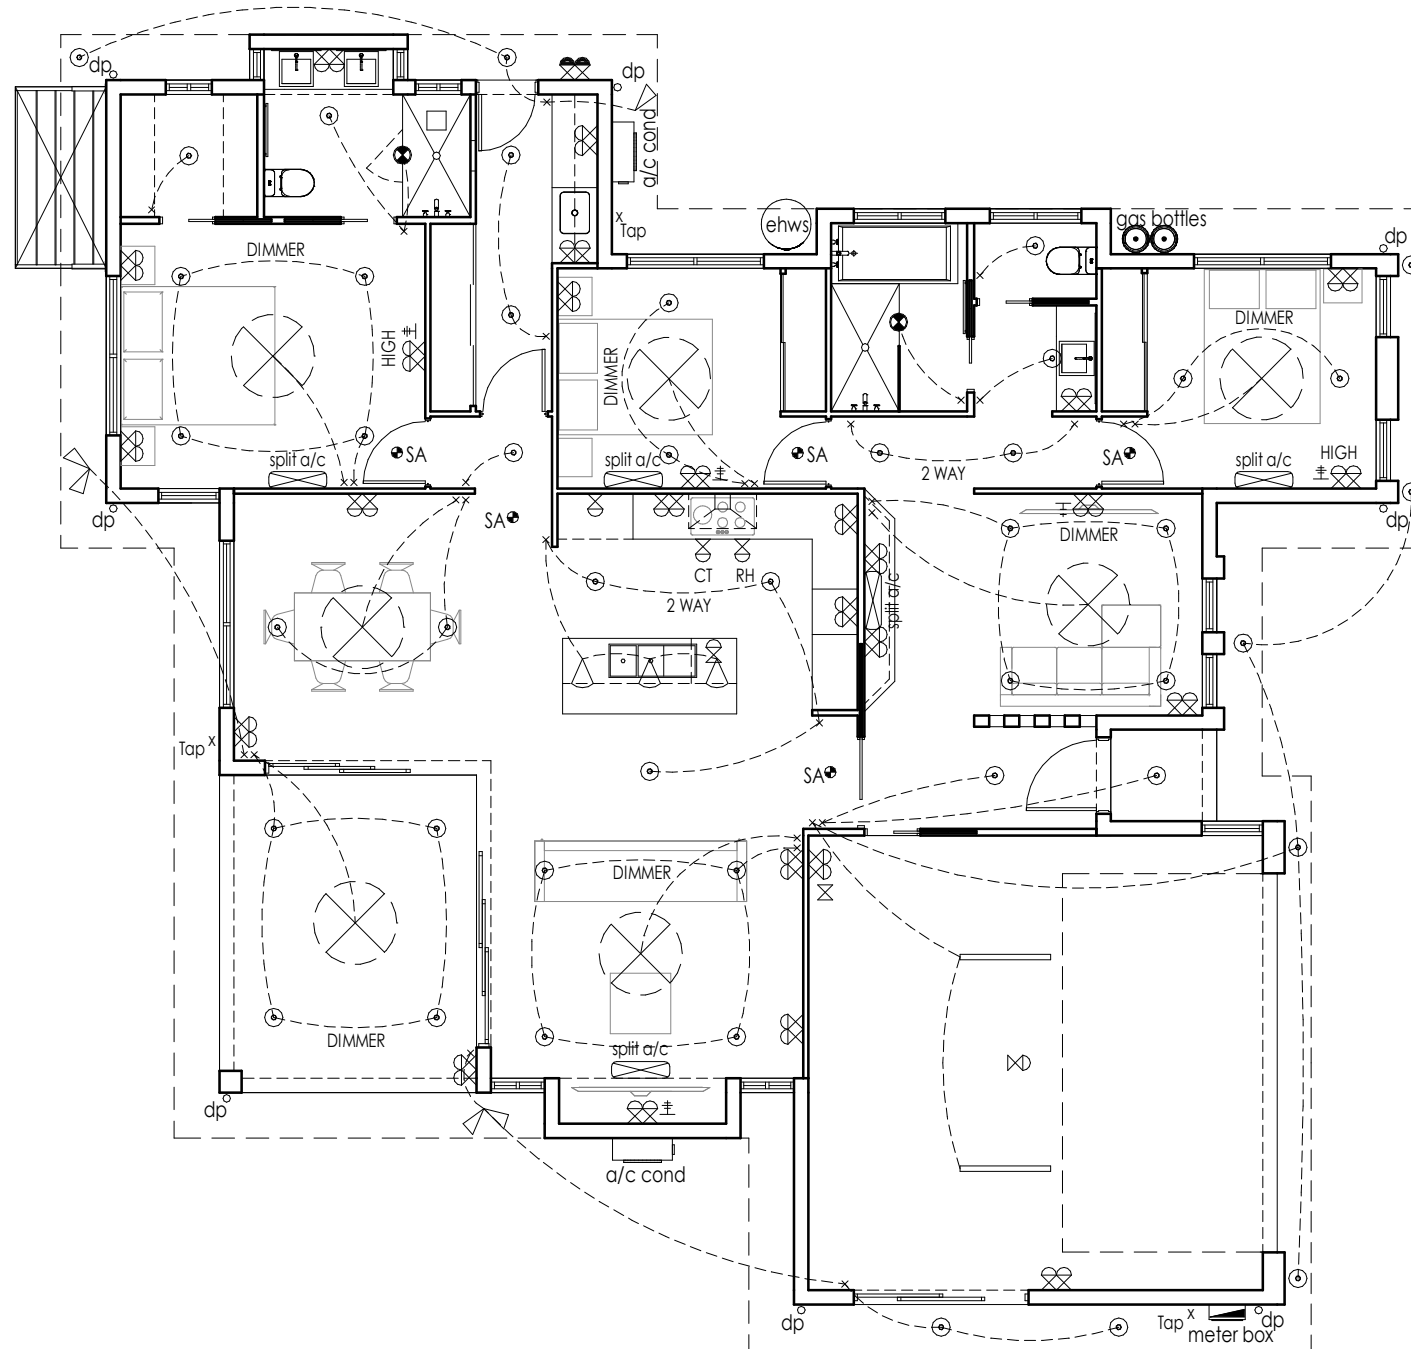


ELECTRICAL LEGEND	
Description	Count

	BATTEN FLUORO	2
	CEILING FAN	7
	DOUBLE G.P.O.	26
	DOUBLE SPOT	2
	DOWNLIGHT L.E.D.	45
	EXHAUST FAN / LIGHT COMBO	2
	N.B.N.	1
	PENDANT LIGHT	3
	SINGLE G.P.O.	5
	SINGLE SPOT	1
	TV OUTLET	5
	WEATHER PROOF DOUBLE G.P.O.	1

	METER BOX	1
--	-----------	---

	SA SMOKE ALARM	5
--	----------------	---

  **ELECTRICAL PLAN**
SCALE 1 : 100



RICHARDSONS BUILDING SERVICE

PH:- (07) 4033 7426

QBCC:- 70164

ABN:- 74 056 137 574

PROJECT :-
PROPOSED RESIDENCE

CLIENT :-
**BRENDAN COURT &
REBECCA MAJOR**

PROJECT ADDRESS :-
**LOT 10 LEIGHTON CRESCENT,
GORDONVALE**

DRAWN :-
L. OZOLINS

ENGINEER :-
CMG CONSULTING
ENGINEERS

BUILDER :-
RICHARDSONS
BUILDING SERVICE

SCALE @ A3:
1 : 100


DESIGN WIND VELOCITY :-
C1
CLASSIFICATION

REVISION	DATE	ISSUE
DRAFTING ISSUE	07/08/2020	A
ENGINEERING ISSUE	02/10/2020	B
CONSTRUCTION ISSUE	06/10/2020	C

DATE:- 30/07/2020



DRAWING No :-
L010LEI

SHEET No :-
WD11

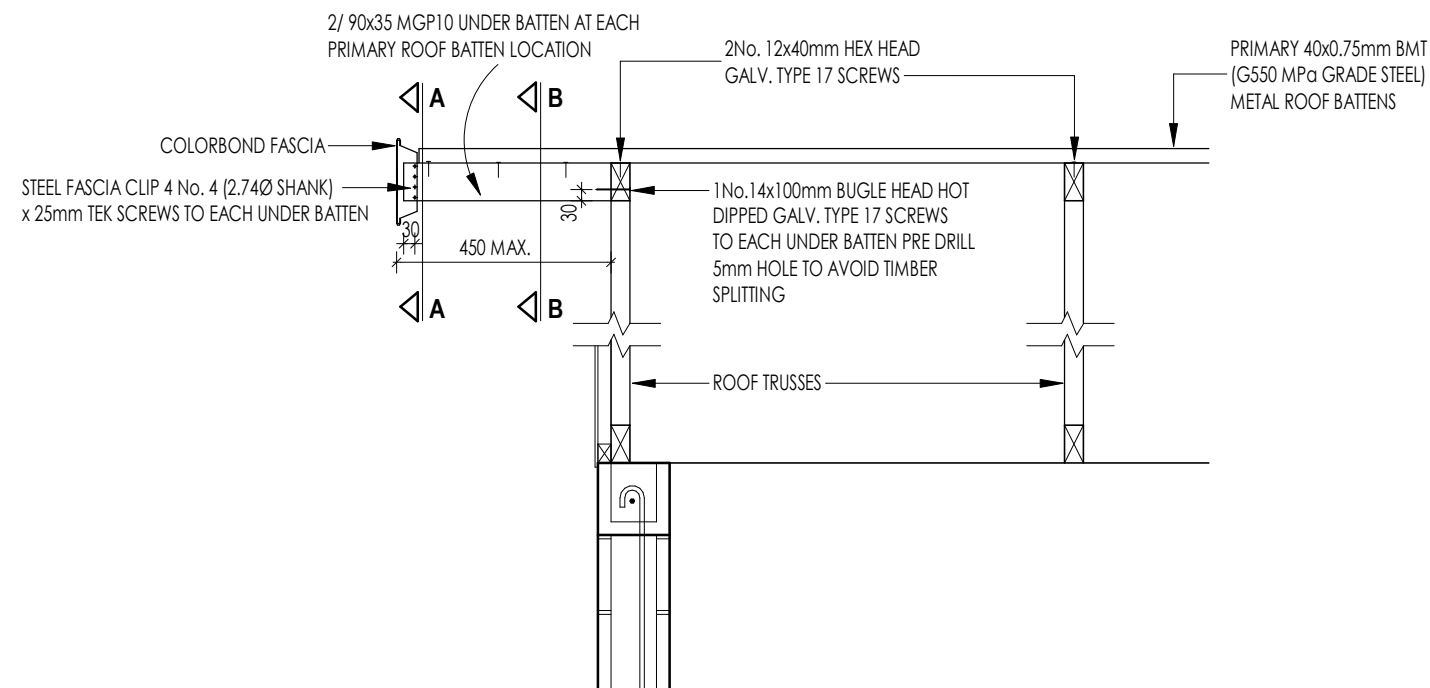



450 ROOF BATTEN OVERHANG DETAILS

1:20

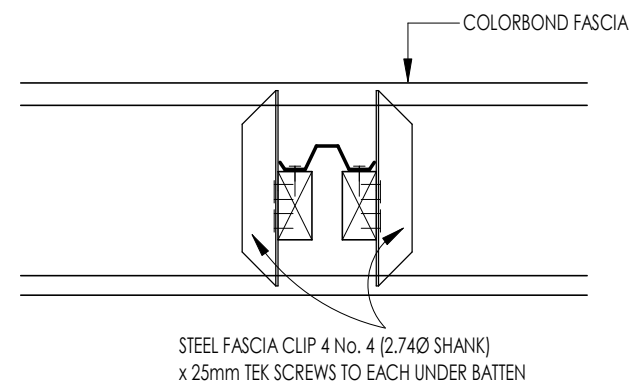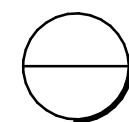


SECTION A

1:10

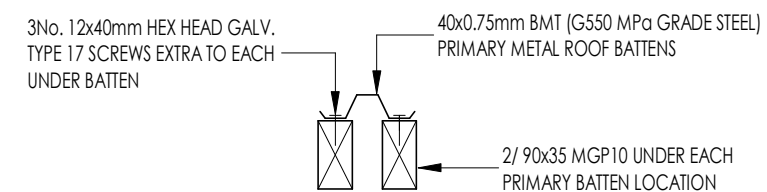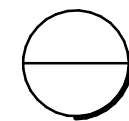

SECTION B

1:10

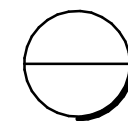

WE HEREBY CERTIFY THE STRUCTURAL DETAILS AS SHOWN IN THESE DRAWINGS FOR CONSTRUCTION IN TERRAIN CATEGORY **C1**

C.M.G. CONSULTING ENGINEERS PTY. LTD.
A.C.N. 011 049 375

208 BUCHAN ST.
CAIRNS QLD. 4870
PH 07 4031 2775
FAX 07 4051 9013

© COPYRIGHT 2020 TO RICHARDSONS BUILDING SERVICE
THIS DESIGN REMAINS THE PROPERTY OF RICHARDSONS BUILDING SERVICE & CANNOT BE COPIED OR REPRODUCED IN WHOLLY OR IN PART WITHOUT THE WRITTEN PERMISSION OR CONSENT FROM RICHARDSONS BUILDING SERVICE



RICHARDSONS BUILDING SERVICE

PH:- (07) 4033 7426

QBCC:- 70164

ABN:- 74 056 137 574

PROJECT :-
PROPOSED RESIDENCE

CLIENT :-
**BRENDAN COURT &
REBECCA MAJOR**

PROJECT ADDRESS :-
**LOT 10 LEIGHTON CRESCENT,
GORDONVALE**

DRAWN :-
L. OZOLINS

ENGINEER :-
CMG CONSULTING
ENGINEERS

BUILDER :-
RICHARDSONS
BUILDING SERVICE

SCALE @ A3:
1 : 100

DESIGN WIND VELOCITY :-
C1
CLASSIFICATION

REVISION	DATE	ISSUE	DATE :- 30/07/2020
DRAFTING ISSUE	07/08/2020	A	DRAWING No :- L010LEI
ENGINEERING ISSUE	02/10/2020	B	
CONSTRUCTION ISSUE	06/10/2020	C	
			SHEET No :- WD12