



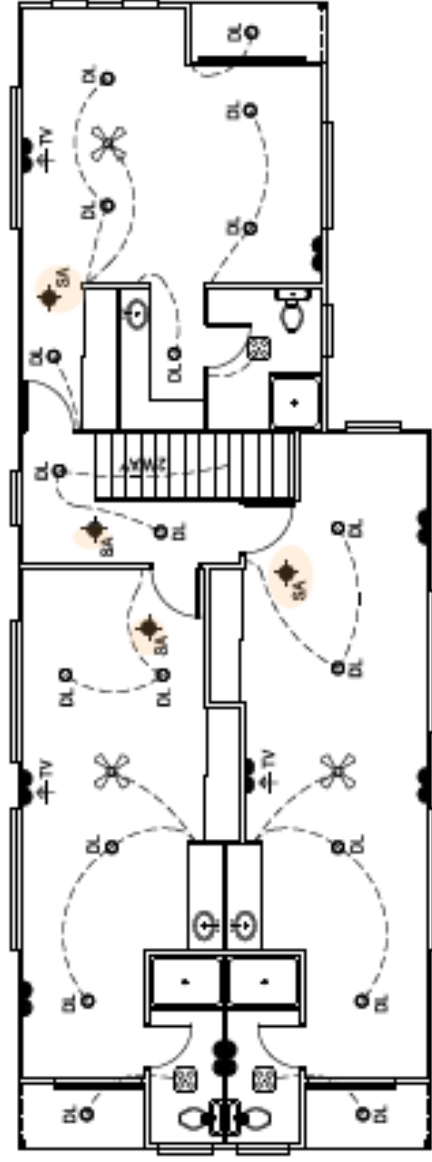

UPPER FLOOR

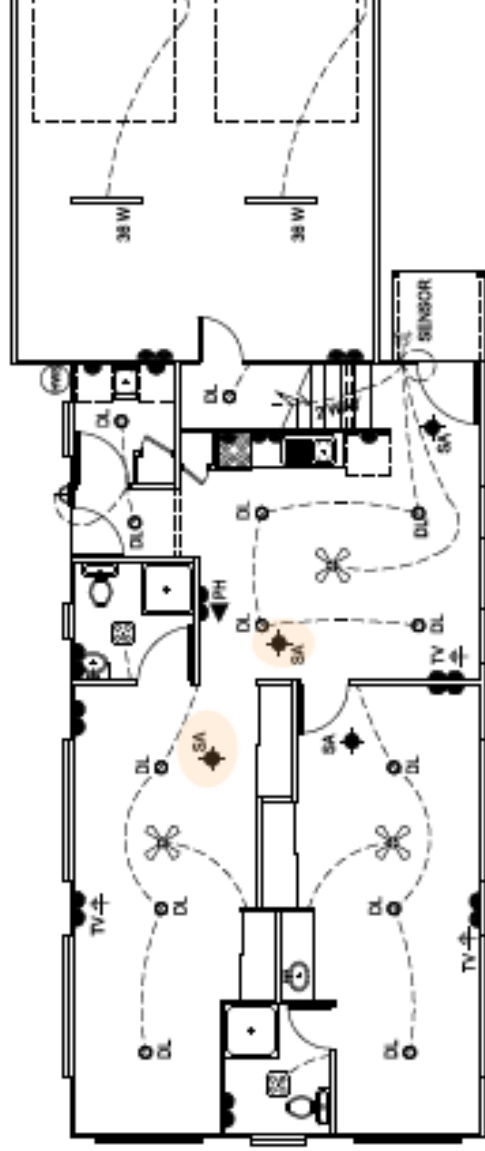

LOWER FLOOR

ELECTRICAL PLANS

Project: Knights construction #18, Jindalee
 Drawn by: NAO
 Date: 22/11/2022

Scale: 1:100
 Sheet: 12
 Revisions: Finals 22/11/2022

SYMBOL	DESCRIPTION
	• CEILING LIGHT
	• WALL LIGHT
	• LED DOWN LIGHT
	• DOUBLE GPO
	• WATERPROOF DOUBLE GPO
	• WATERPROOF SINGLE GPO
	• SINGLE GPO
	• TV SOCKET
	• EXHAUST FAN
	• CEILING FAN
	• CEILING FANLIGHT
	• 36 WATT FLURO
	• 18 WATT FLURO
	• THREE IN ONE DL TASTIC FAN HEATER LIGHT
	• CIRCULAR FLURO LIGHT
	• PHONE POINT
	• SMOKE ALARM
	• TWIN SPOT LIGHT
	• LIGHT SENSOR

ELECTRICAL NOTE :

All construction is to comply with the Building Code of Australia (BCA), the Building Act 1991 and all relevant Australian standards.
 All heights are measured from floor level unless noted otherwise.
 Top of meter box is to be maximum 1950mm above finished ground level.
 All fan and light switches are to be wall plates fixed 1050mm above floor.
 Unless noted otherwise all GPOs are to be located to the nearest stud.