



[illegible]

C:\Users\subbottom\Documents\Revit Local Files\3617 Full : ... 3617.rvt
25/05/2018 4:56:08 PM

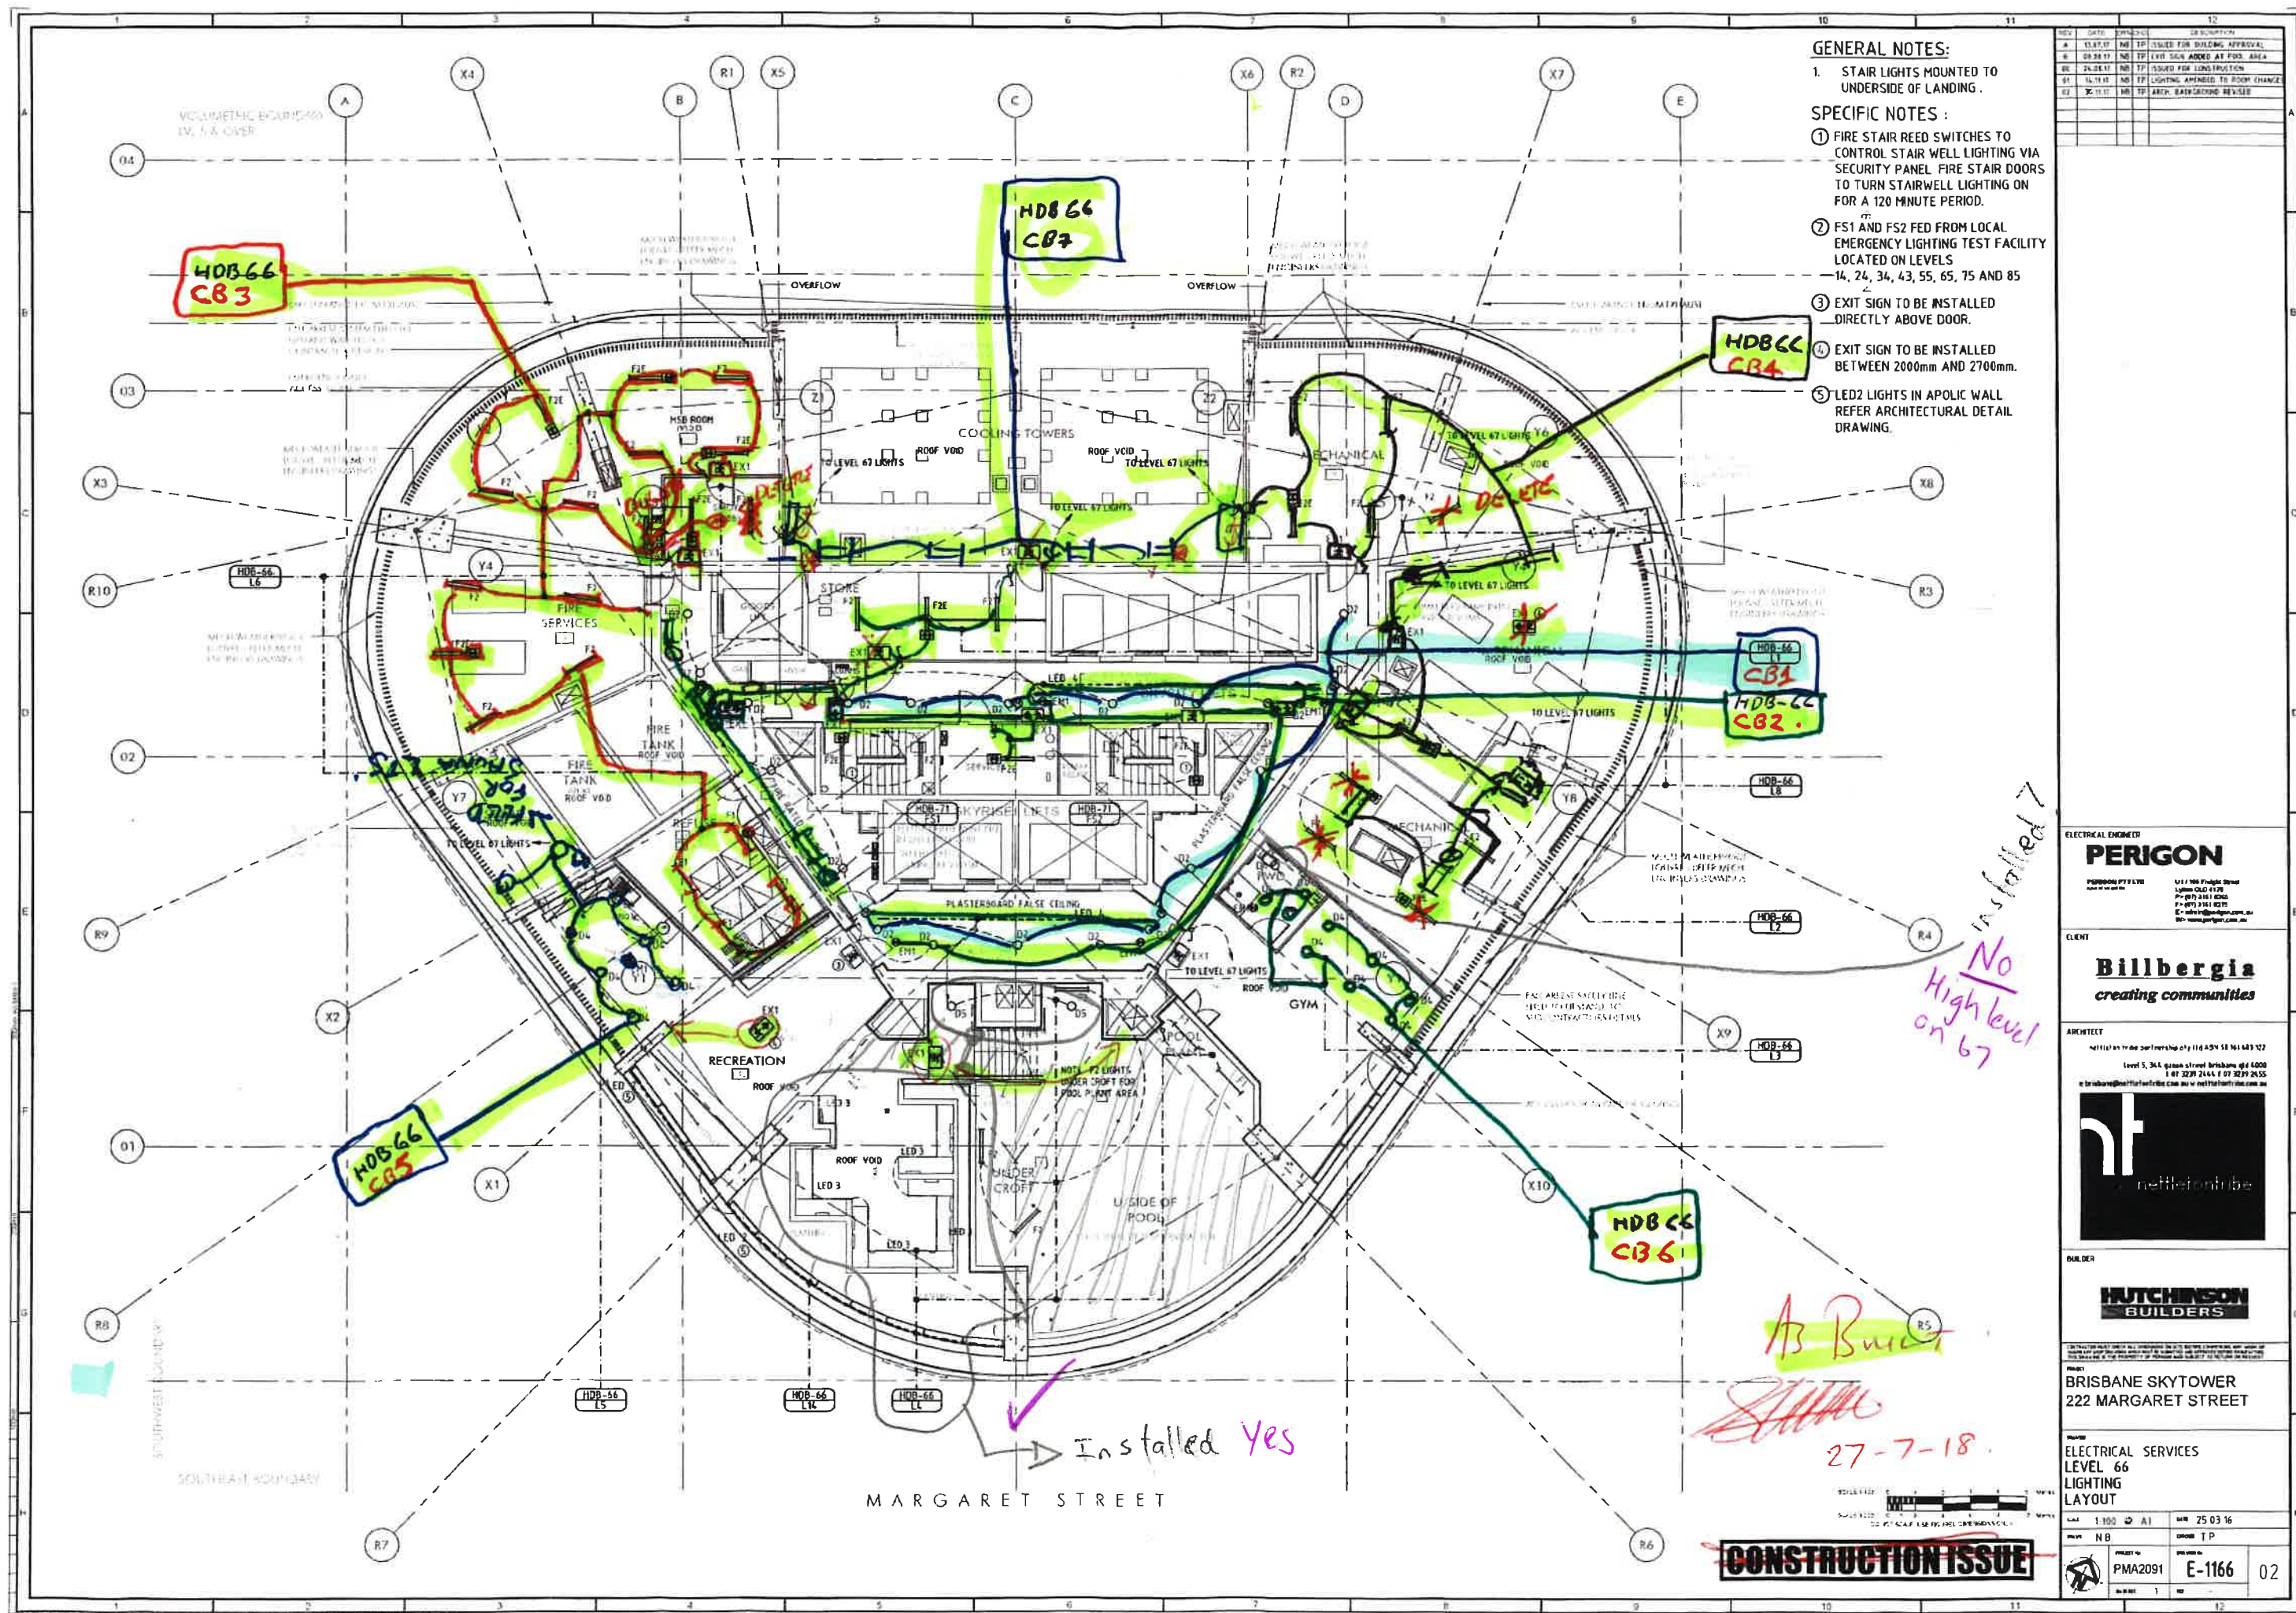

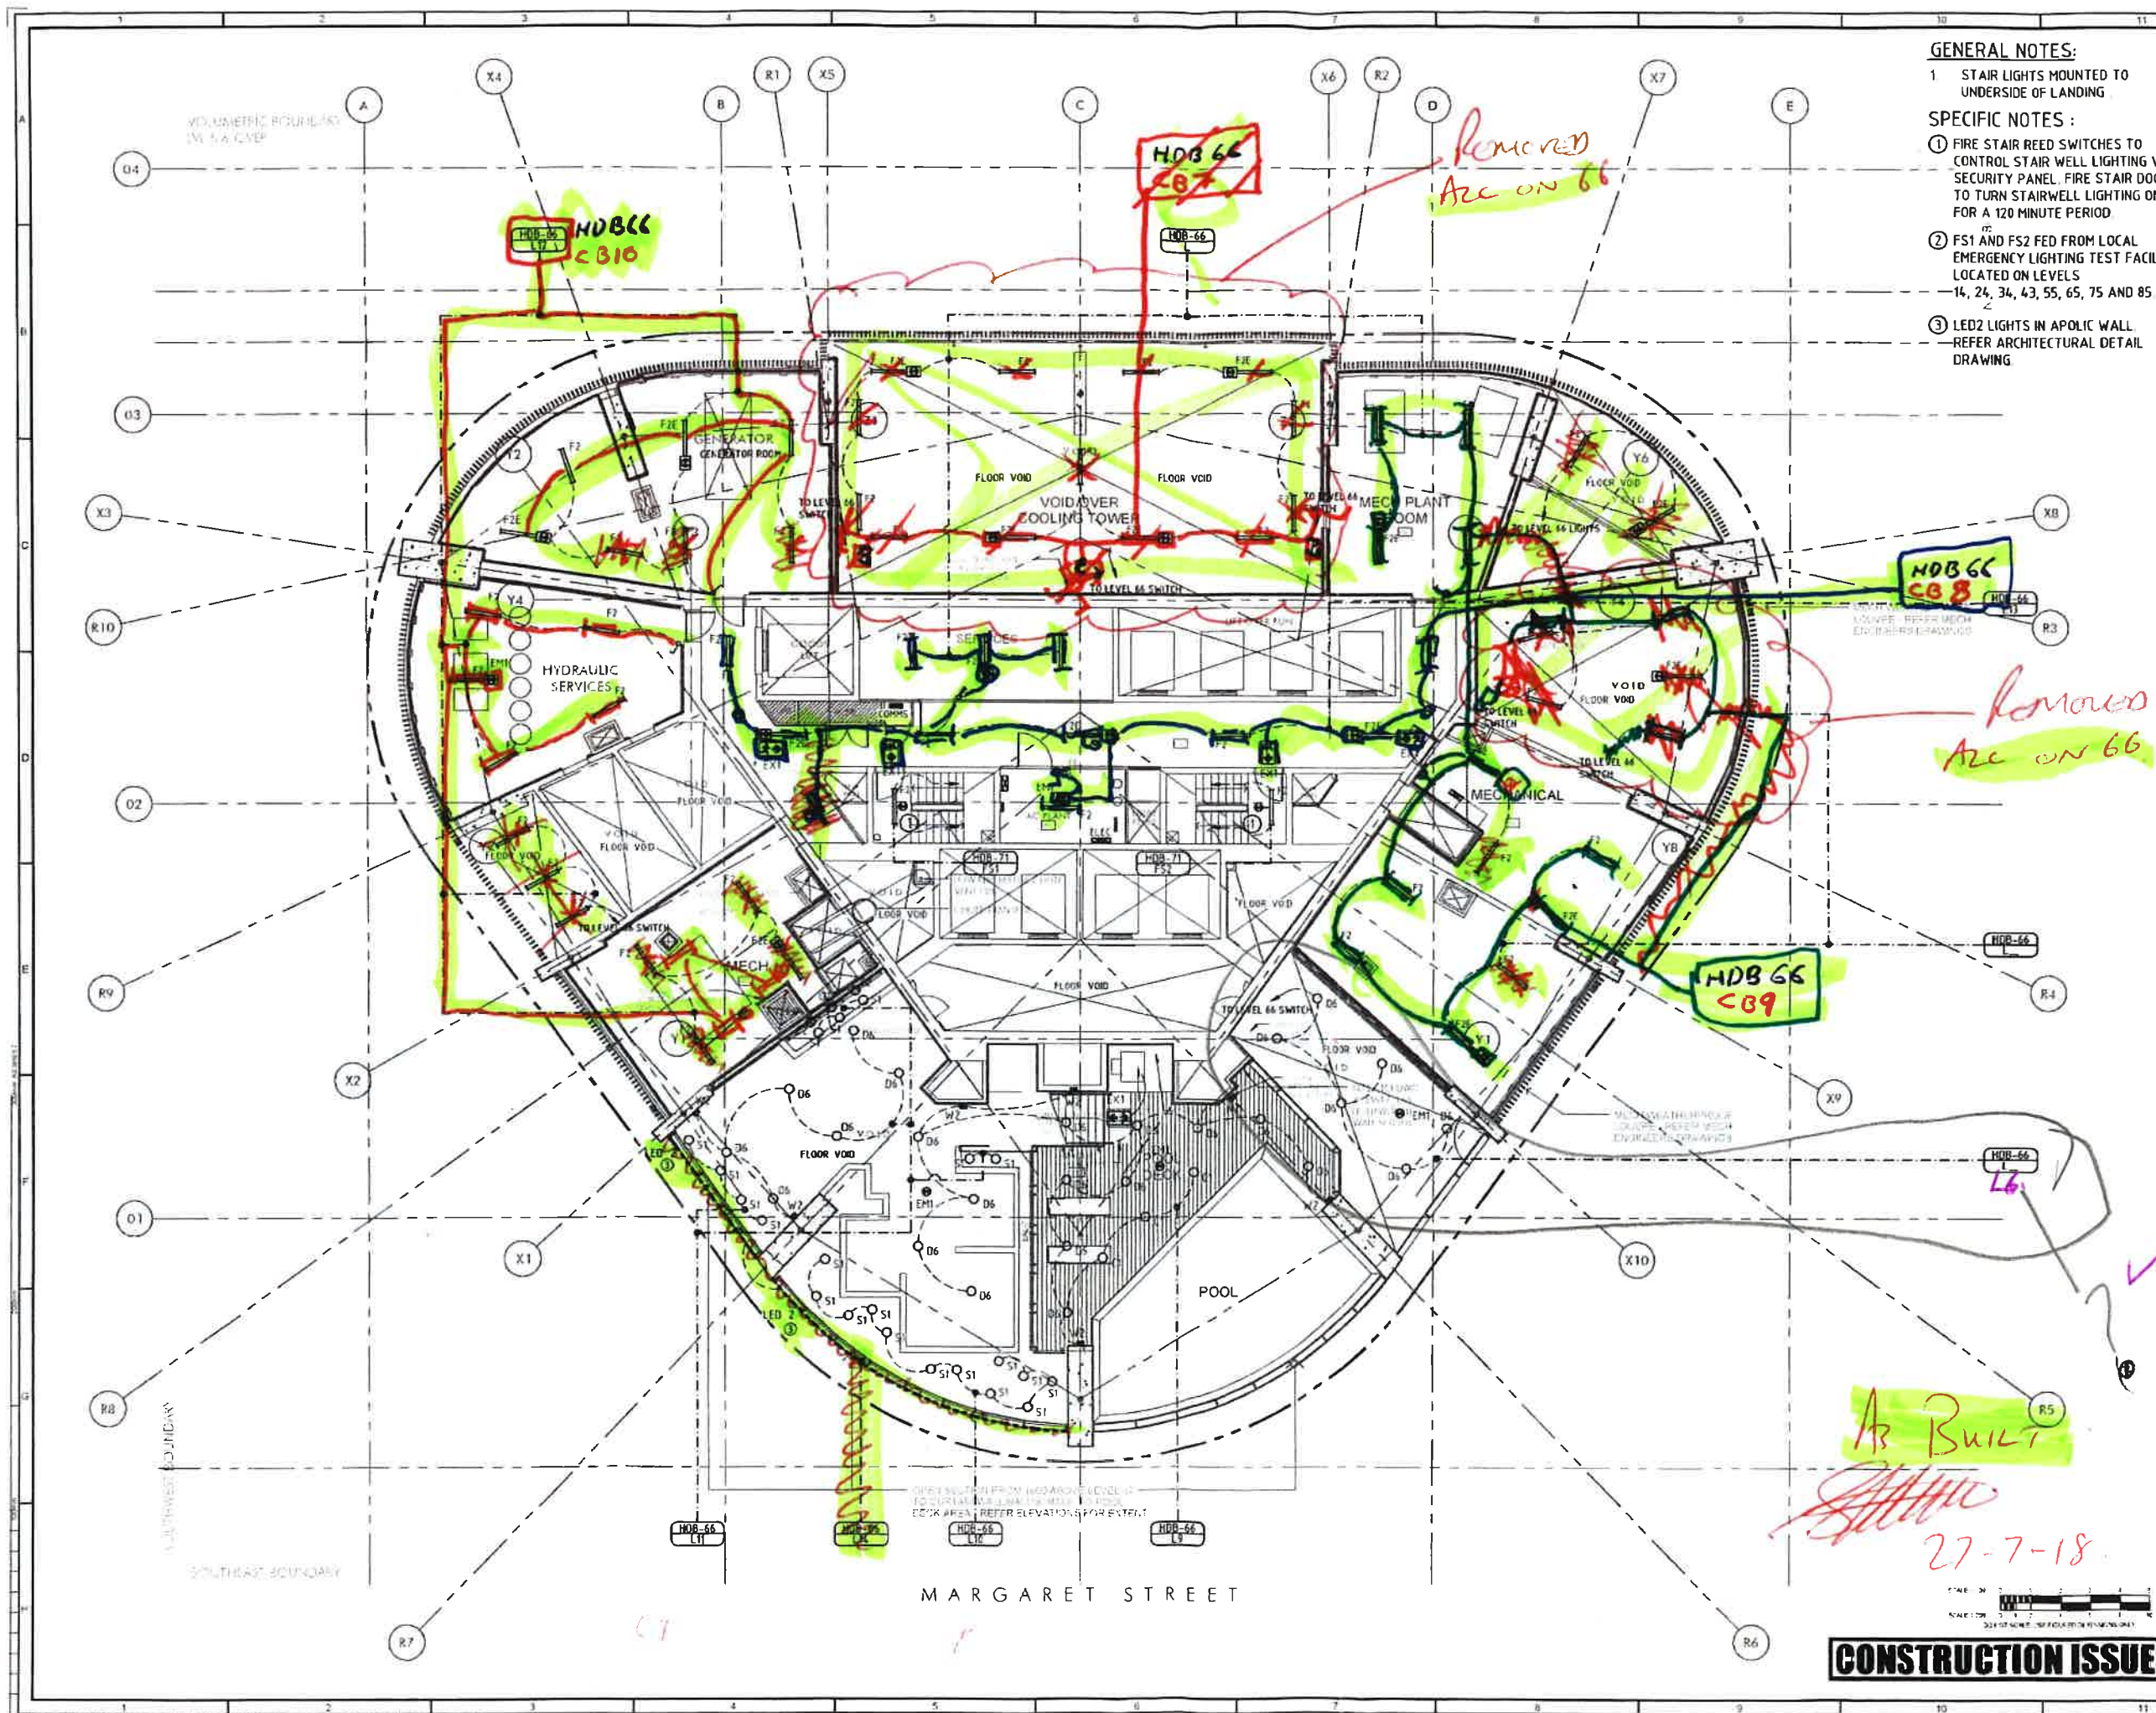

GENERAL NOTES:

- 1 STAIR LIGHTS MOUNTED TO UNDERSIDE OF LANDING

SPECIFIC NOTES:

- 1 FIRE STAIR REED SWITCHES TO CONTROL STAIR WELL LIGHTING VIA SECURITY PANEL. FIRE STAIR DOORS TO TURN STAIRWELL LIGHTING ON FOR A 120 MINUTE PERIOD.
- 2 FS1 AND FS2 FED FROM LOCAL EMERGENCY LIGHTING TEST FACILITY LOCATED ON LEVELS 14, 24, 34, 43, 55, 65, 75 AND 85.
- 3 LED2 LIGHTS IN APOLIC WALL. REFER ARCHITECTURAL DETAIL DRAWING.

REV	DATE	DESCRIPTION
A	15.07.17	ISSUED FOR BUILDING APPROVAL
B	24.08.17	ISSUED FOR CONSTRUCTION
C	15.11.17	LIGHT LAYOUT CHANGED FOR VOIDS
D	05.12.17	ARCH. BACKGROUND REVISED

ELECTRICAL ENGINEER
PERIGON
PERIGON PTY LTD
1/11 100 Knight Street
Lymington QLD 4178
Ph: 07 3239 7444
Fax: 07 3239 7455
E: info@perigon.com.au
W: www.perigon.com.au

CLIENT
Billbergia
creating communities

ARCHITECT
nettletontribe partnership Pty Ltd ABN 54 861 683 122
Level 5, 344 Queen Street Brisbane QLD 4000
Ph: 07 3239 7444 F: 07 3239 7455
e: brisbane@nettletontribe.com.au w: nettletontribe.com.au

nt
nettletontribe


BUILDER
HUTCHINSON BUILDERS

PROJECT
BRISBANE SKYTOWER
222 MARGARET STREET

DISCIPLINE
ELECTRICAL SERVICES
LEVEL 67
LIGHTING LAYOUT

SCALE	1:100	DATE	01.01.17
REV	NB	DATE	17
PROJECT	PMA2091	ISSUE	E-1167
NO	1	OF	02

CONSTRUCTION ISSUE

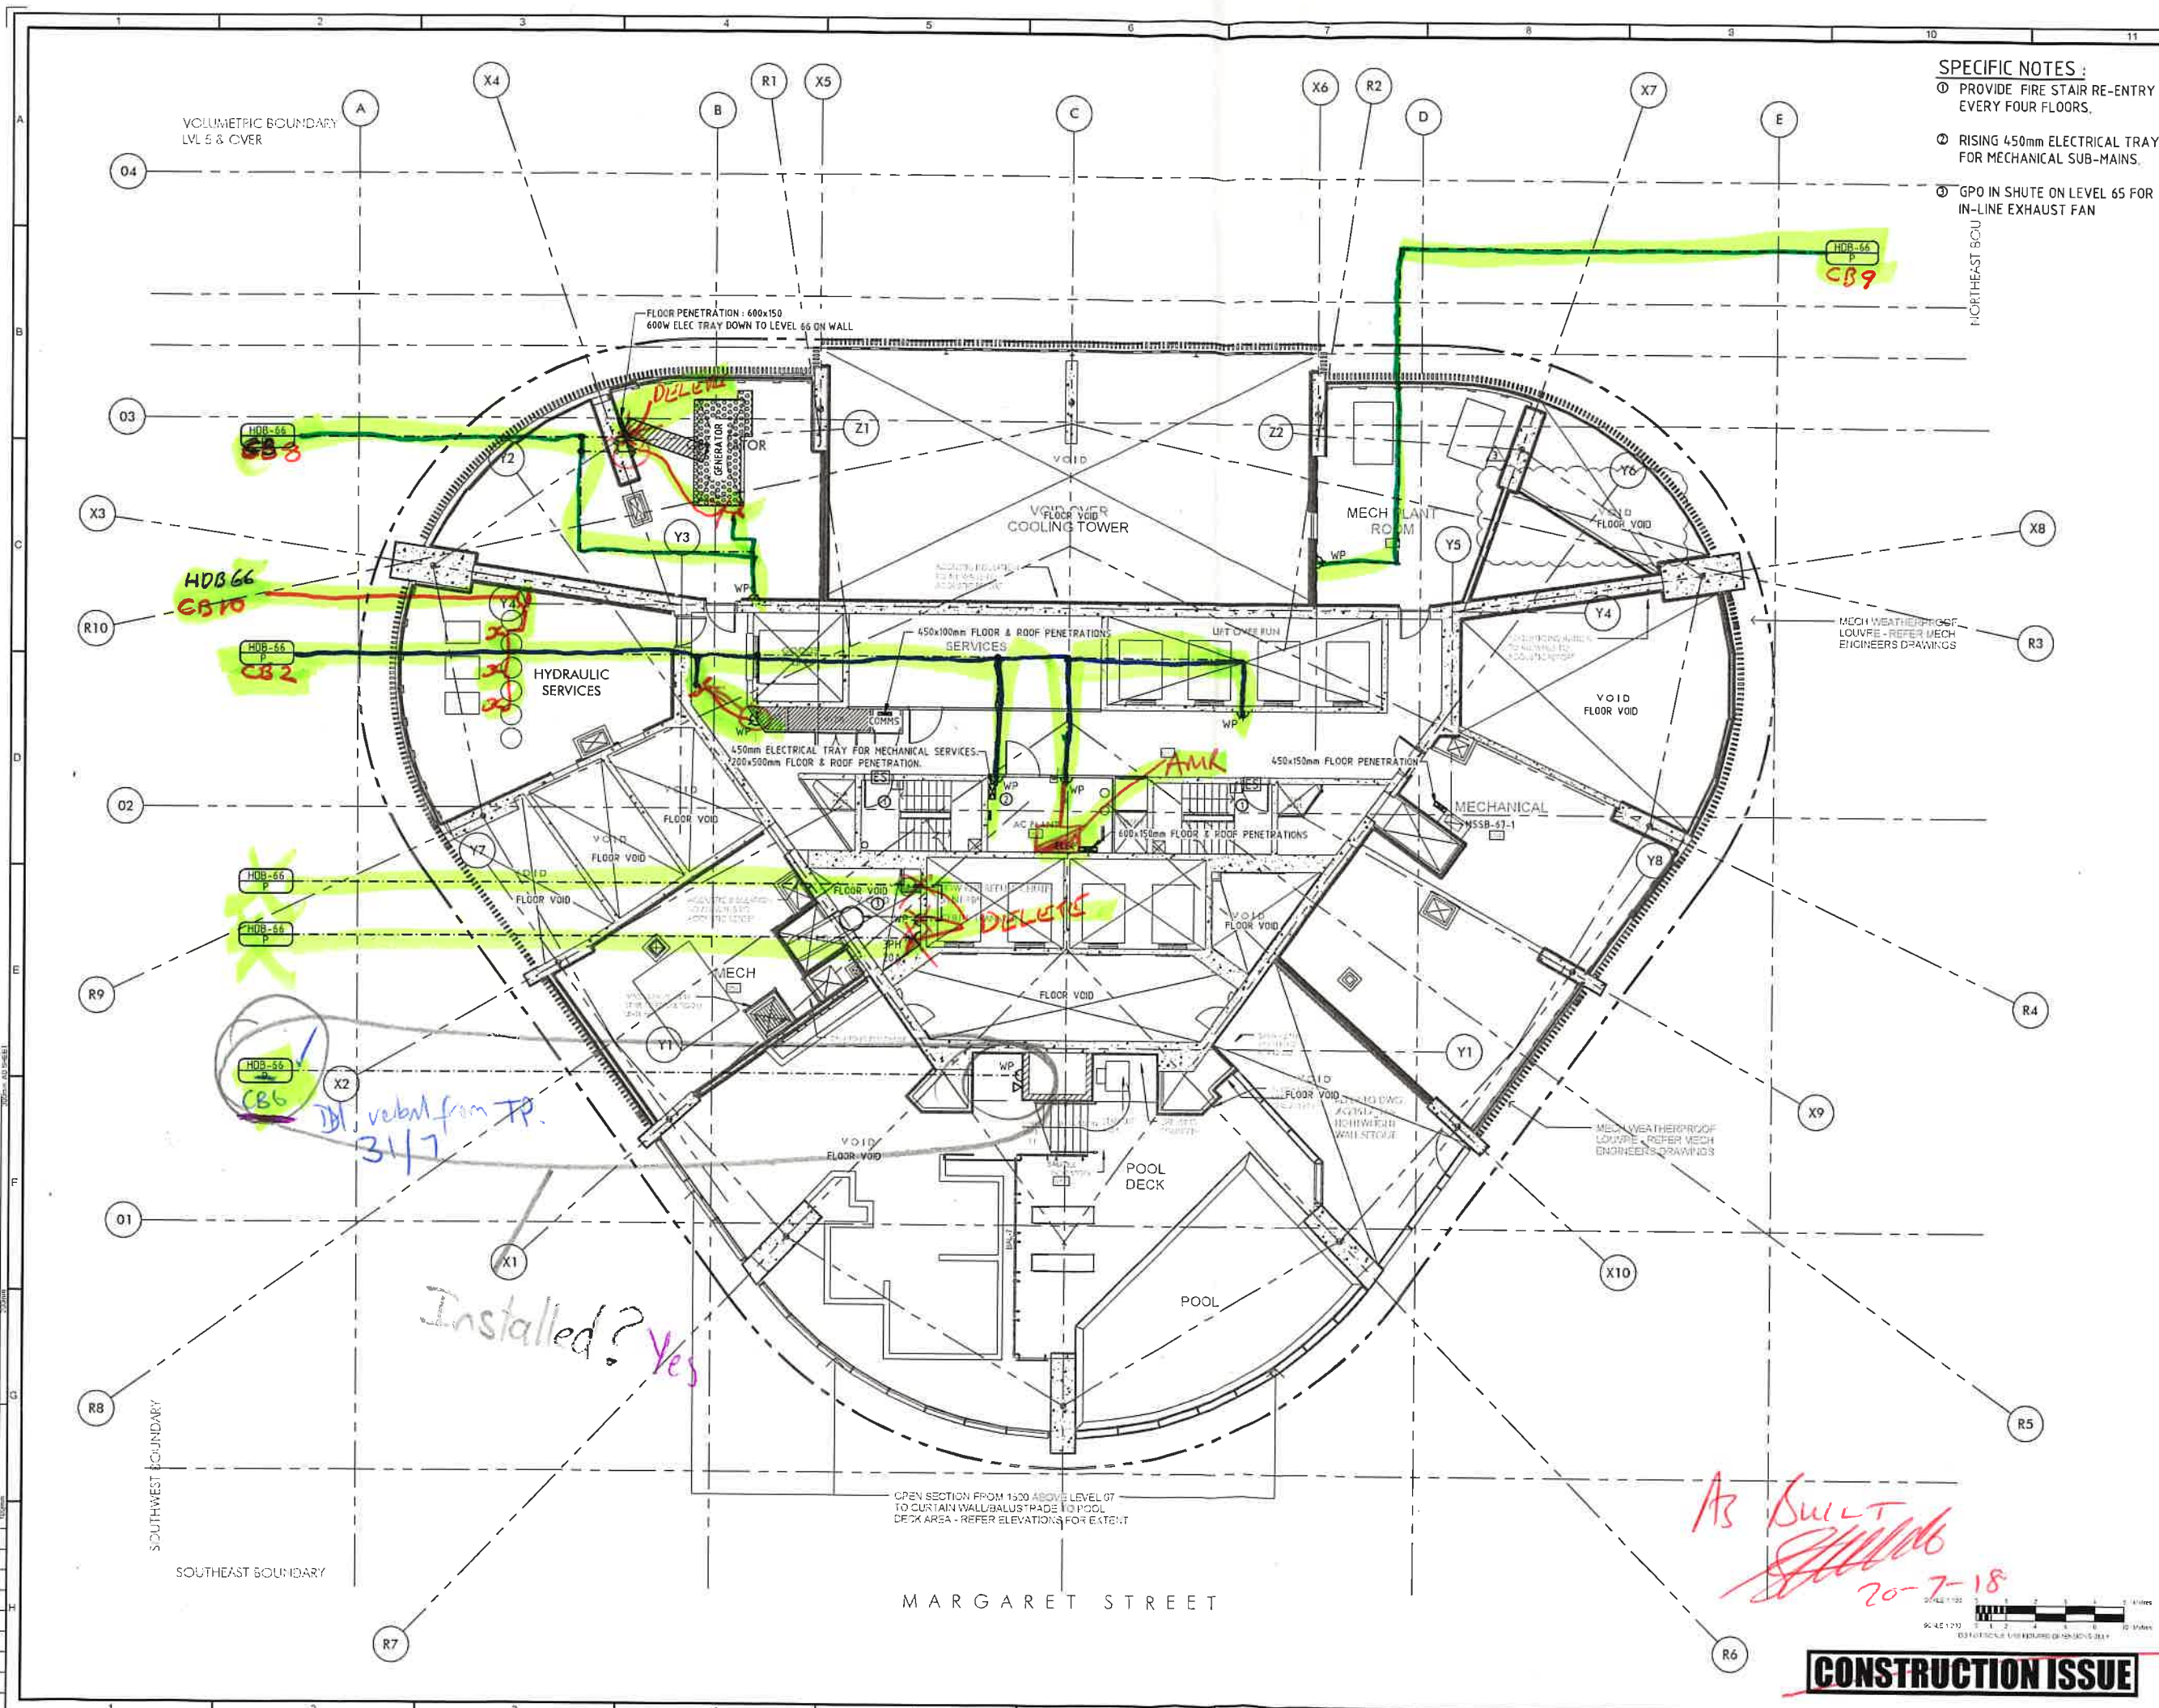

- SPECIFIC NOTES:**
- ① PROVIDE FIRE STAIR RE-ENTRY EVERY FOUR FLOORS.
 - ② RISING 450mm ELECTRICAL TRAY FOR MECHANICAL SUB-MAINS.
 - ③ GPO IN SHUTE ON LEVEL 65 FOR IN-LINE EXHAUST FAN

REV	DATE	BY	TP	DESCRIPTION
A	09.05.17	NB	TP	ISSUED FOR CO-ORDINATION
B	11.07.17	NB	TP	ISSUED FOR BUILDING APPROVAL
C	04.08.17	NB	TP	GENERATOR LOCATED TO LEVEL 47
D	24.08.17	NB	TP	ISSUED FOR CONSTRUCTION
E	10.10.17	NB	TP	PENETRATION LOCATIONS REVISED
F	13.11.17	NB	TP	PENETRATION TO MSSB-47.1 MOVED
G	30.11.17	NB	TP	GPO MOVED TO LEVEL 66

ELECTRICAL ENGINEER
PERIGON
PERIGON PTY LTD
U1 / 105 Princes Street
Lymington QLD 4118
P: (07) 3161 1066
F: (07) 3161 8275
E: enquiries@perigon.com.au
W: www.perigon.com.au

CLIENT
Billbergia
creating communities

ARCHITECT
nettletontribe partnership pty ltd ABN 58 161 683 122
Level 5, 344 Queen Street Brisbane QLD 4000
P: 07 3239 2444 F: 07 3239 2455
e: brisbane@nettletontribe.com.au w: nettletontribe.com.au

nt
nettletontribe

BUILDER
HUTCHINSON BUILDERS

PROJECT
BRISBANE SKYTOWER
222 MARGARET STREET

DRAWING
ELECTRICAL SERVICES
LEVEL 67
POWER, COMMS & SECURITY
LAYOUT

SCALE 1:100 @ A1
DATE 17.10.16
PROJECT NO. PMA2091
DRAWING NO. E-1267
03

CONSTRUCTION ISSUE