
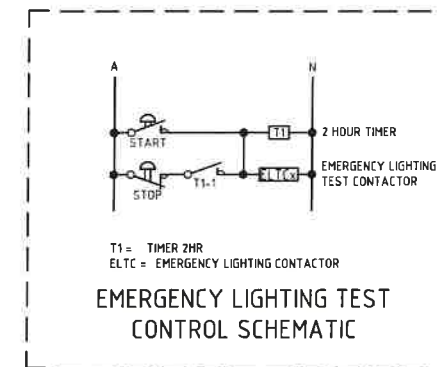


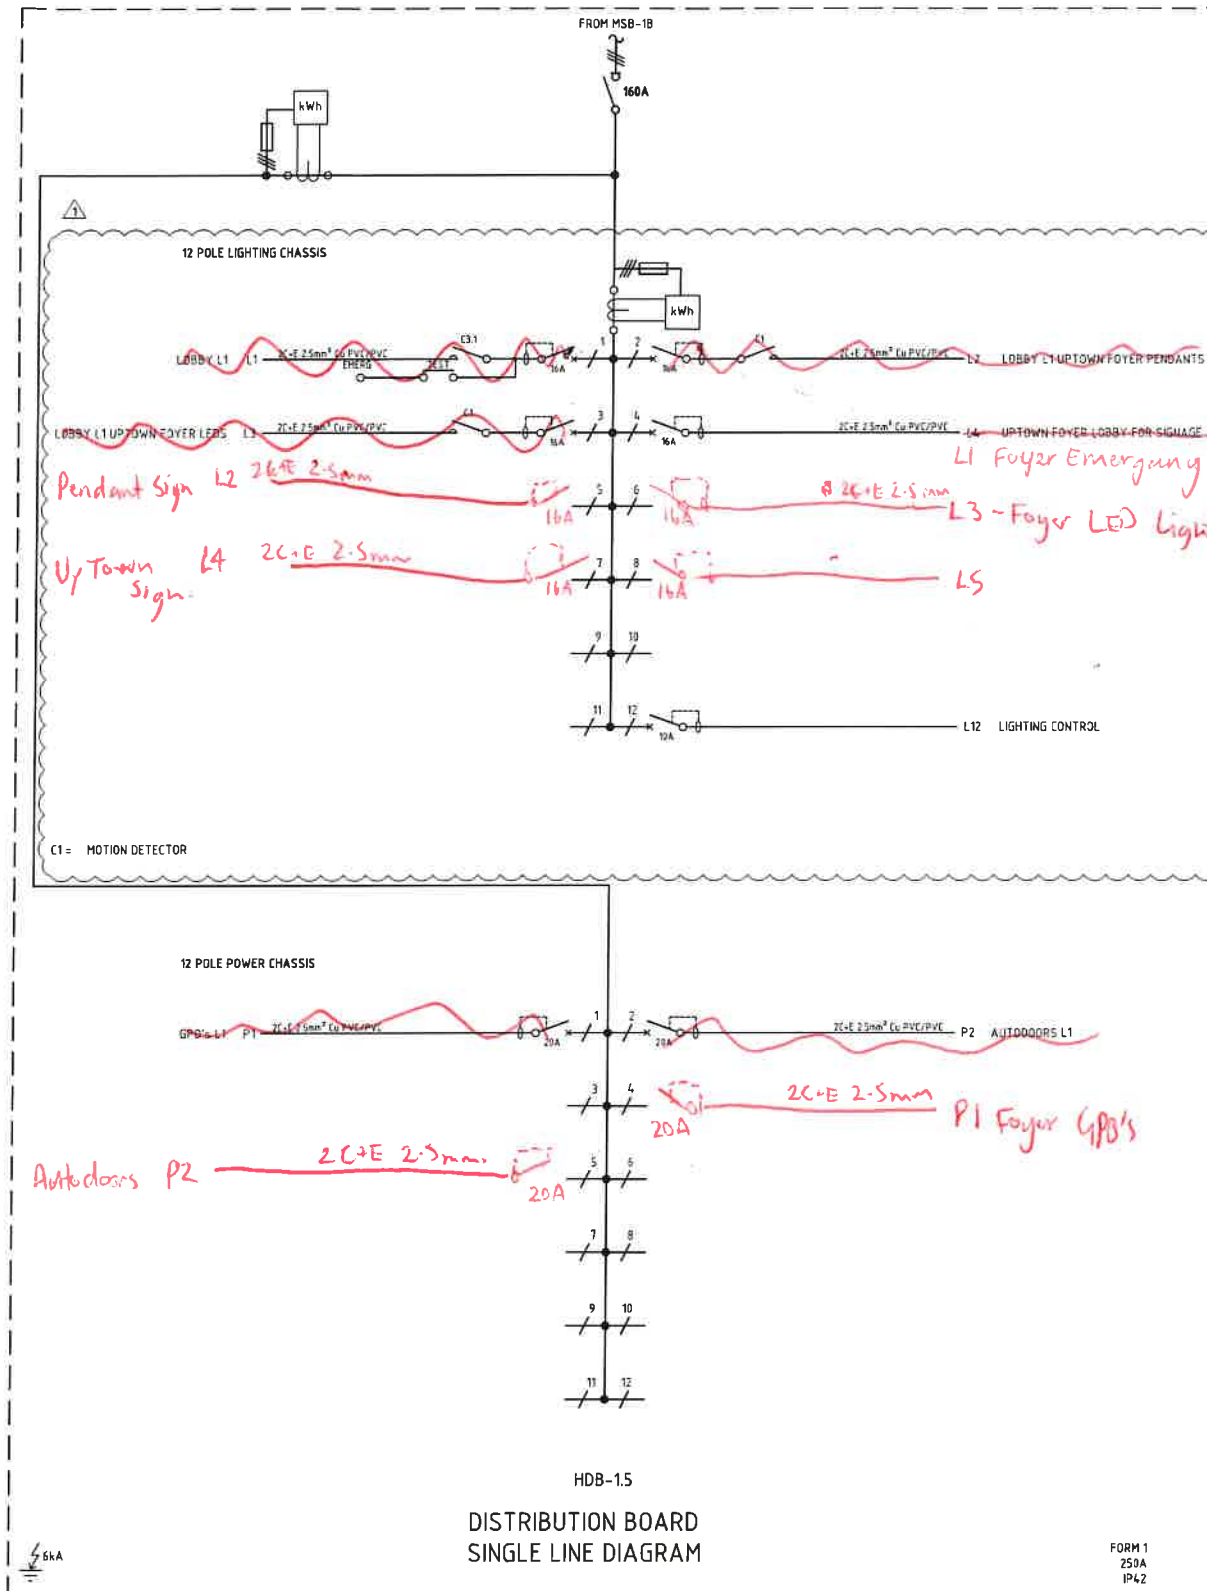

GENERAL NOTES :

1. PROVIDE FAULT CURRENT LIMITING IN ALL SWITCHBOARDS AS REQUIRED.
2. REFER DRAWING 2091-E-1920 FOR CONTROL WIRING.

REV	DATE	BY	CHKD	DESCRIPTION
01	20.09.16	TG	IL	ISSUED FOR REVIEW
02	21.03.17	AB	TP	UPTOWN FOYER LIGHTS ADDED

ELECTRICAL ENGINEER
PERIGON
 PERIGON PTY LTD
 1/1155 Fingert Street
 Lymington QLD 4178
 Ph: (07) 3151 8255
 Fr: (07) 3151 8275
 E: admin@perigon.com.au
 W: www.perigon.com.au

CLIENT
Billbergia
 creating communities

ARCHITECT
 nettletontribe partnership pty ltd ABN 56 161 683 122
 Level 5, 344 Queen Street Brisbane QLD 4000
 T: 07 3236 2444 F: 07 3236 2455
 e: brisbane@nettletontribe.com.au w: nettletontribe.com.au





BUILDER
HUTCHINSON BUILDERS

PROJECT
 BRISBANE SKYTOWER
 222 MARGARET STREET

NAME
 ELECTRICAL SERVICES
 HDB-1.5
 SINGLE LINE DIAGRAM

SCALE	N.T.S.	DATE	20.09.16
DRAWN	TG	CHECKED	IL
PROJECT NO.	PMA2091	DRAWING NO.	E-1922
NO. SHEETS	1	SHEET	1

FOR REVIEW
 NOT FOR CONSTRUCTION

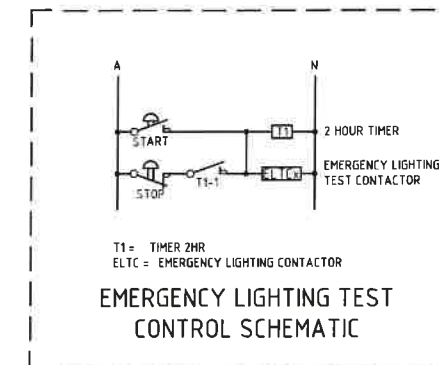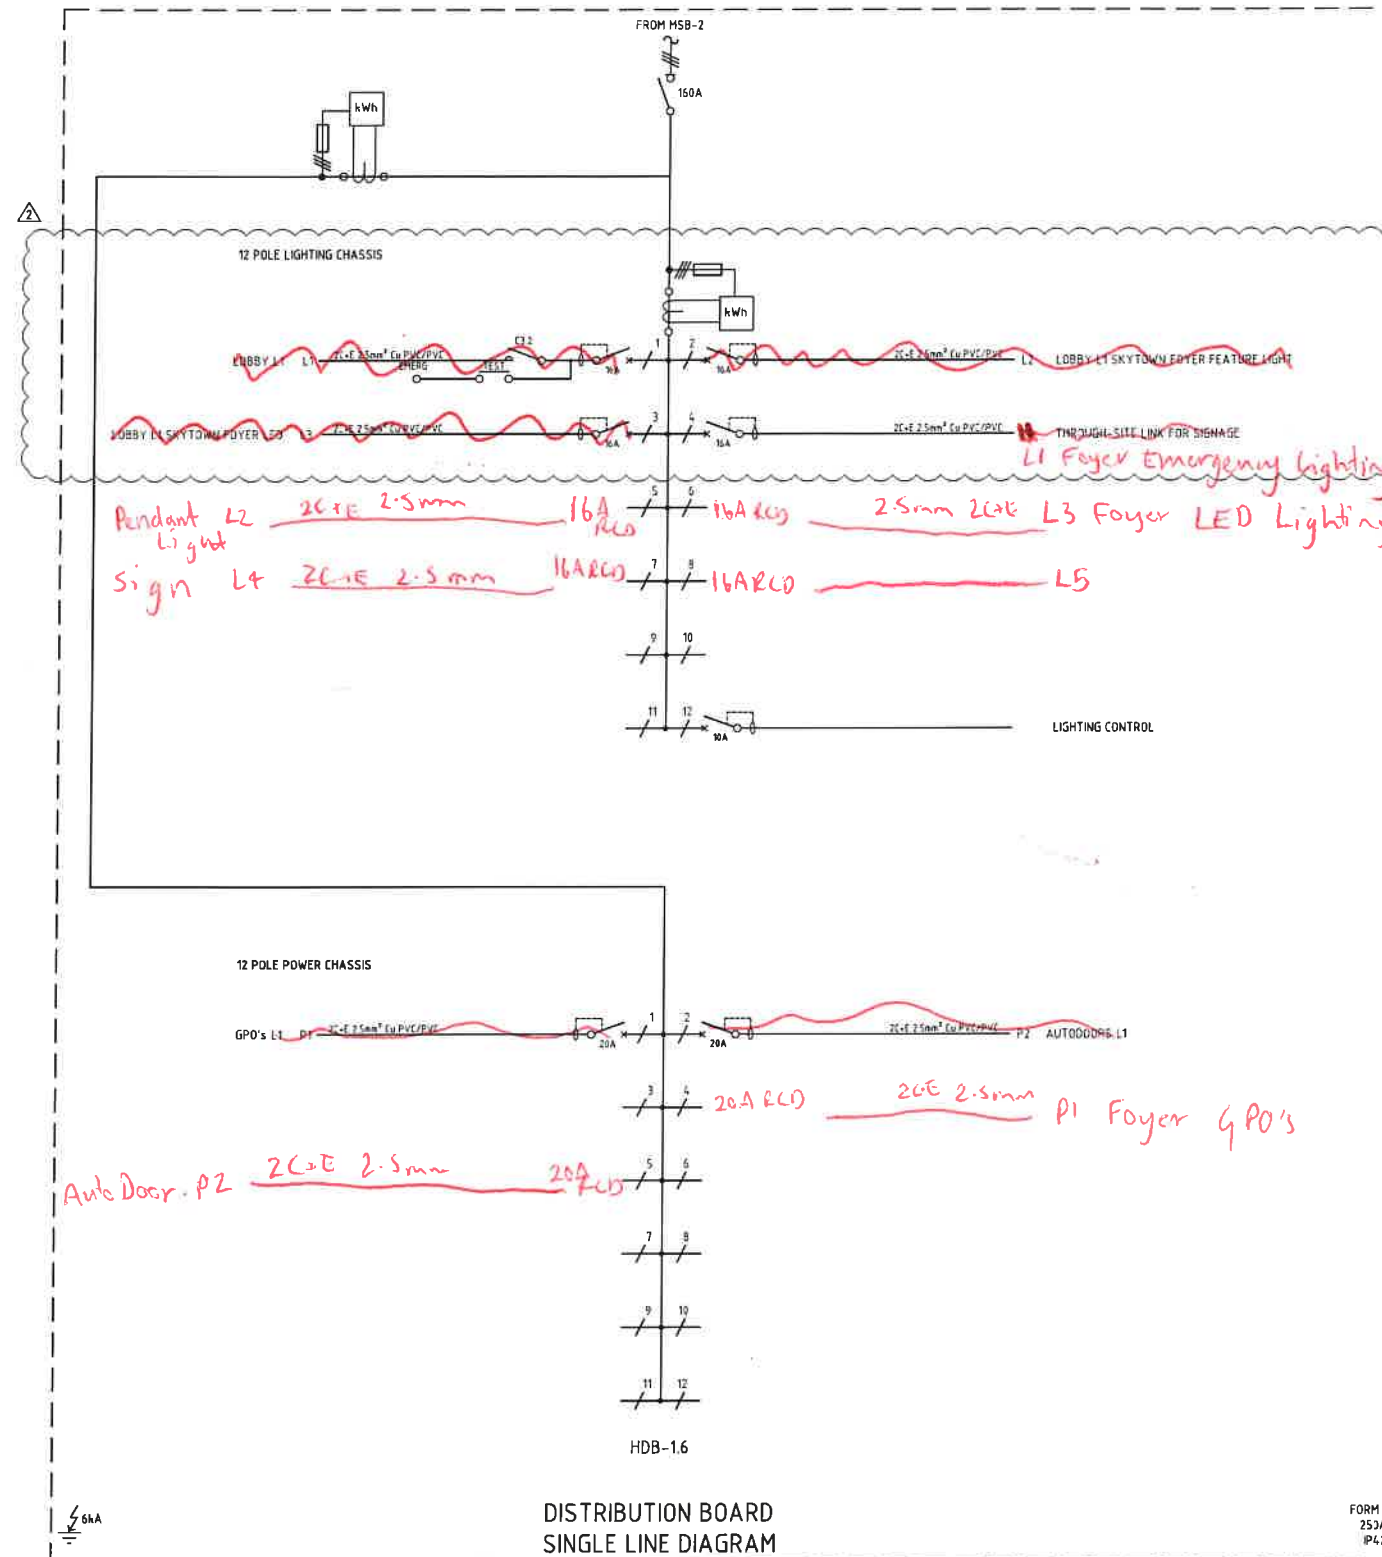

GENERAL NOTES:

1. PROVIDE FAULT CURRENT LIMITING IN ALL SWITCHBOARDS AS REQUIRED.
2. REFER DRAWING 2091-E-1920 FOR CONTROL WIRING.

REV	DATE	BY	CHKD	DESCRIPTION
00	20.09.16	TG	IL	ISSUED FOR REVIEW
01	23.03.17	TG	IL	SIGN MCB ADDED
02	24.03.17	MB	TP	FOYER LIGHTING ADDED

ELECTRICAL ENGINEER
PERIGON
 PERIGON PTY LTD
 U1 / 125 Freight Street
 Lynton QLD 4178
 P: (07) 3161 8055
 F: (07) 3161 8275
 E: admin@perigon.com.au
 W: www.perigon.com.au

CLIENT
Billbergia
 creating communities

ARCHITECT
 nettletontribe partnership pty ltd ABN 58 161 683 122
 Level 5, 344 Queen Street Brisbane QLD 4000
 T: 07 3239 2444 F: 07 3239 2455
 e: brisbane@nettletontribe.com.au w: nettletontribe.com.au





BUILDER
HUTCHINSON BUILDERS

PROJECT
BRISBANE SKYTOWER
 222 MARGARET STREET

DRAWN
 ELECTRICAL SERVICES
 HDB-1.6
 SINGLE LINE DIAGRAM

SCALE	N.T.S.	DATE	20.09.16
DRAWN	TG	CHECKED	IL
PROJECT NO.	PMA2091	DRAWING NO.	E-1923
NO. SHEETS	1	SHEET	02

FOR REVIEW
 NOT FOR CONSTRUCTION

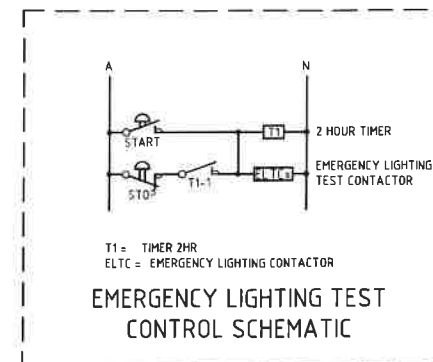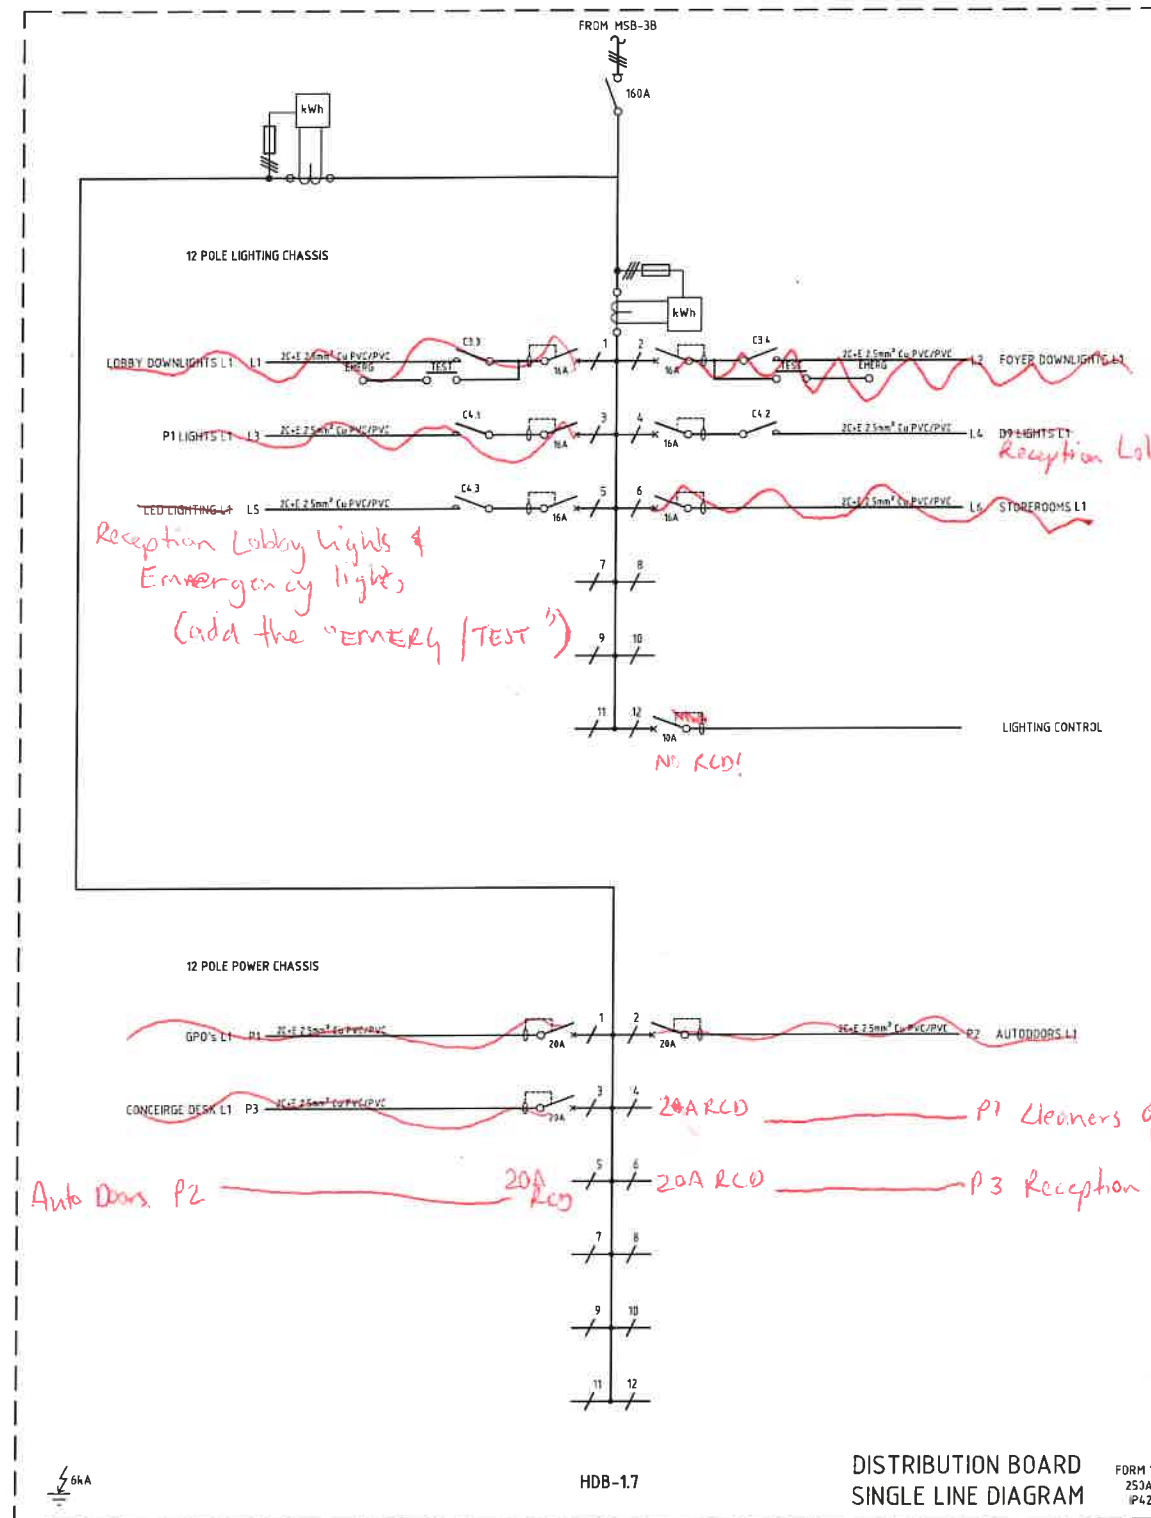

GENERAL NOTES:

1. PROVIDE FAULT CURRENT LIMITING IN ALL SWITCHBOARDS AS REQUIRED.
2. REFER DRAWING 2091-E-1920 FOR CONTROL WIRING.

REV	DATE	CHANGED	DESCRIPTION
00	20.09.16	TG	ISSUED FOR REVIEW

ELECTRICAL ENGINEER

PERIGON

PERIGON PTY LTD
1/1150 Freight Street
Lynch QLD 4175
P: (07) 3161 0295
F: (07) 3161 8225
E: admin@perigon.com.au
W: www.perigon.com.au

CLIENT

Billbergia
creating communities

ARCHITECT

nettleton tribe partnership pty ltd ABN 58 161 683 122
level 5, 364 queen street brisbane qld 4000
t 07 3239 2444 f 07 3239 2455
e brisbane@nettletontribe.com.au w nettletontribe.com.au



BUILDER

HUTCHINSON BUILDERS

CONTRACTOR MUST CHECK ALL DIMENSIONS ON SITE BEFORE COMMENCING ANY WORK ON THIS DRAWING. THE PROPERTY OF PERIGON HAS BEEN USED TO DESIGN THIS DRAWING.

PROJECT
BRISBANE SKYTOWER
222 MARGARET STREET

DRAWING
ELECTRICAL SERVICES
HDB-1.7
SINGLE LINE DIAGRAM

SCALE: N.T.S. DATE: 20.09.16

DRAWN: TG CHECKED: IL

PROJECT NO: PMA2091 DRAWING NO: E-1924

NO. IN SET: 1 SET: -

FOR REVIEW
NOT FOR CONSTRUCTION