


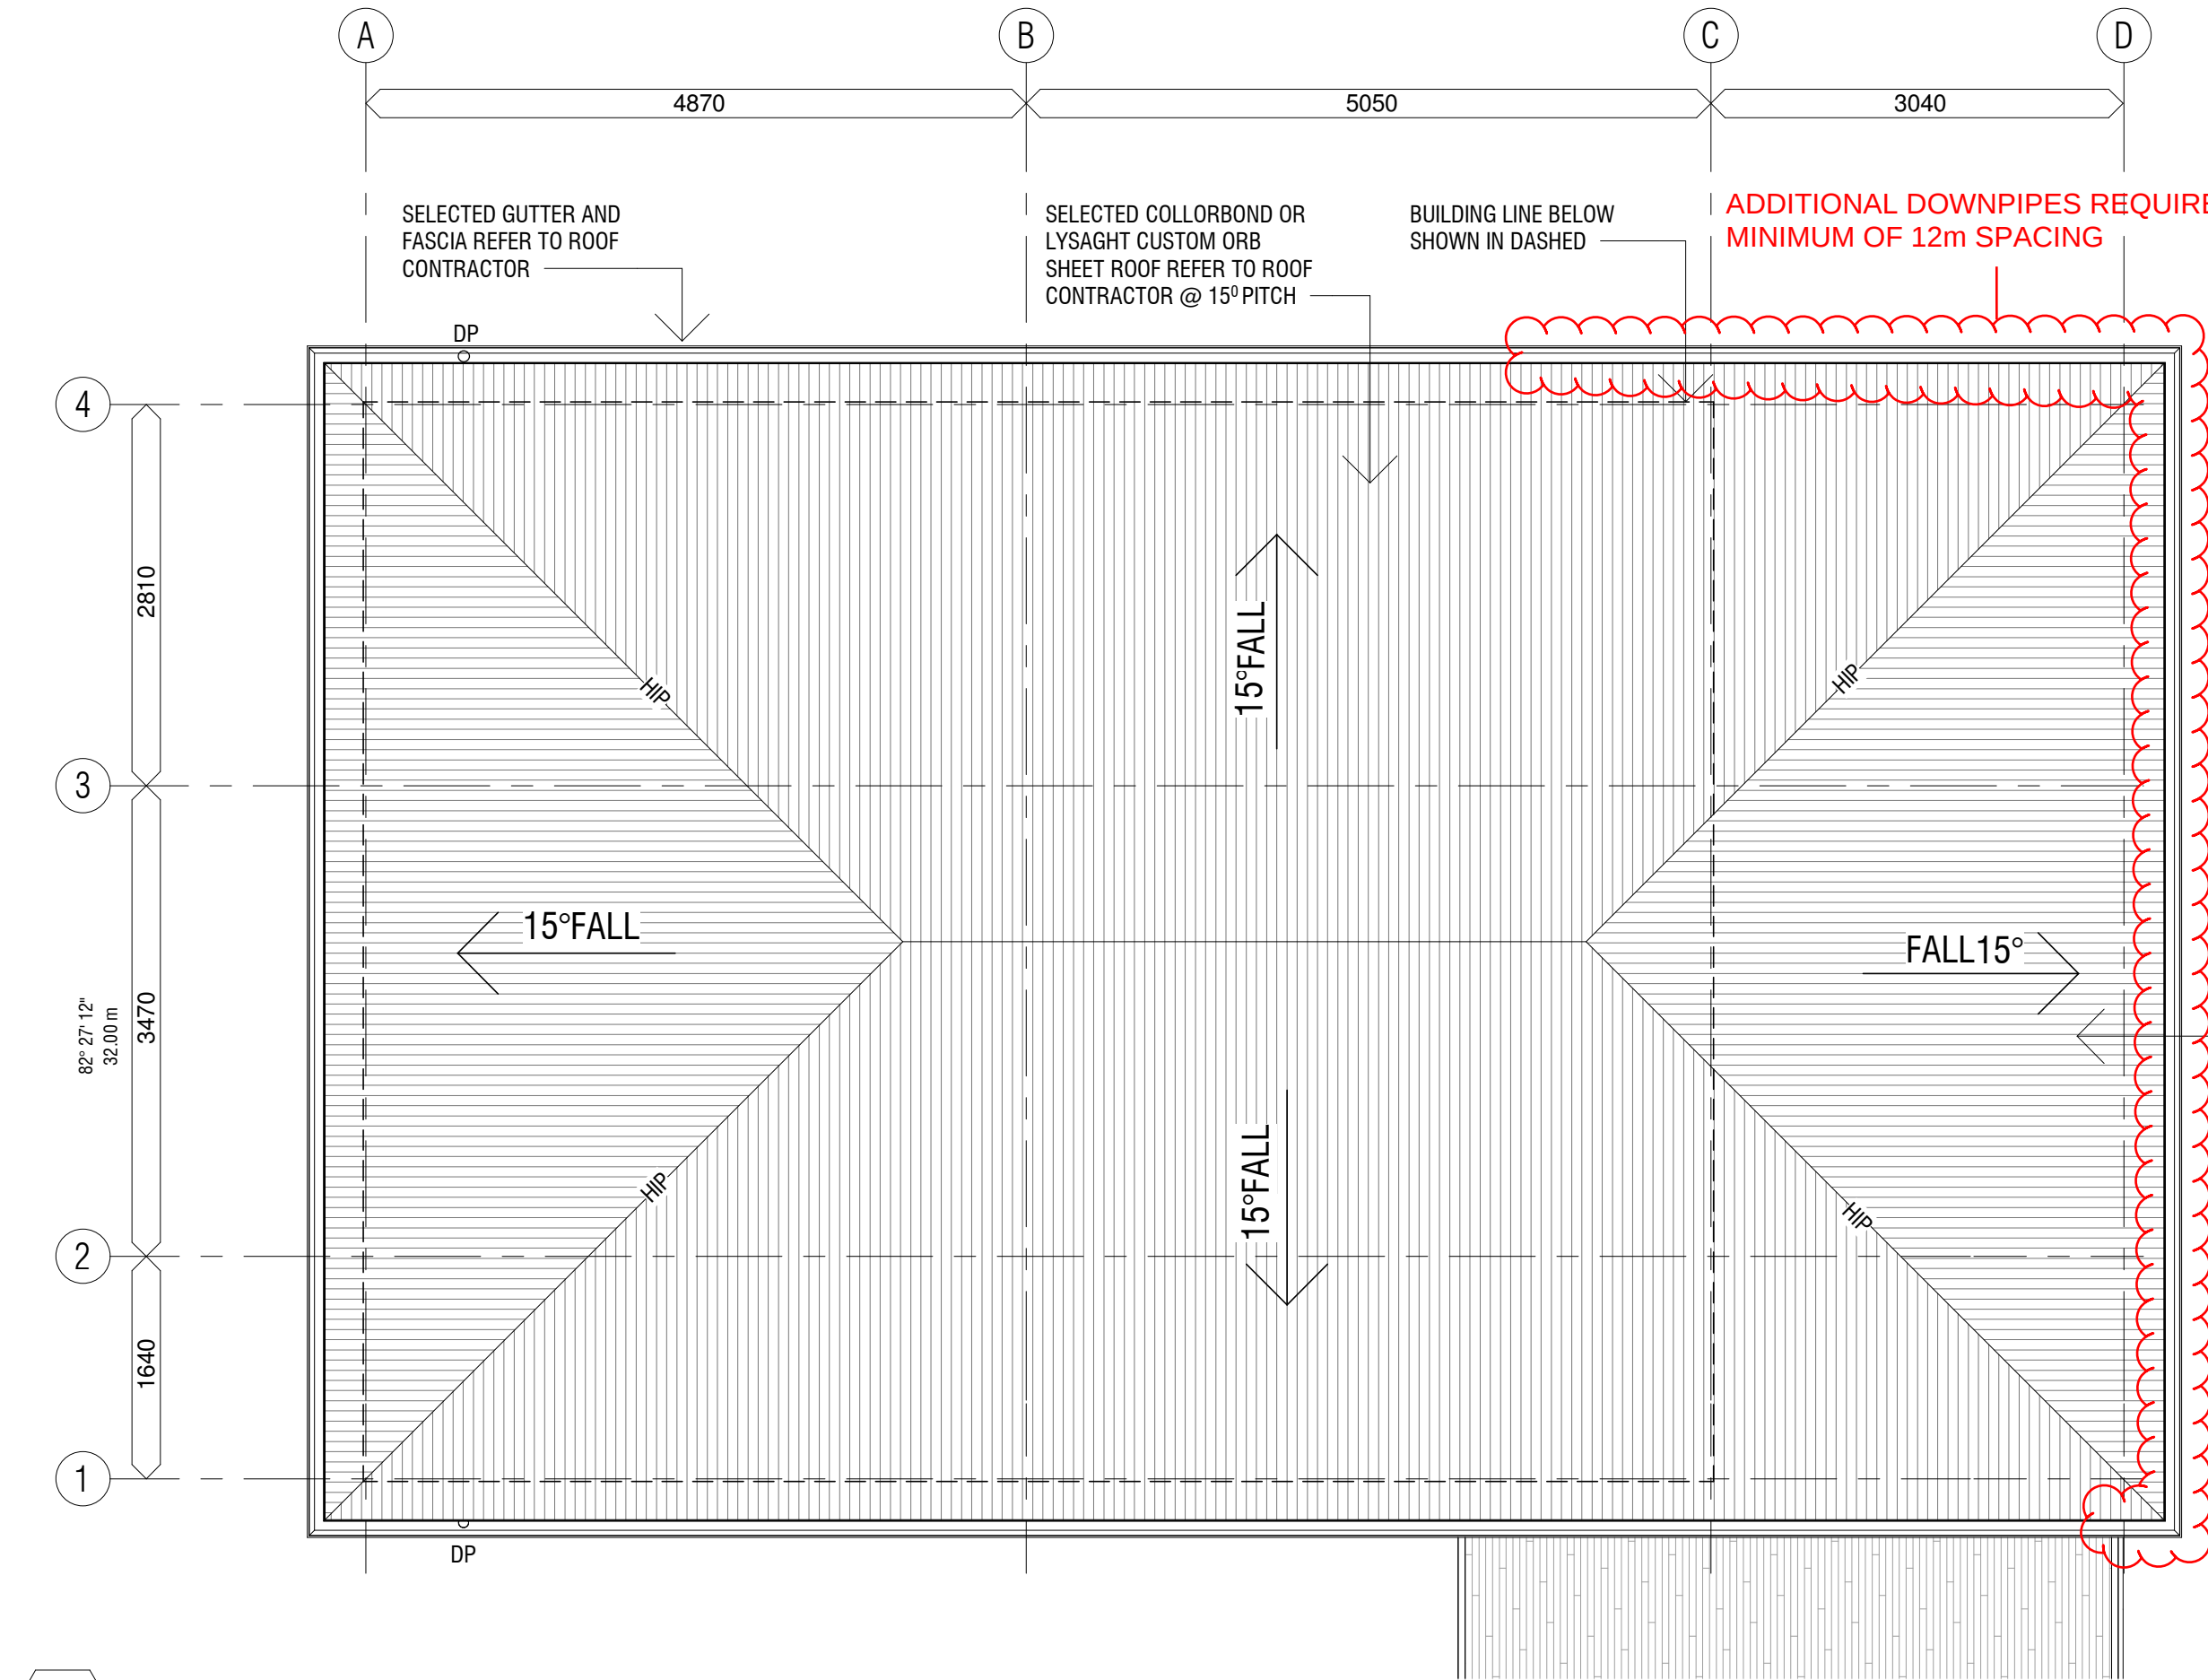

ROOF FINISHES	
SYMBLE	DISCIRPTION
	SELECTED COLLORBOND OR LYSAGHT CUSTOM ORB SHEET ROOF
NOTES:	
1. THIS DRAWING IS TO BE READ IN CONJUNCTION WITH ALL OTHER DRAWINGS RELEVANT TO THIS PROJECT.	
2. CONFIRM LOCATION OF ANY EXISTING SERVICES PRIOR TO COMMENCEMENT OF ANY WORK.	
3. ALL DISCONNECTION, RELOCATION, RECONNECTING, CUTTING & SEALING WORKS TO THE BUILDING SERVICES ARE TO BE CARRY OUT IN ACCORDANCE WITH THE REQUIREMENTS OF THE RELEVANT AUTHORITY.	
4. AMENDED DRAWINGS SHALL SUPERCEDE ALL PREVIOUS REVISIONS.	
5. ALL ITEMS USED IN THE WORK ARE TO BE USED FIXED , INSTALLED, APPLIED ETC. WITH THE MANUFACTURES SPECIFICATION.	
LEDGEND	
DP	DOWN PIPE


1 PROPOSAL ROOF
1 : 50

APPROVED FOR CONSTRUCTION
REFER TO BUILDING PERMIT FOR CONDITIONS
Permit Number: 2019099
29th August 2019


Andrew Bleakley QBCC Lic A1126608



HOUSE EXTENTION		PROPOSAL ROOF PLAN		purpose		dwn		dwg no		issue	
95 Woodland Road Gatton QLD, 4343				ISSUE FOR APPROVAL		JL		CD-002		A	
				scale 1 : 50 @A3				Do not scale this drawing. Verify all dimensions on site before commencing any work. Copyright © This drawing remains the property of bArki Studio Pty Ltd. Reproduction in whole or in part without prior consent is forbidden.			
Issue Date Description Checker				project no 719072		date AUG 2019		bArki Studio Pty Ltd ABN 15 370 825 058		p 0413761762 e jeremy.barki@gmail.com m PO Box 917 New Farm Q 4000	

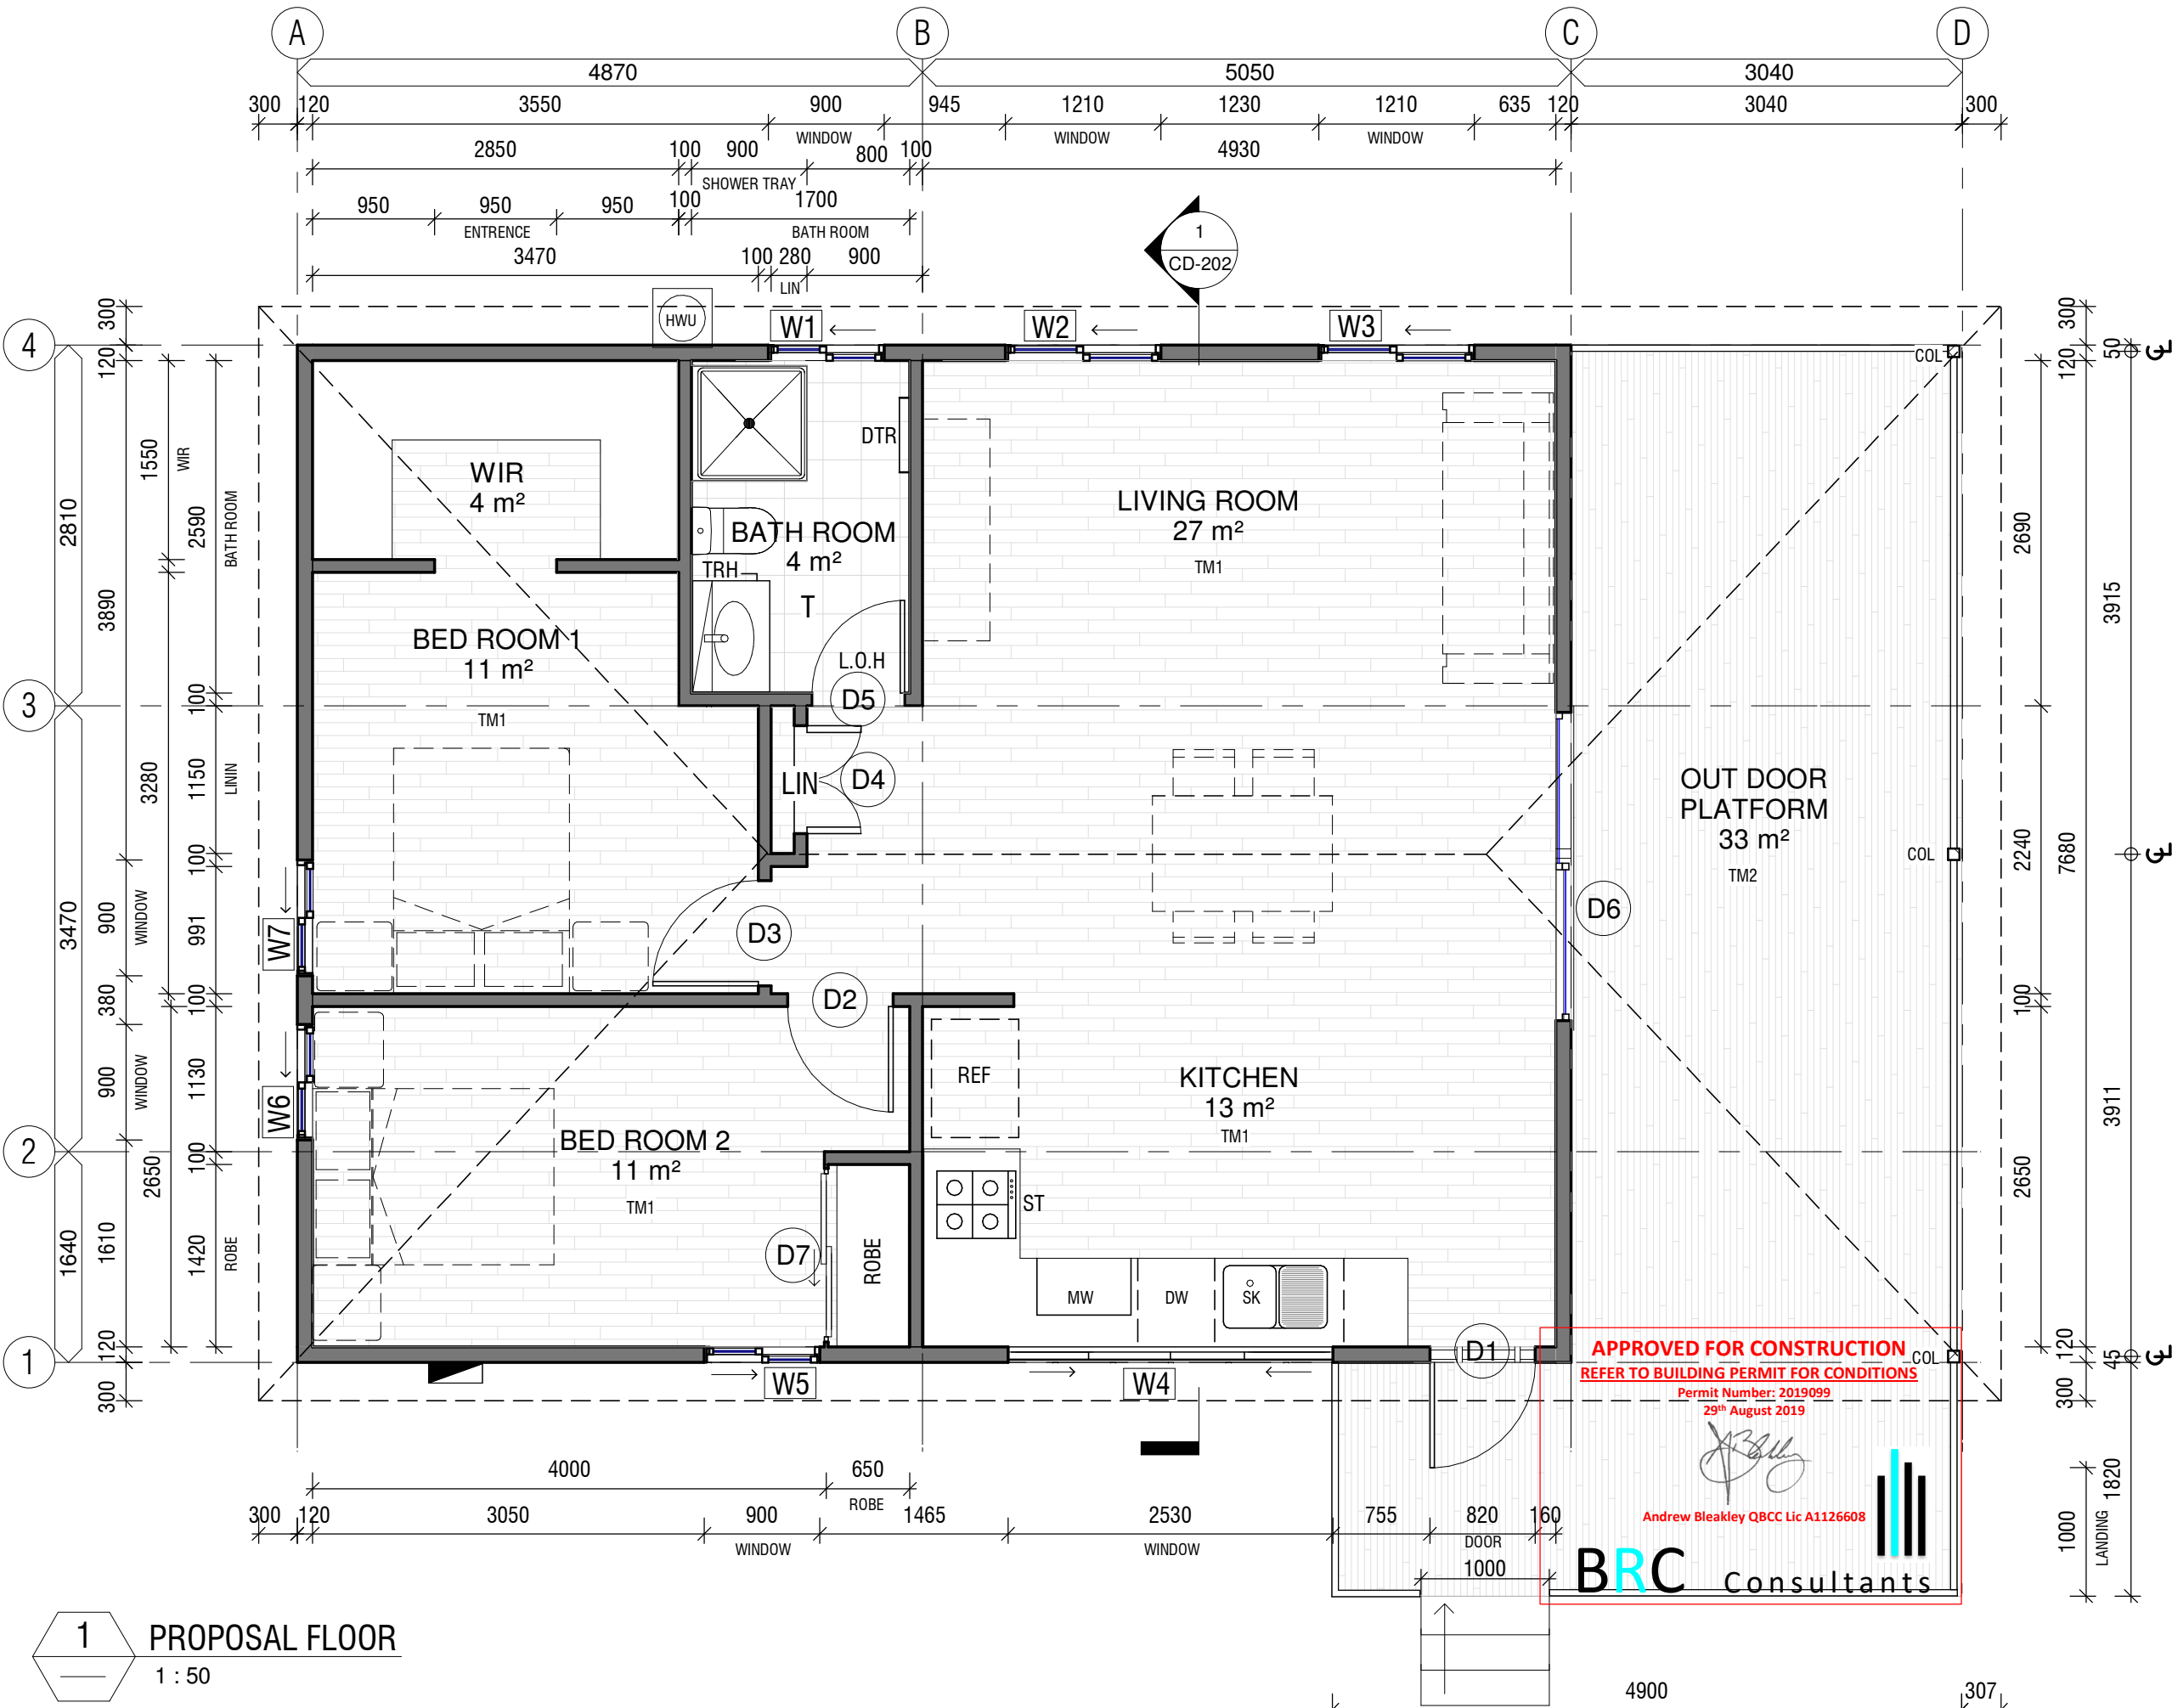

FLOOR FINISHES	
SYMBL	DISCRIPTION
TM1	INTERIOR TIMBER FLOOR (TBC BY CLIENT)
TM2	DECK TIMBER FLOOR (TBC BY CLIENT)
T	TILE FLOOR (TBC BY CLIENT)

NOTES:

1.

THIS DRAWING IS TO BE READ IN CONJUNCTION WITH ALL OTHER DRAWINGS RELEVANT TO THIS PROJECT.

2.

CONFIRM LOCATION OF ANY EXISTING SERVICES PRIOR TO COMMENCEMENT OF ANY WORK.

3.

ALL DISCONNECTION, RELOCATION, RECONNECTING, CUTTING & SEALING WORKS TO THE BUILDING SERVICES ARE TO BE CARRY OUT IN ACCORDANCE WITH THE REQUIREMENTS OF THE RELEVANT AUTHORITY.

4.

AMENDED DRAWINGS SHALL SUPERCEDE ALL PREVIOUS REVISIONS.

5.

ALL ITEMS USED IN THE WORK ARE TO BE USED FIXED , INSTALLED, APPLIED ETC. WITH THE MANUFACTURES SPECIFICATION.

LEDGEND	
DW	DISH WASHER
DTR	DOUBLE TOWEL HOLDER
LIN	LININ CABINET
L.O.H	LIFT OFF HINGES
SK	SINK
ST	STOVE TOP
TRH	TOILET ROLL HOLDER
REF	REFRIGERATOR
WIR	WALK IN ROBE
	MAIN SWITCH BOARD
HWU	HOT WATER UNIT
D1	2040 mm x 820 mm x 35 mm DOOR
D2	2040 mm x 820 mm x 35 mm DOOR
D3	2040 mm x 820 mm x 35 mm DOOR
D4	2040 mm x 840 mm DOUBLE DOOR
D5	2040 mm x 720 mm x 35 mm DOOR
D6	2410 mm x 2100 mm GLAZED SLIDING DOOR
D7	2100 mm x 1800 mm SLIDING ROBE DOOR
W1	600 mm x 1210 mm SLIDING GLAZED WINDOW
W2	2100 mm x 1210 mm SLIDING GLAZED WINDOW
W3	2100 mm x 1210 mm SLIDING GLAZED WINDOW
W4	1030 mm x 2530 mm SLIDING GLAZED WINDOW
W5	944 mm x 1210 mm SLIDING GLAZED WINDOW
W6	944 mm x 1210 mm SLIDING GLAZED WINDOW
W7	944 mm x 1210 mm SLIDING GLAZED WINDOW

1

PROPOSAL FLOOR

1 : 50

HOUSE EXTENTION

95 Woodland Road
Gatton
QLD, 4343

PROPOSAL FLOOR PLAN

purpose ISSUE FOR APPROVAL

scale 1 : 50 @A3

project no 719072

date AUG 2019

dwn JL

dwg no

CD-100

issue

A

Do not scale this drawing. Verify all dimensions on site before commencing any work. Copyright © This drawing remains the property of bArki Studio Pty Ltd. Reproduction in whole or in part without prior consent is forbidden.



bArki Studio Pty Ltd
ABN 15 370 825 058

p 0413761762
e jeremy.barki@gmail.com
m PO Box 917 New Farm Q 4000

Issue	Date	Description	Checker
A	02/08/19	ISSUE FOR BUILDING APPROVAL	JL



NOTE:

1. THIS DRAWING IS TO BE READ IN CONJUNCTION WITH ALL OTHER DRAWINGS RELEVANT TO THIS PROJECT.
2. CONFIRM LOCATION OF ANY EXISTING SERVICES PRIOR TO COMMENCEMENT OF ANY WORK.
3. ALL DISCONNECTION, RELOCATION, RECONNECTING, CUTTING & SEALING WORKS TO THE BUILDING SERVICES ARE TO BE CARRY OUT IN ACCORDANCE WITH THE REQUIREMENTS OF THE RELEVANT AUTHORITY.
4. AMENDED DRAWINGS SHALL SUPERCEDE ALL PREVIOUS REVISIONS.
5. ALL ITEMS USED IN THE WORK ARE TO BE USED FIXED , INSTALLED, APPLIED ETC. WITH THE MANUFACTURES SPECIFICATION.

BRC Consultants

HOUSE EXTENTION

95 Woodland Road
Gatton
QLD, 4343

PROPOSAL FOOTING LOCATION PLAN

purpose

ISSUE FOR APPROVAL

scale

1 : 50 @A3

project no

719072

date

AUG 2019

dwn

JL

dwg no

CD-101

issue

A

Do not scale this drawing. Verify all dimensions on site before commencing any work. Copyright © This drawing remains the property of bArki Studio Pty Ltd. Reproduction in whole or in part without prior consent is forbidden.





bArki Studio Pty Ltd

ABN 15 370 825 058


p 0413761762

e jeremy.barki@gmail.com

m PO Box 917 New Farm Q 4000

A	02/08/19	ISSUE FOR BUILDING APPROVAL	JL
Issue	Date	Description	Checker

FOFFIT SHEETING REFER TO CONTRACTOR

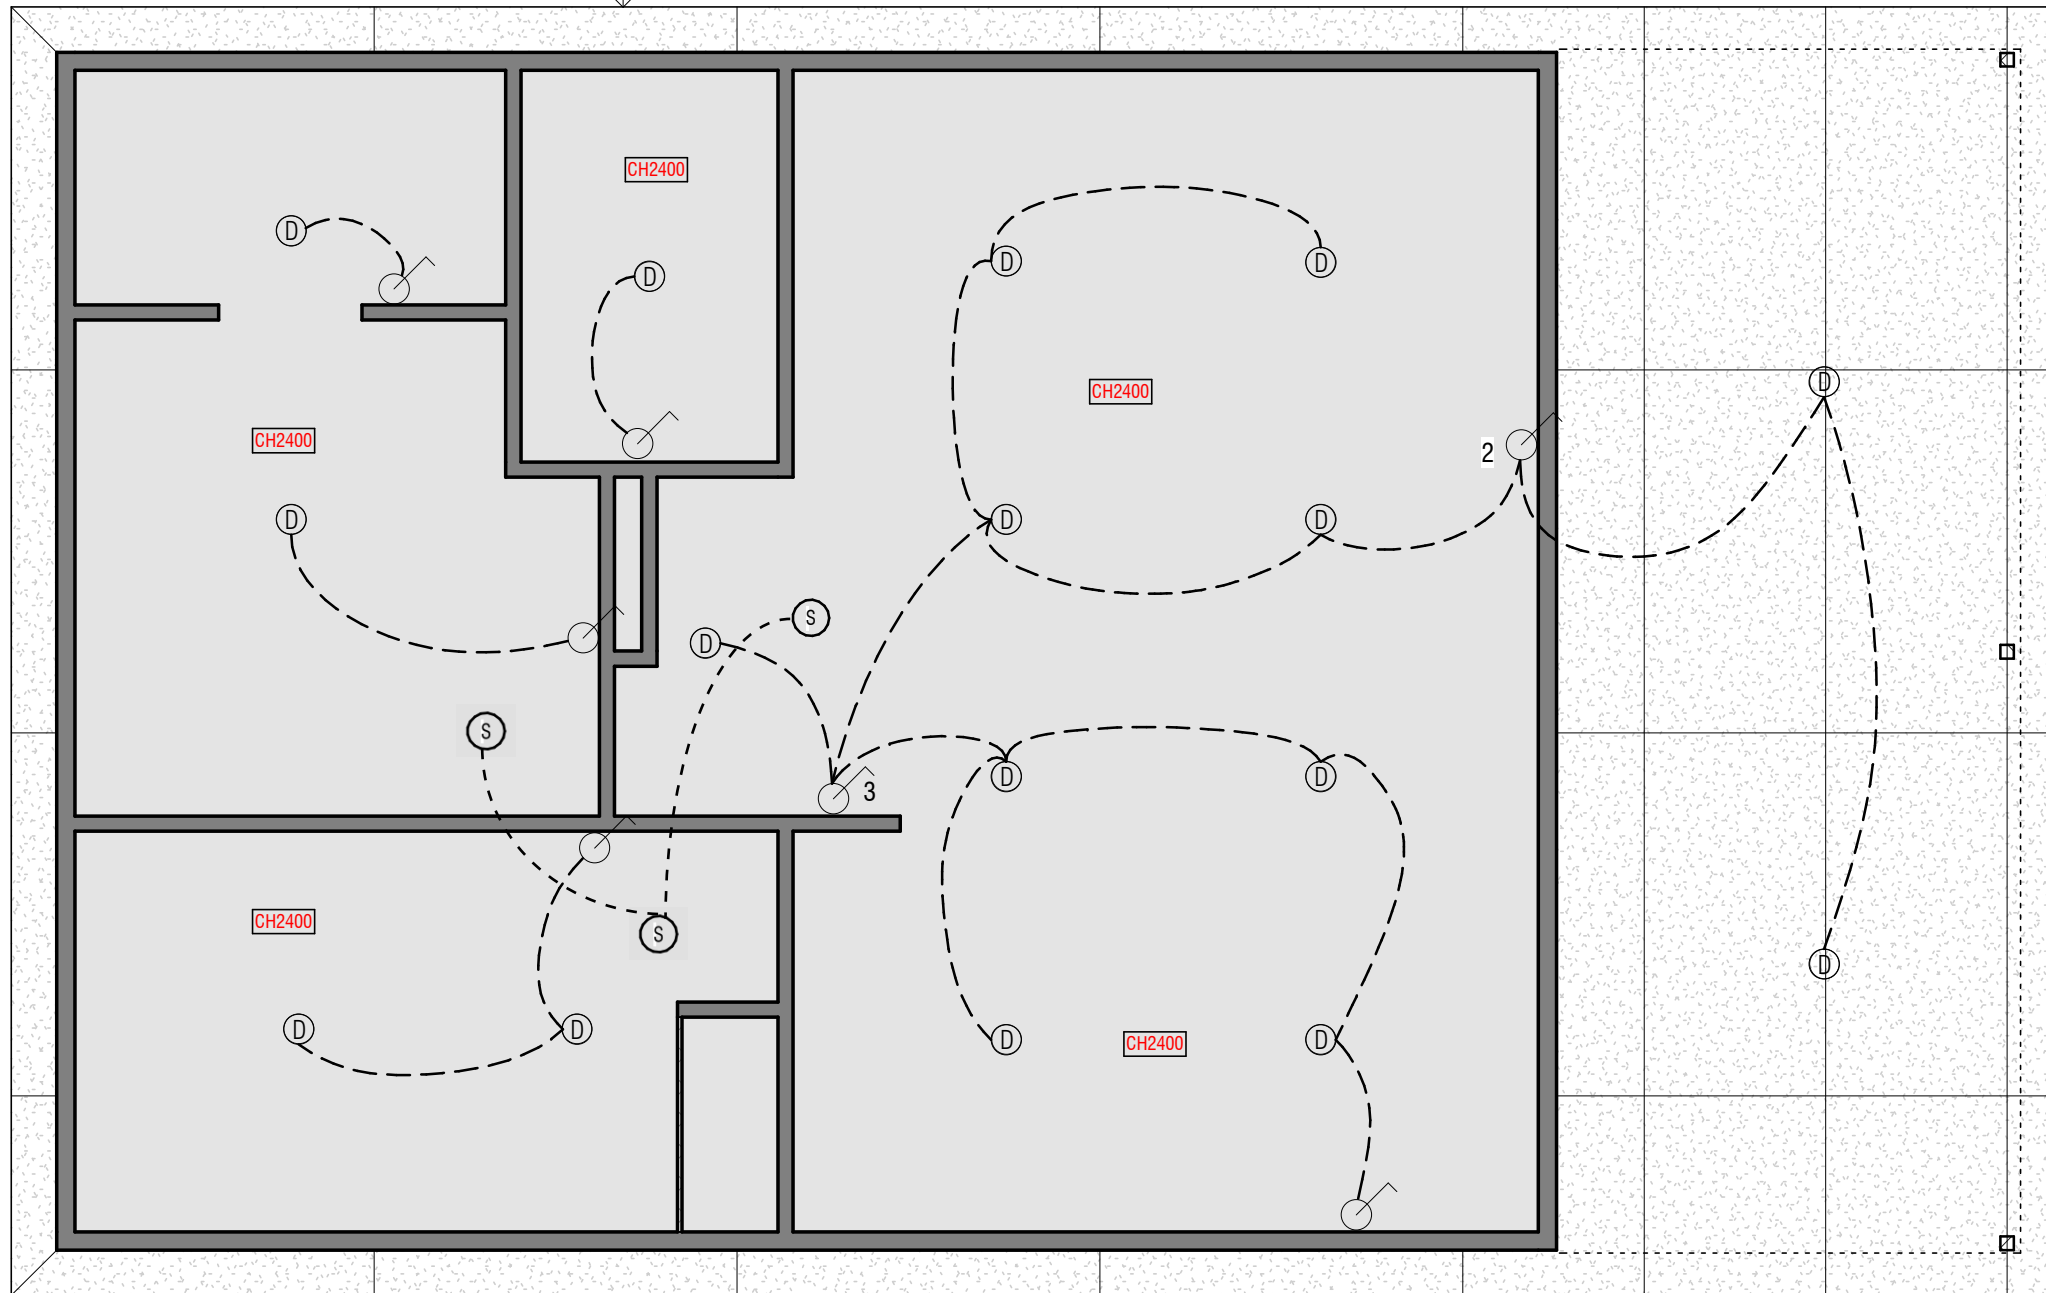

CEILING & LIGHTING LEGEND

SYMBOL	DESCRIPTION
CH2400	CEILING HEIGHT MEASURED ABOVE STRUCTURAL SLAB LEVEL
	NEW FLUSH PLASTERBOARD CEILING WITH PAINT FINISHES
	NEW SOFFIT SHEETING
	SINGLE GANG SWITCH
D	ADJUSTABLE DIMMABLE LED DOWNLIGHT TYPE D
S	SMOKE DETECTOR

NOTE:

ACOUSTIC TREATMENT TO ALL SERVICES TO COMPLY WITH THE RELEVANT AUSTRALIAN STANDARD AND BCA CODE
ITEM LOCATION INDICATIVE ONLY. CONTRACTOR TO CHECK ON SITE FOR POWER & DATA LOCATIONS PRIOR TO CONSTRUCTION.

1

PROPOSAL RCP & LIGHTING

1 : 50

APPROVED FOR CONSTRUCTION
REFER TO BUILDING PERMIT FOR CONDITIONS

Permit Number: 2019099
29th August 2019

Andrew Bleakley

Andrew Bleakley QBCC Lic A1126608

BRC Consultants

HOUSE EXTENTION

95 Woodland Road
Gatton
QLD, 4343

PROPOSAL RCP & LIGHTING PLAN

purpose ISSUE FOR APPROVAL

scale 1 : 50 @A3

project no 719072

date AUG 2019

dwn JL

dwg no

CD-110

issue

A


Do not scale this drawing. Verify all dimensions on site before commencing any work. Copyright © This drawing remains the property of bArki Studio Pty Ltd. Reproduction in whole or in part without prior consent is forbidden.



bArki Studio Pty Ltd
ABN 15 370 825 058

p 0413761762
e jeremy.barki@gmail.com
m PO Box 917 New Farm Q 4000

A	02/08/19	ISSUE FOR BUILDING APPROVAL	JL
Issue	Date	Description	Checker

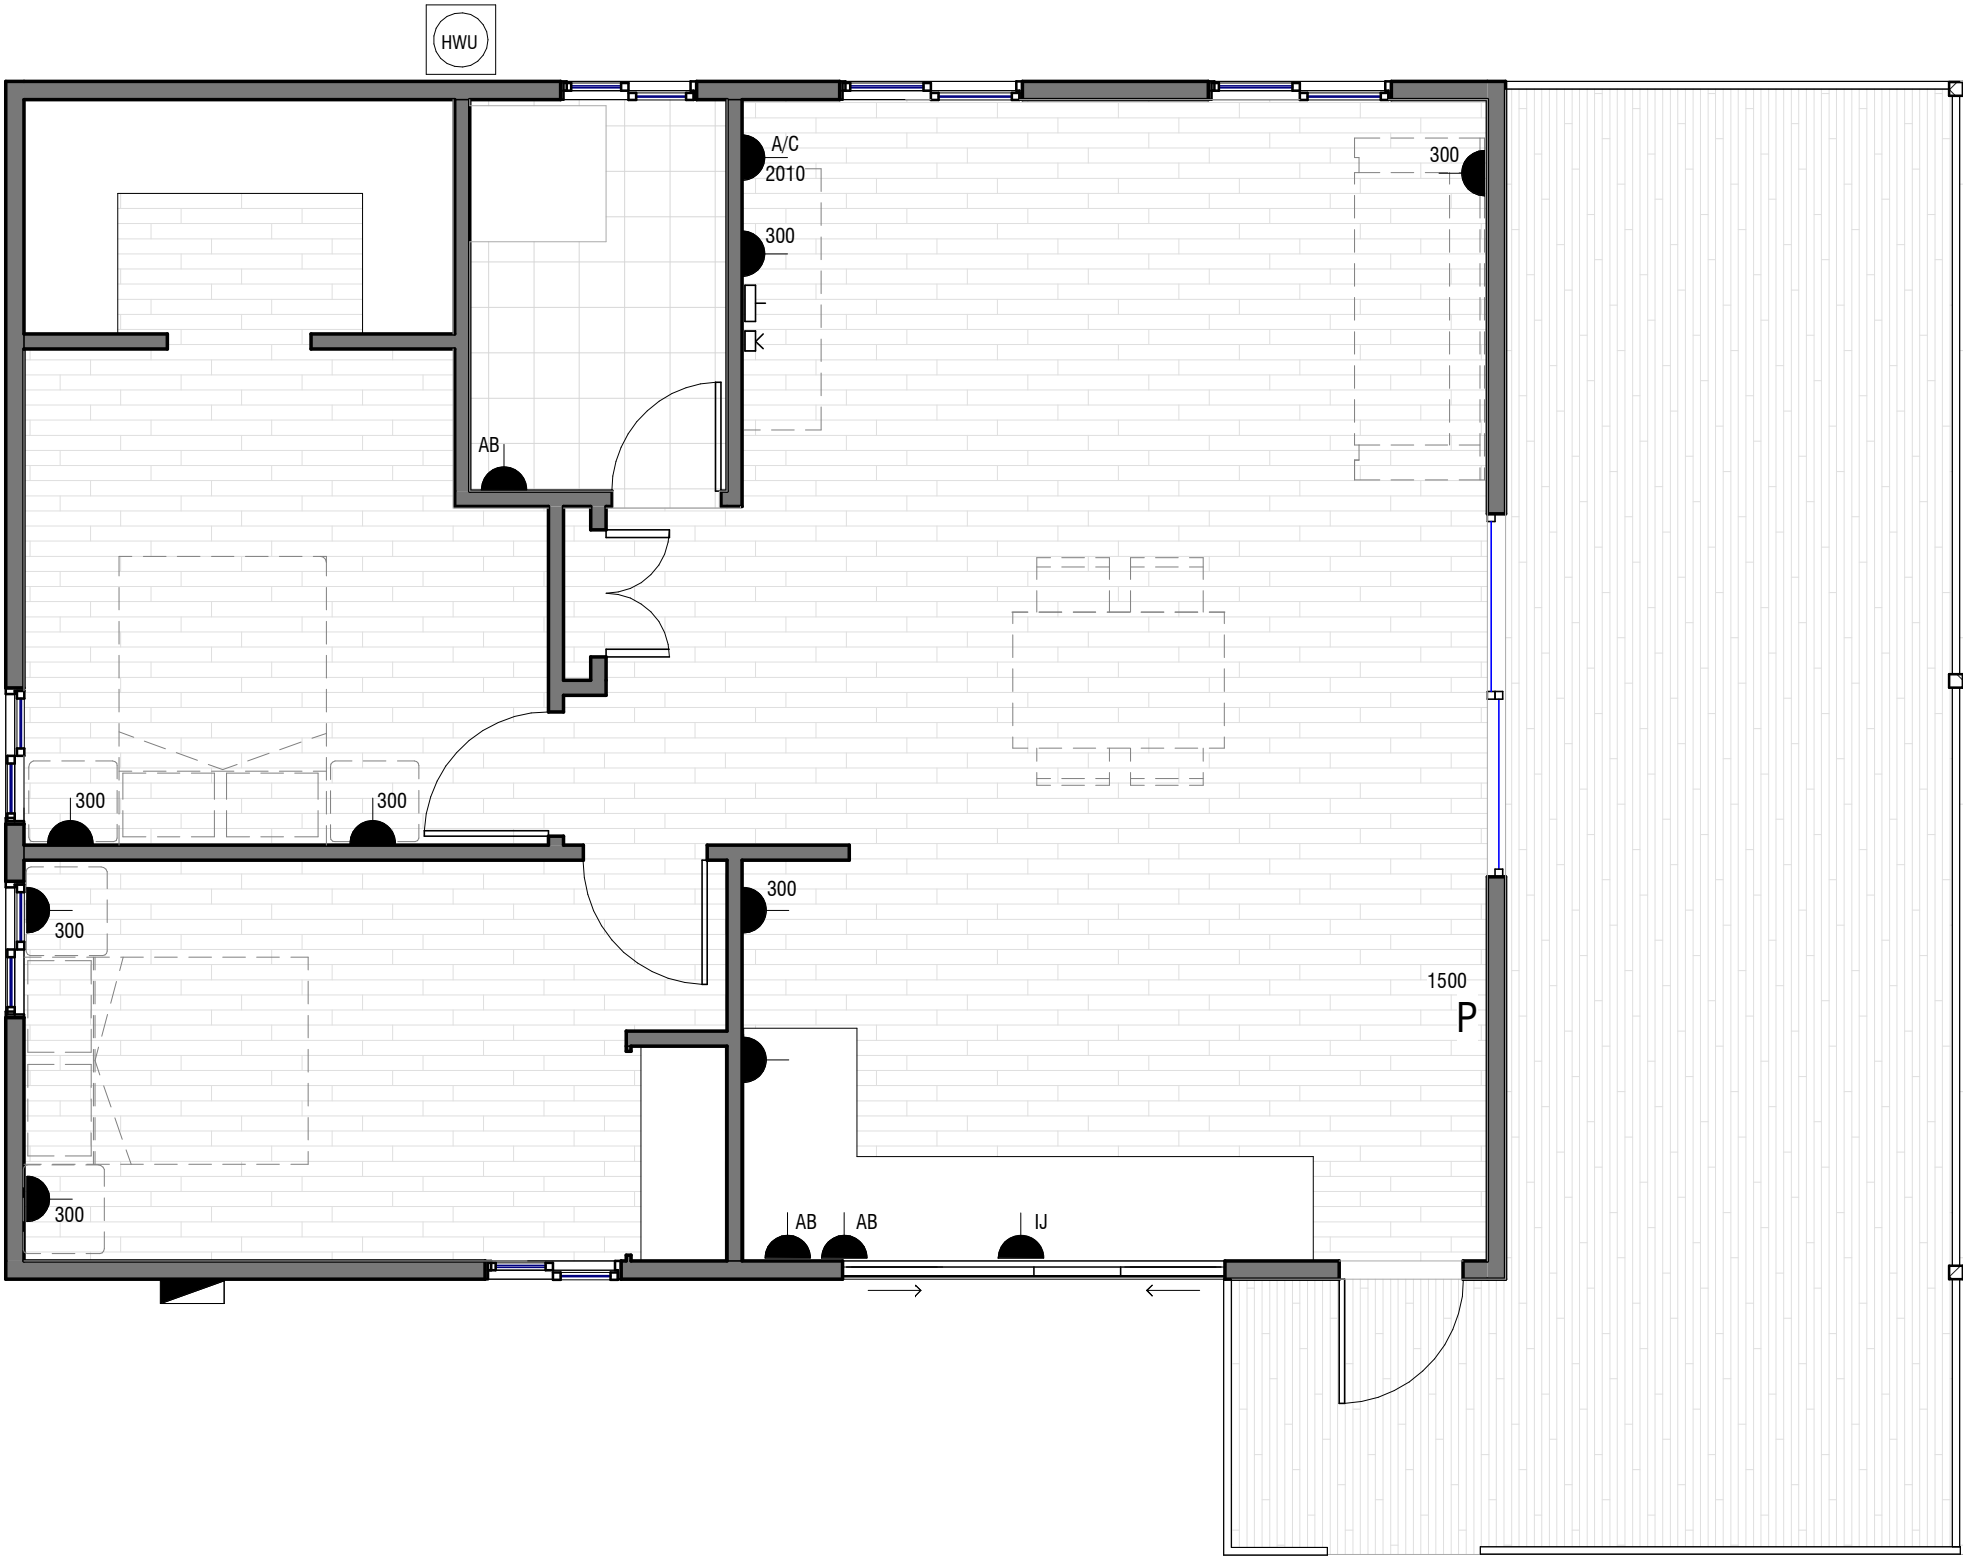

ELECTRICAL LEGEND	
SYMBOL	DESCIPTION
P	TELEPHONE POINT
AB	DOUBLE GPO
AB	DOUBLE GPO ABOVE BENCH
IJ	DOUBLE GPO IN SIDE JOINERY
K	DATA POINT
K	TV OUTLET POINT
	MAIN SWITCH BOARD
HWU	HOT WATER UNIT
NOTE: ACOUSTIC TREATMENT TO ALL SERVICES TO COMPLY IWTH THE RELEVANT AUSTRALIAN STANDARD AND BCA CODE ITAM LOCATION INDICATIVE ONLY. CONTRACTOR TO CHECK ON SITE FOR POWER & DATA LOCATIONS PRIOR TO CONSTRUCTION.	

1

PROPOSAL POWER & DATA

1 : 50

APPROVED FOR CONSTRUCTION


REFER TO BUILDING PERMIT FOR CONDITIONS

Permit Number: 2019099


29th August 2019

Andrew Bleakley QBCC Lic A1126608

HOUSE EXTENTION				PROPOSAL POWER & DATA PLAN				bArki studio			
95 Woodland Road Gatton QLD, 4343				Do not scale this drawing. Verify all dimensions on site before commencing any work. Copyright © This drawing remains the property of bArki Studio Pty Ltd. Reproduction in whole or in part without prior consent is forbidden.				bArki studio			
A				ISSUE FOR BUILDING APPROVAL				bArki Studio Pty Ltd ABN 15 370 825 058			
02/08/19				JL				p 0413761762			
ISSUE				DATE				e jeremy.barki@gmail.com			
Description				Checker				m PO Box 917 New Farm Q 4000			
JL				CD-111							
Issue				A							

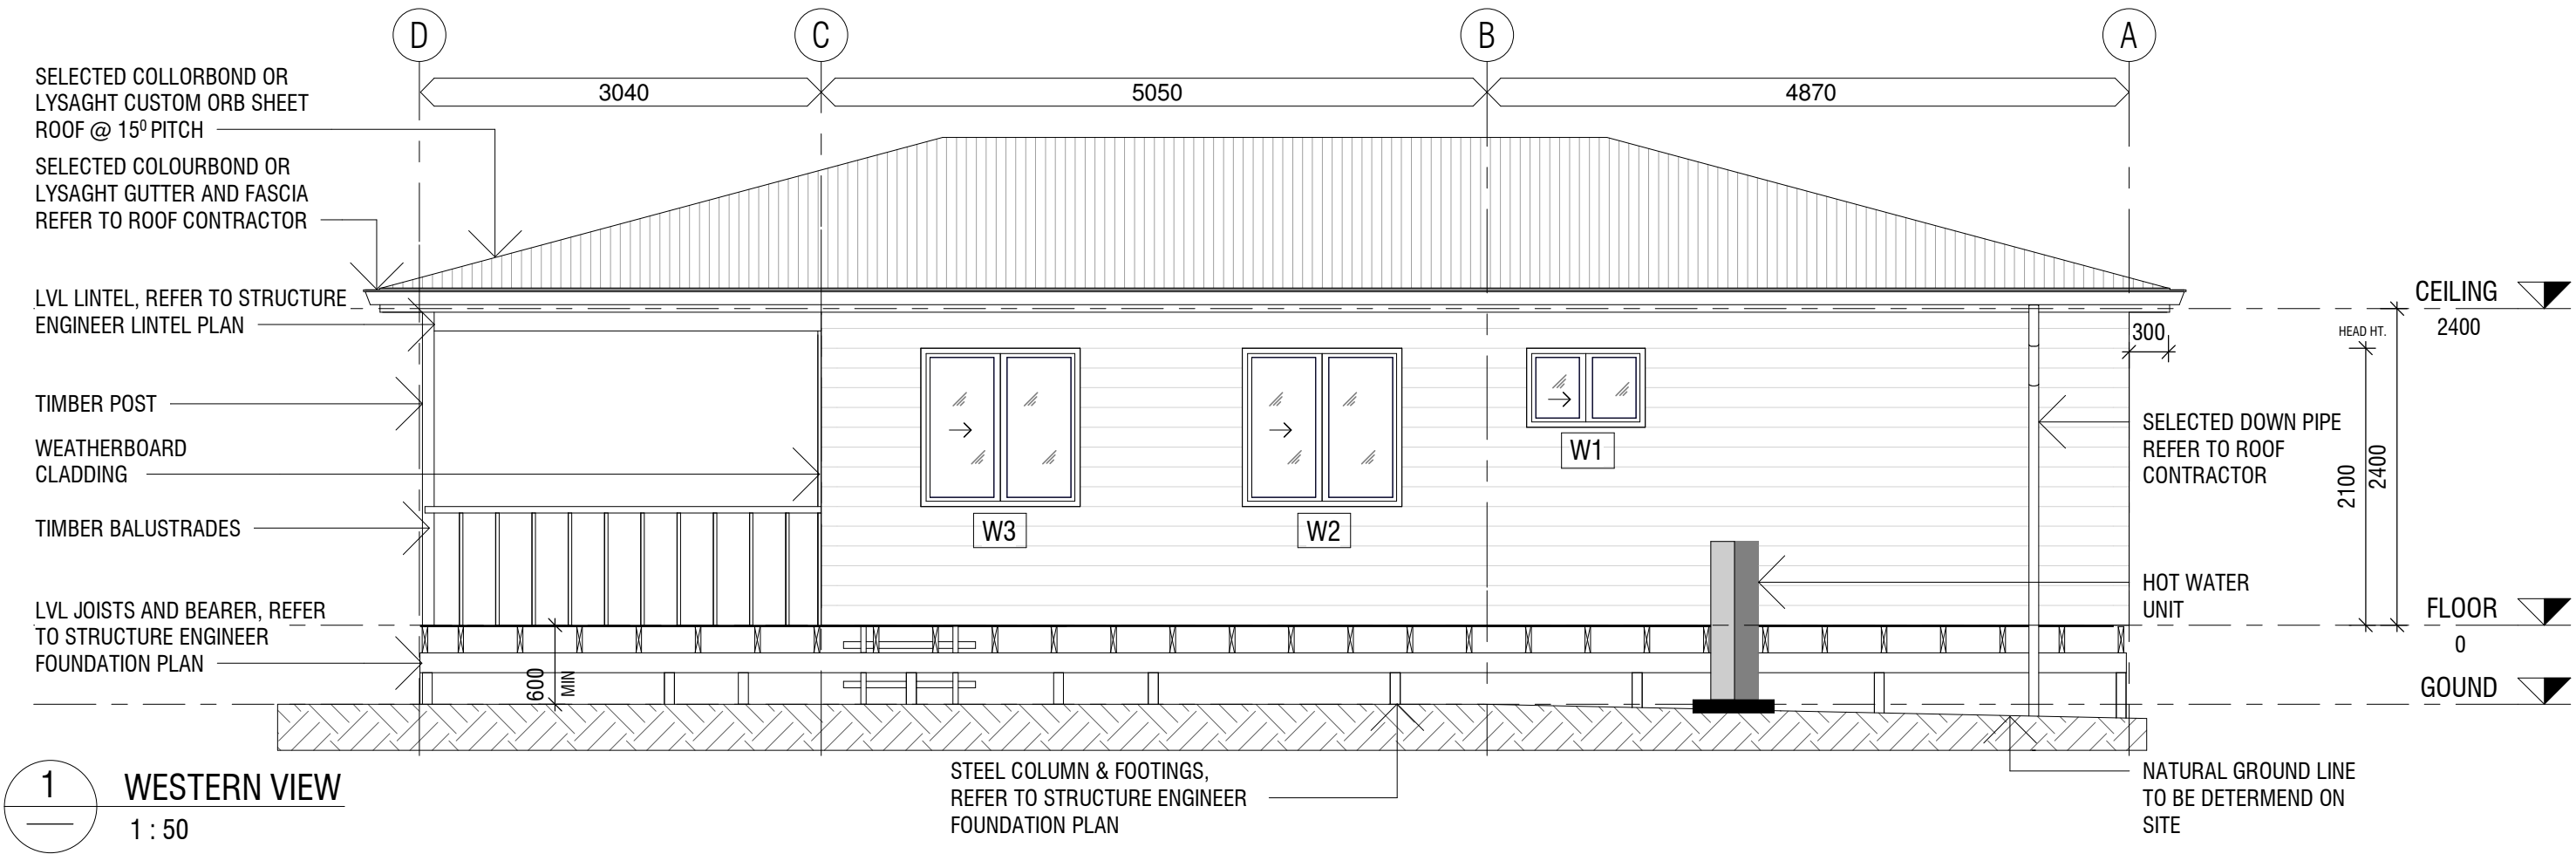

1 WESTERN VIEW
1 : 50

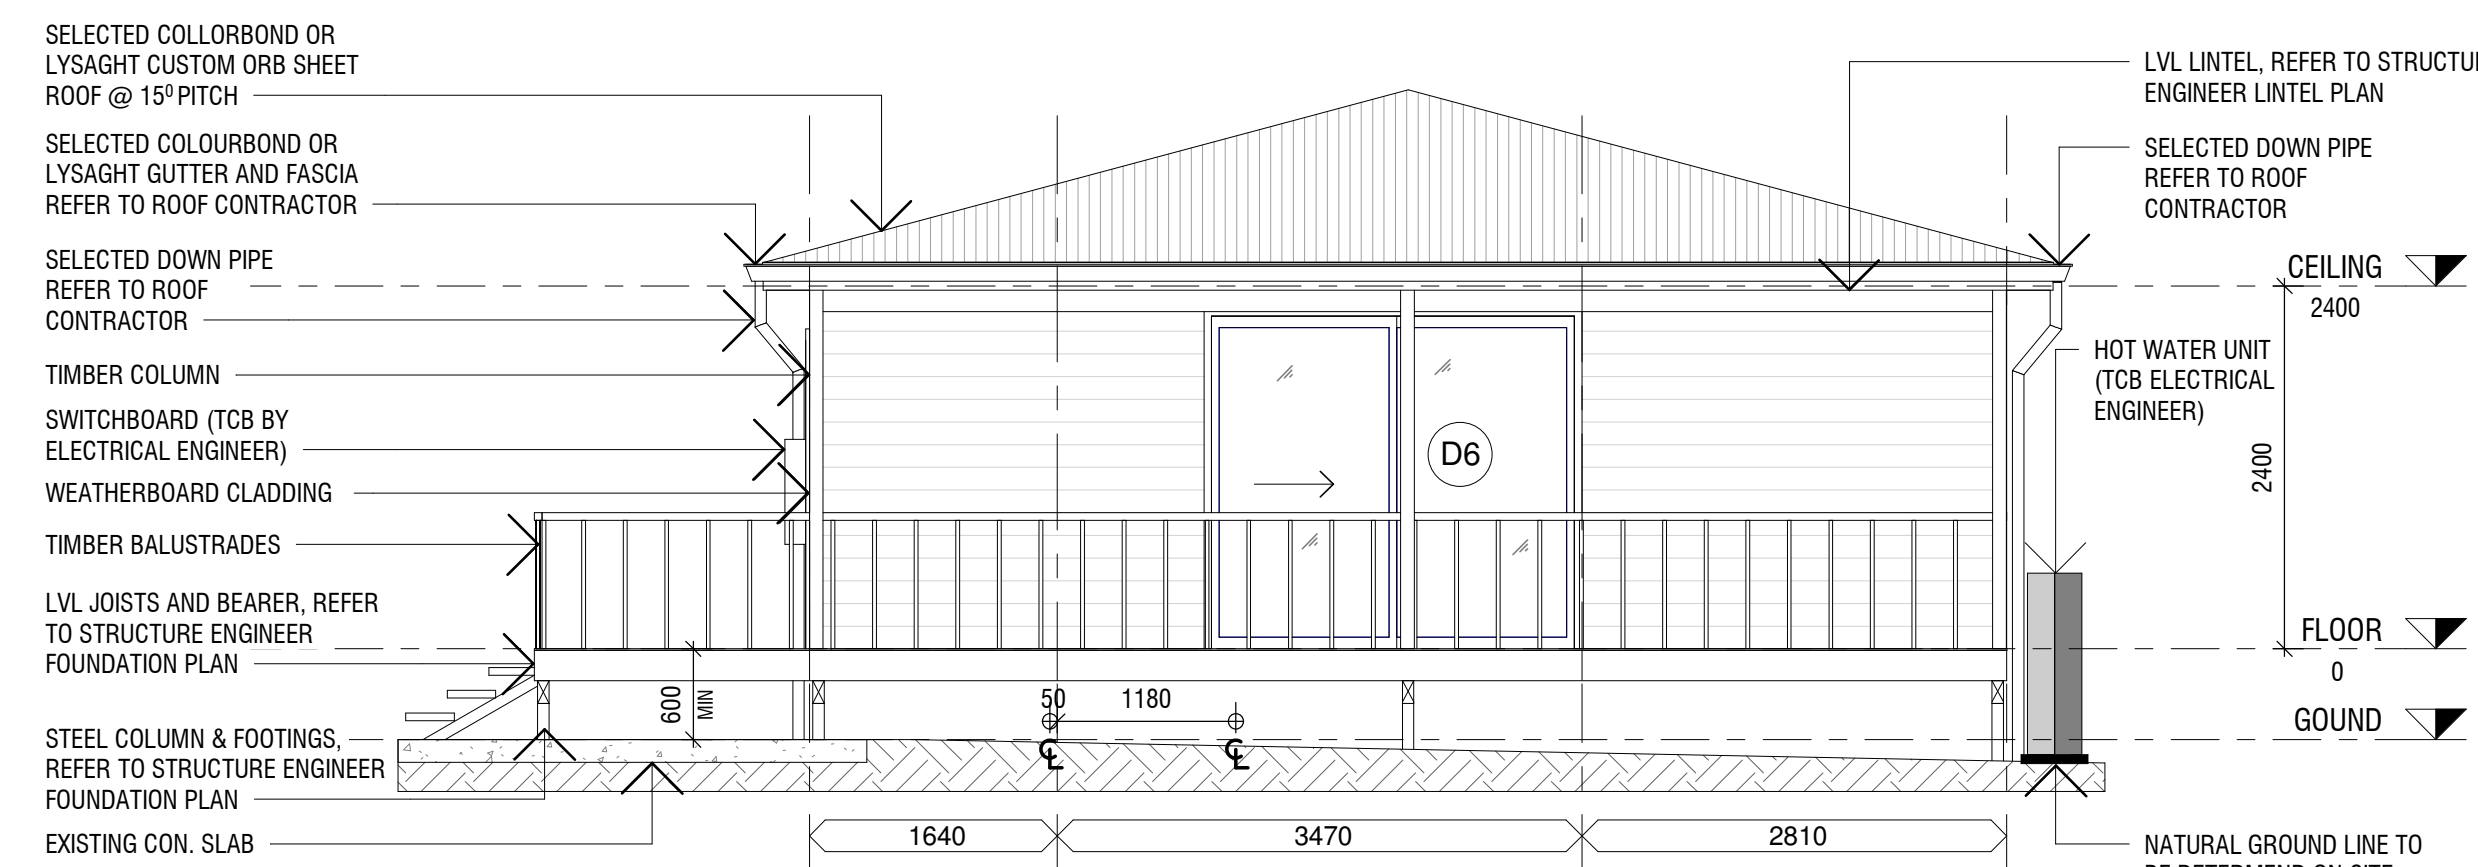

2 NORTHERN VIEW
1 : 50

LEDGEND

D6	2410 mm x 2100 mm GLAZED SLIDING DOOR
W1	600 mm x 1210 mm SLIDING GLAZED WINDOW
W2	2100 mm x 1210 mm SLIDING GLAZED WINDOW
W3	2100 mm x 1210 mm SLIDING GLAZED WINDOW



NOTE:


- THIS DRAWING IS TO BE READ IN CONJUNCTION WITH ALL OTHER DRAWINGS RELEVANT TO THIS PROJECT.
- CONFIRM LOCATION OF ANY EXISTING SERVICES PRIOR TO COMMENCEMENT OF ANY WORK.
- ALL DISCONNECTION, RELOCATION, RECONNECTING, CUTTING & SEALING WORKS TO THE BUILDING SERVICES ARE TO BE CARRY OUT IN ACCORDANCE WITH THE REQUIREMENTS OF THE RELEVANT AUTHORITY.
- AMENDED DRAWINGS SHALL SUPERCEDE ALL PREVIOUS REVISIONS.
- ALL ITEMS USED IN THE WORK ARE TO BE USED FIXED , INSTALLED, APPLIED ETC. WITH THE MANUFACTURES SPECIFICATION.

APPROVED FOR CONSTRUCTION
REFER TO BUILDING PERMIT FOR CONDITIONS
Permit Number: 2019099
29 August 2019
NOTE: ALL FINISHES & MATERIAL SELECTIONS TO BE CONFIRMED BY BUILDER

Andrew Bleakley QBCC Lic A1126608

BRC Consultants

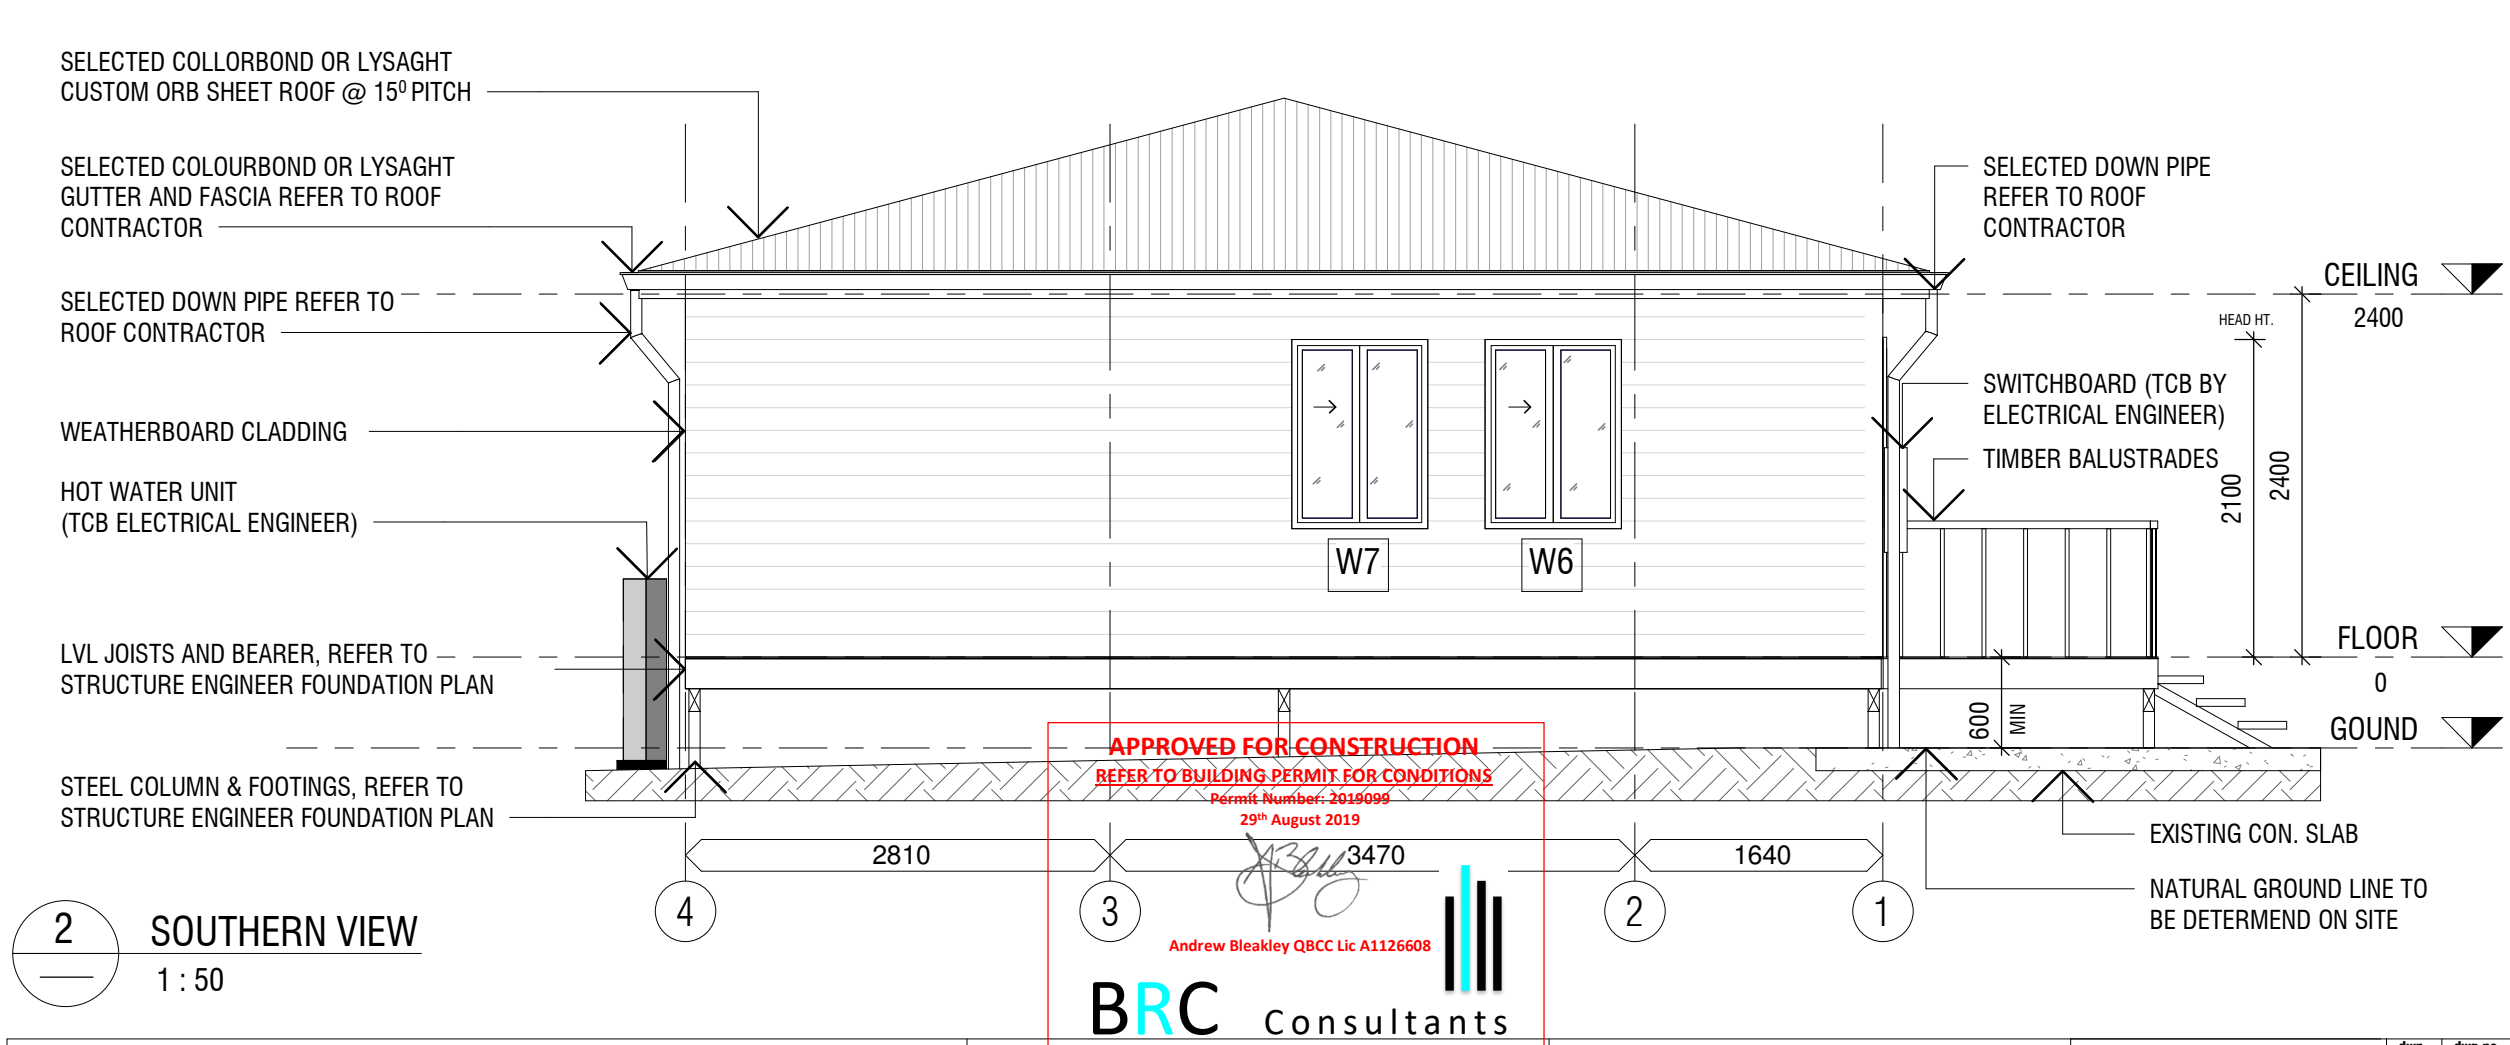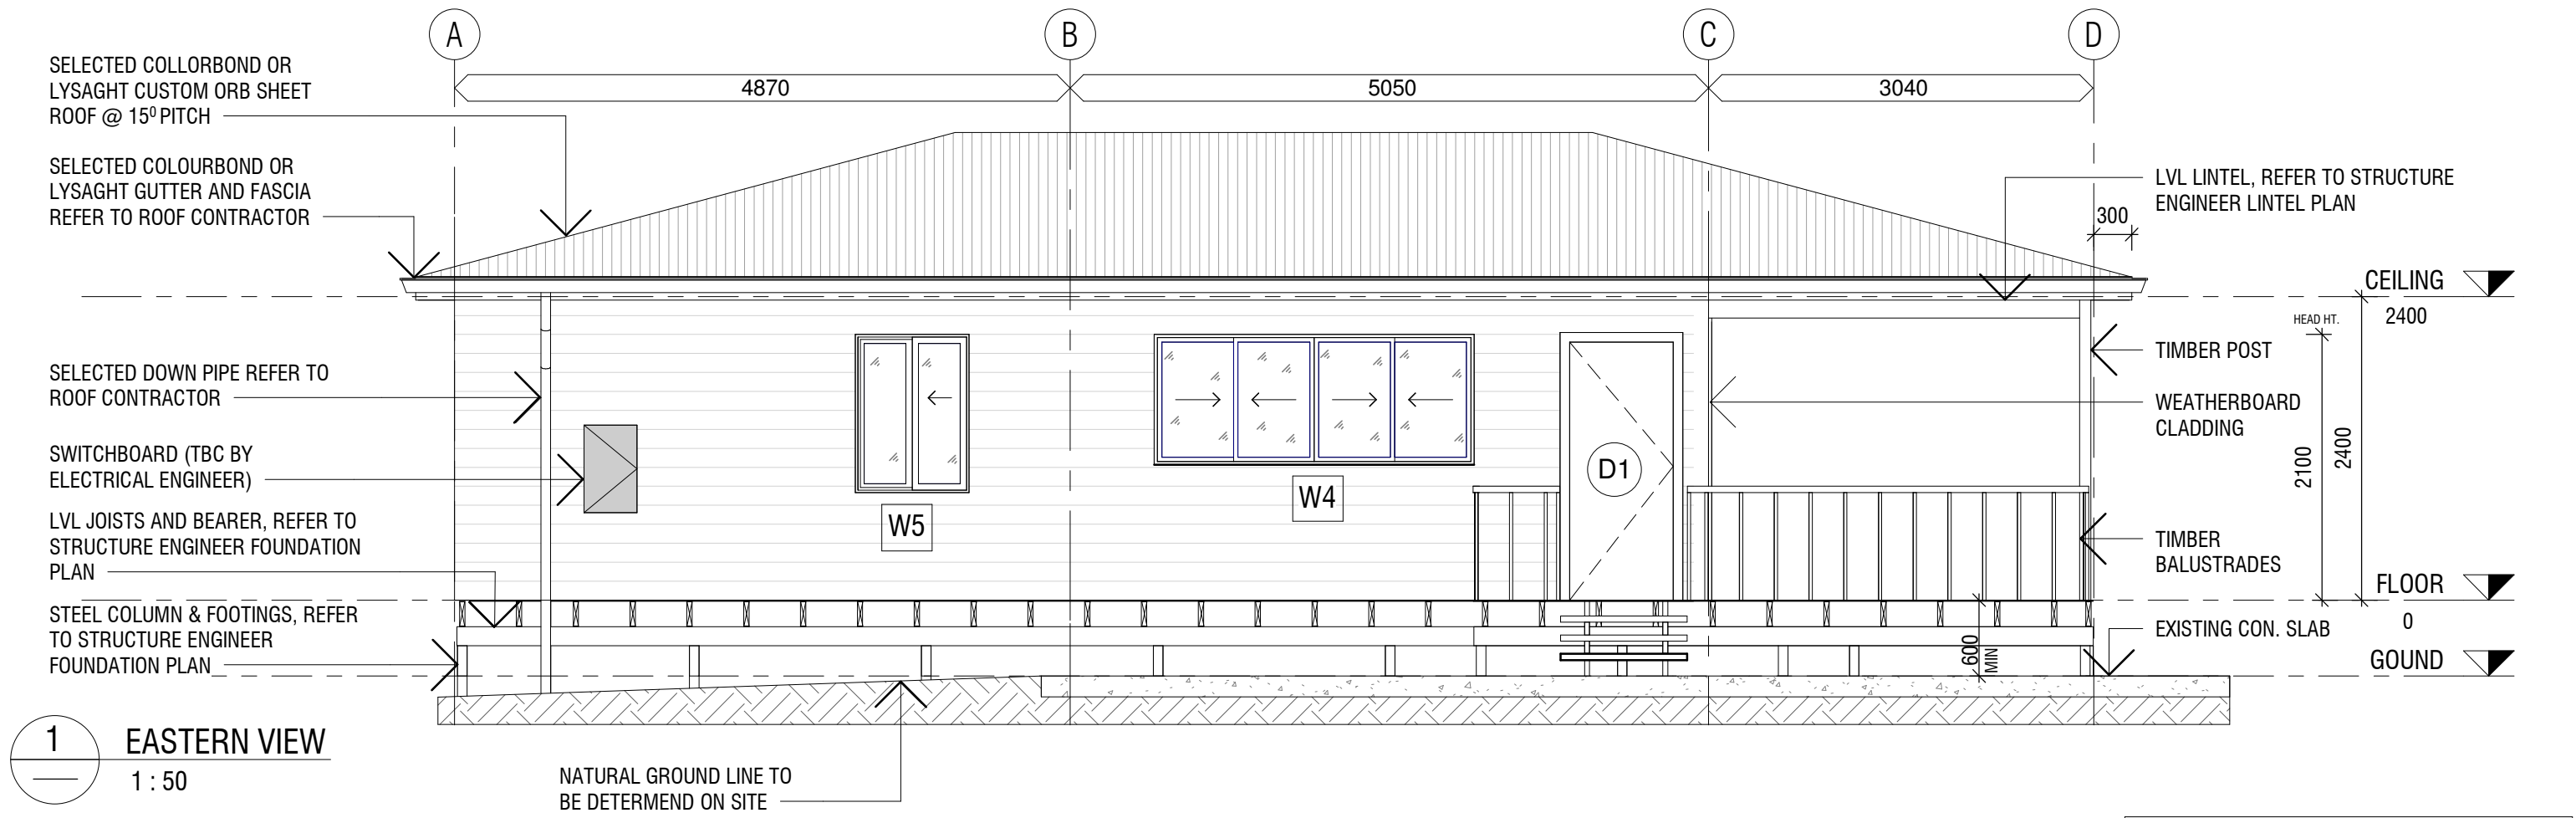

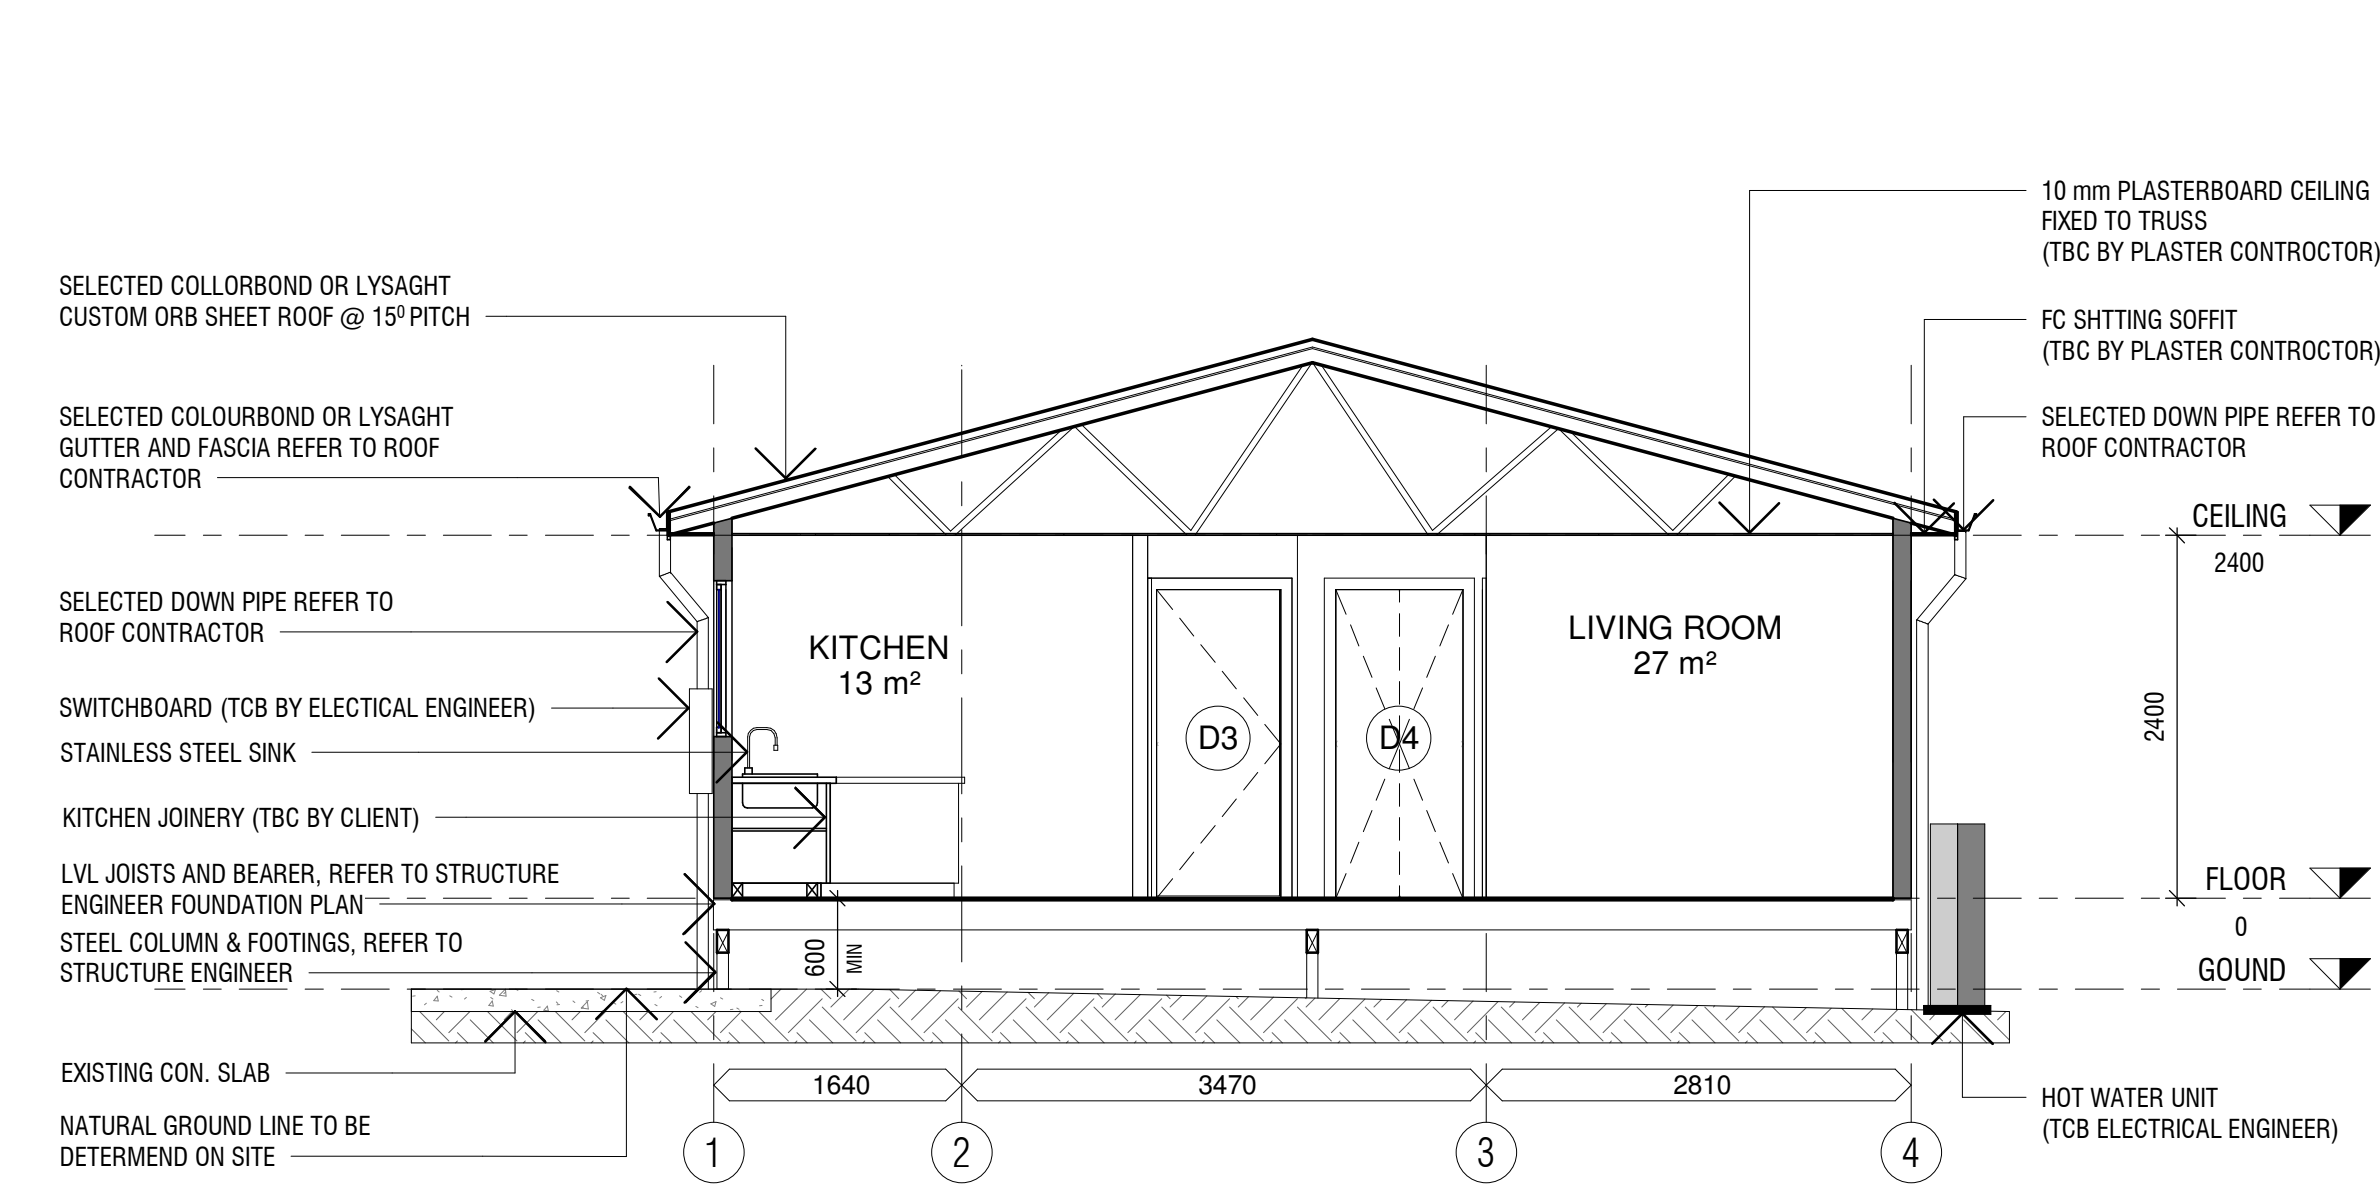

LEDGEND

- D3 2040 mm x 820 mm x 35 mm DOOR
- D4 2040 mm x 840 mm DOUBLE DOOR

NOTE:

- THIS DRAWING IS TO BE READ IN CONJUNCTION WITH ALL OTHER DRAWINGS RELEVANT TO THIS PROJECT.
- CONFIRM LOCATION OF ANY EXISTING SERVICES PRIOR TO COMMENCEMENT OF ANY WORK.
- ALL DISCONNECTION, RELOCATION, RECONNECTING, CUTTING & SEALING WORKS TO THE BUILDING SERVICES ARE TO BE CARRY OUT IN ACCORDANCE WITH THE REQUIREMENTS OF THE RELEVANT AUTHORITY.
- AMENDED DRAWINGS SHALL SUPERCEDE ALL PREVIOUS REVISIONS.
- ALL ITEMS USED IN THE WORK ARE TO BE USED FIXED , INSTALLED, APPLIED ETC. WITH THE MANUFACTURES SPECIFICATION.

NOTE: ALL FINISHES & MATERIAL SELECTIONS TO BE CONFIRMED BY BUILDER

Roof sheeting to be white, cream or light grey in colour. Roof to be fitted with insulation to meet R3.5. (If darker roof sheeting is used, then a higher R-value insulation will be required).

Wall system is required to meet an R-value of 2.8. This will require insulation with an R-value of 2.32 or greater. Sarking with an R-value of 0.2 or greater is required to be installed between the weatherboards and the framing.

1 SECTION
CD-100 1 : 50

APPROVED FOR CONSTRUCTION
REFER TO BUILDING PERMIT FOR CONDITIONS
Permit Number: 2019099
29th August 2019

Andrew Bleakley QBCC Lic A1126608

BRC Consultants

bArki Studio Pty Ltd
ABN 15 370 825 058
p 0413761762
e jeremy.barki@gmail.com
m PO Box 917 New Farm Q 4000