


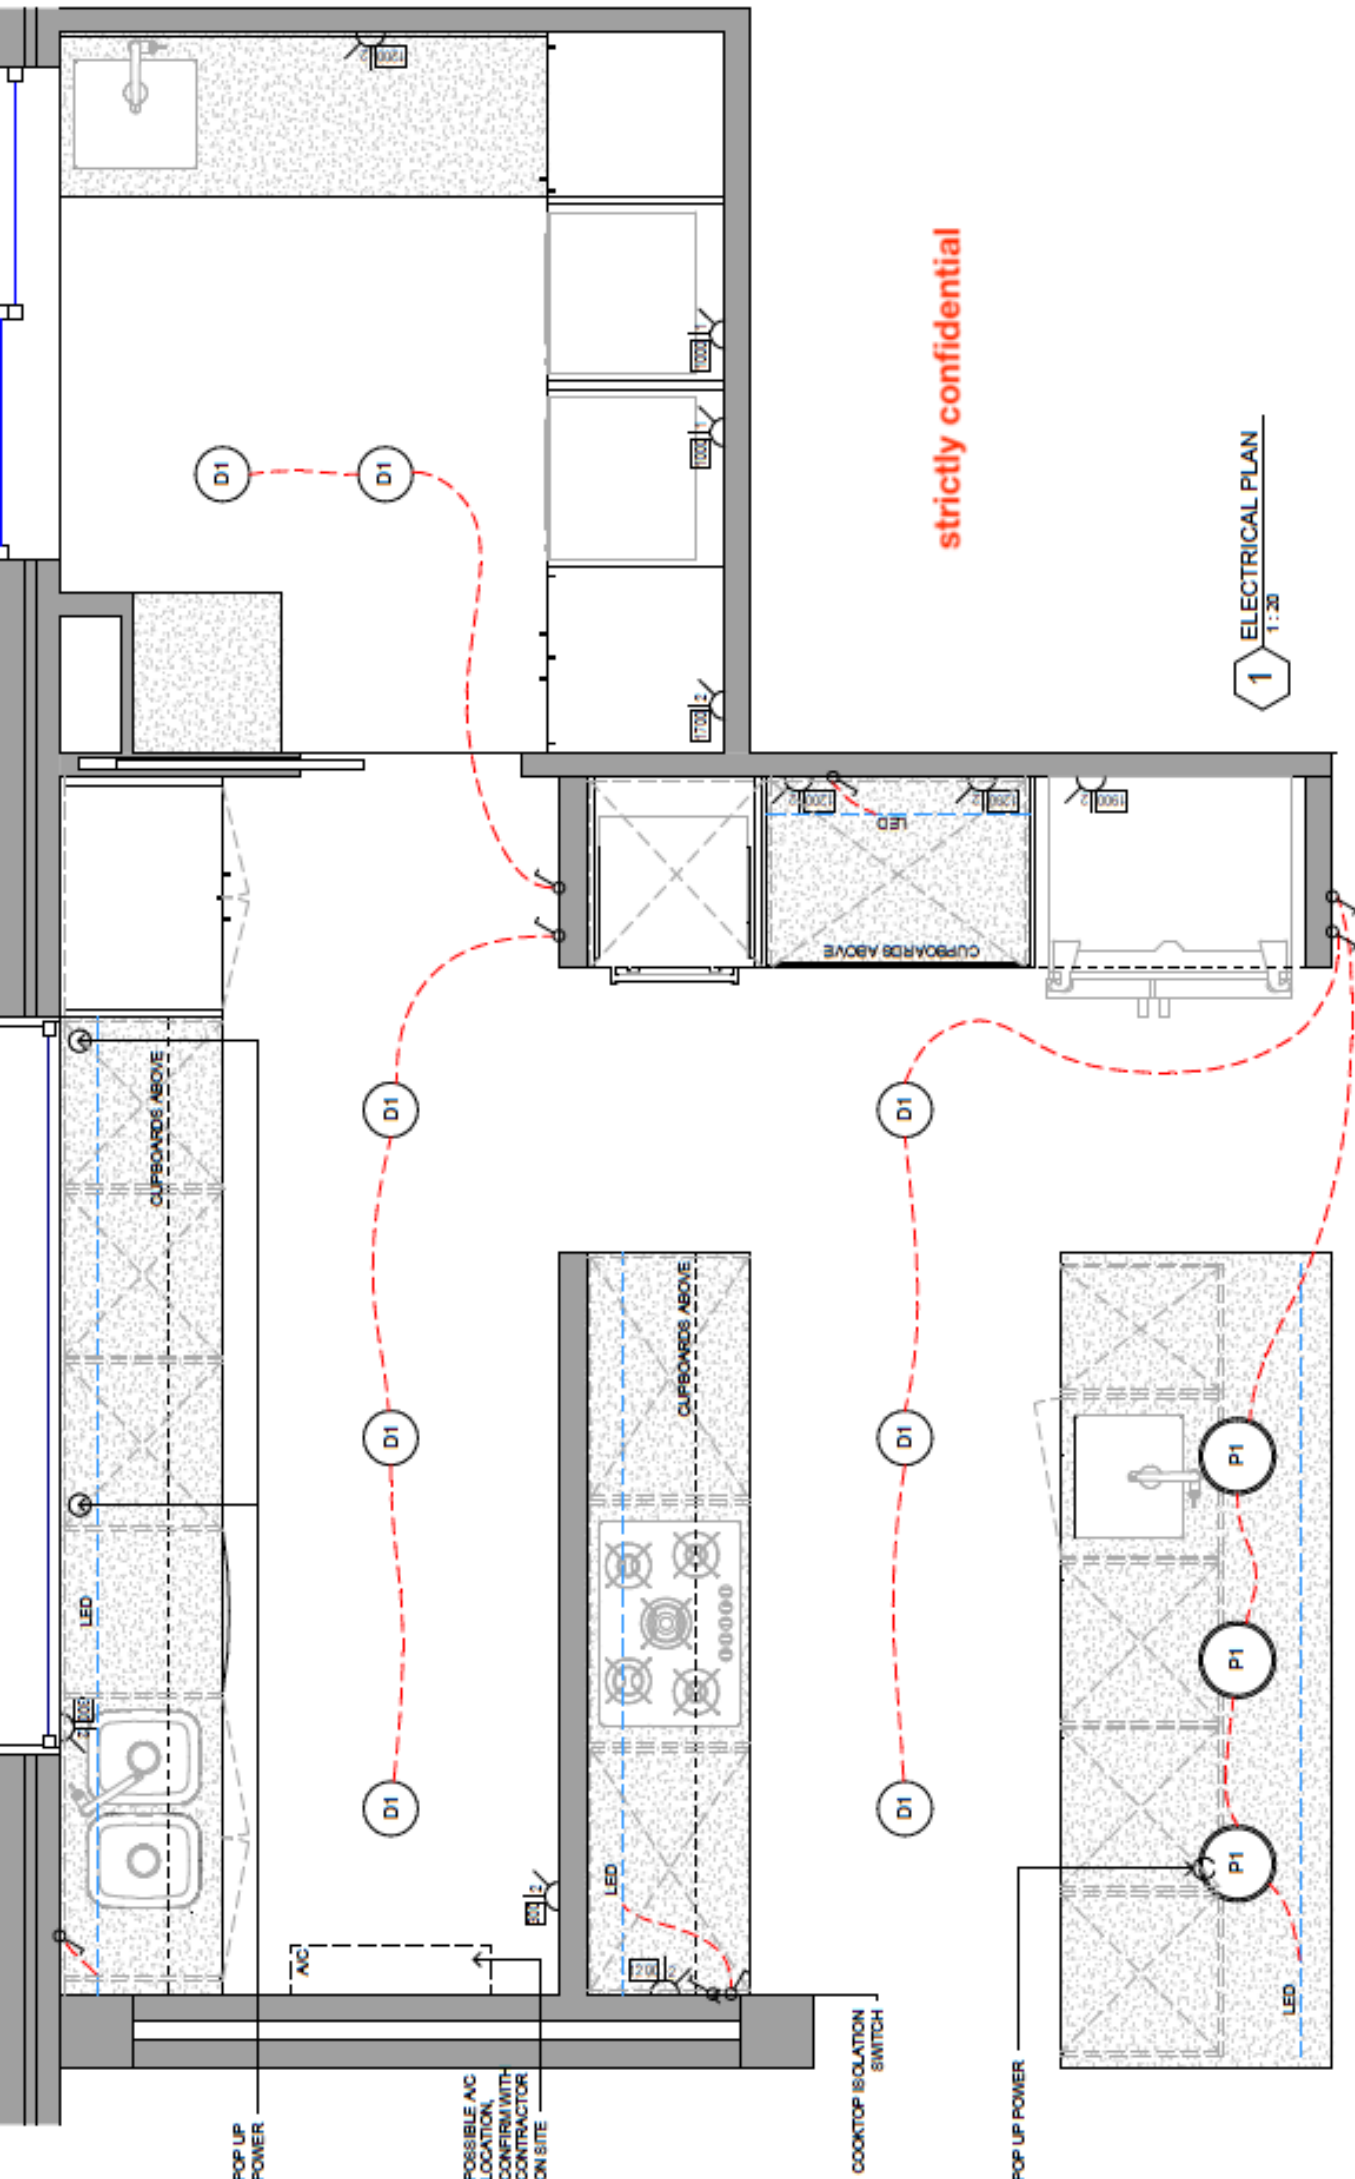

strictly confidential

1 ELECTRICAL PLAN
1:20

Project: 123, ABC Residential St, QLD
Date: 1/03/2022
Information 12/06/2022
update 18/11/2022
final 30/11/2022

scale 1:20