


EXISTING MEMBER SCHEDULE		
MEMBER	TAG	DESCRIPTION
COLUMN	C1	85 x 85 HARDWOOD
	C2	65 SHS, TO BE REMOVED
ROOF BEAM	RB1	190 x 80 HARDWOOD
	RB2	125 PFC TO BE REMOVED
PURLIN	P1	150x75 HARDWOOD
	P2	Z/C 150 PURLINS TO BE REMOVED
BRACE	BR1	12mm THREADED ROD TO BE REMOVED

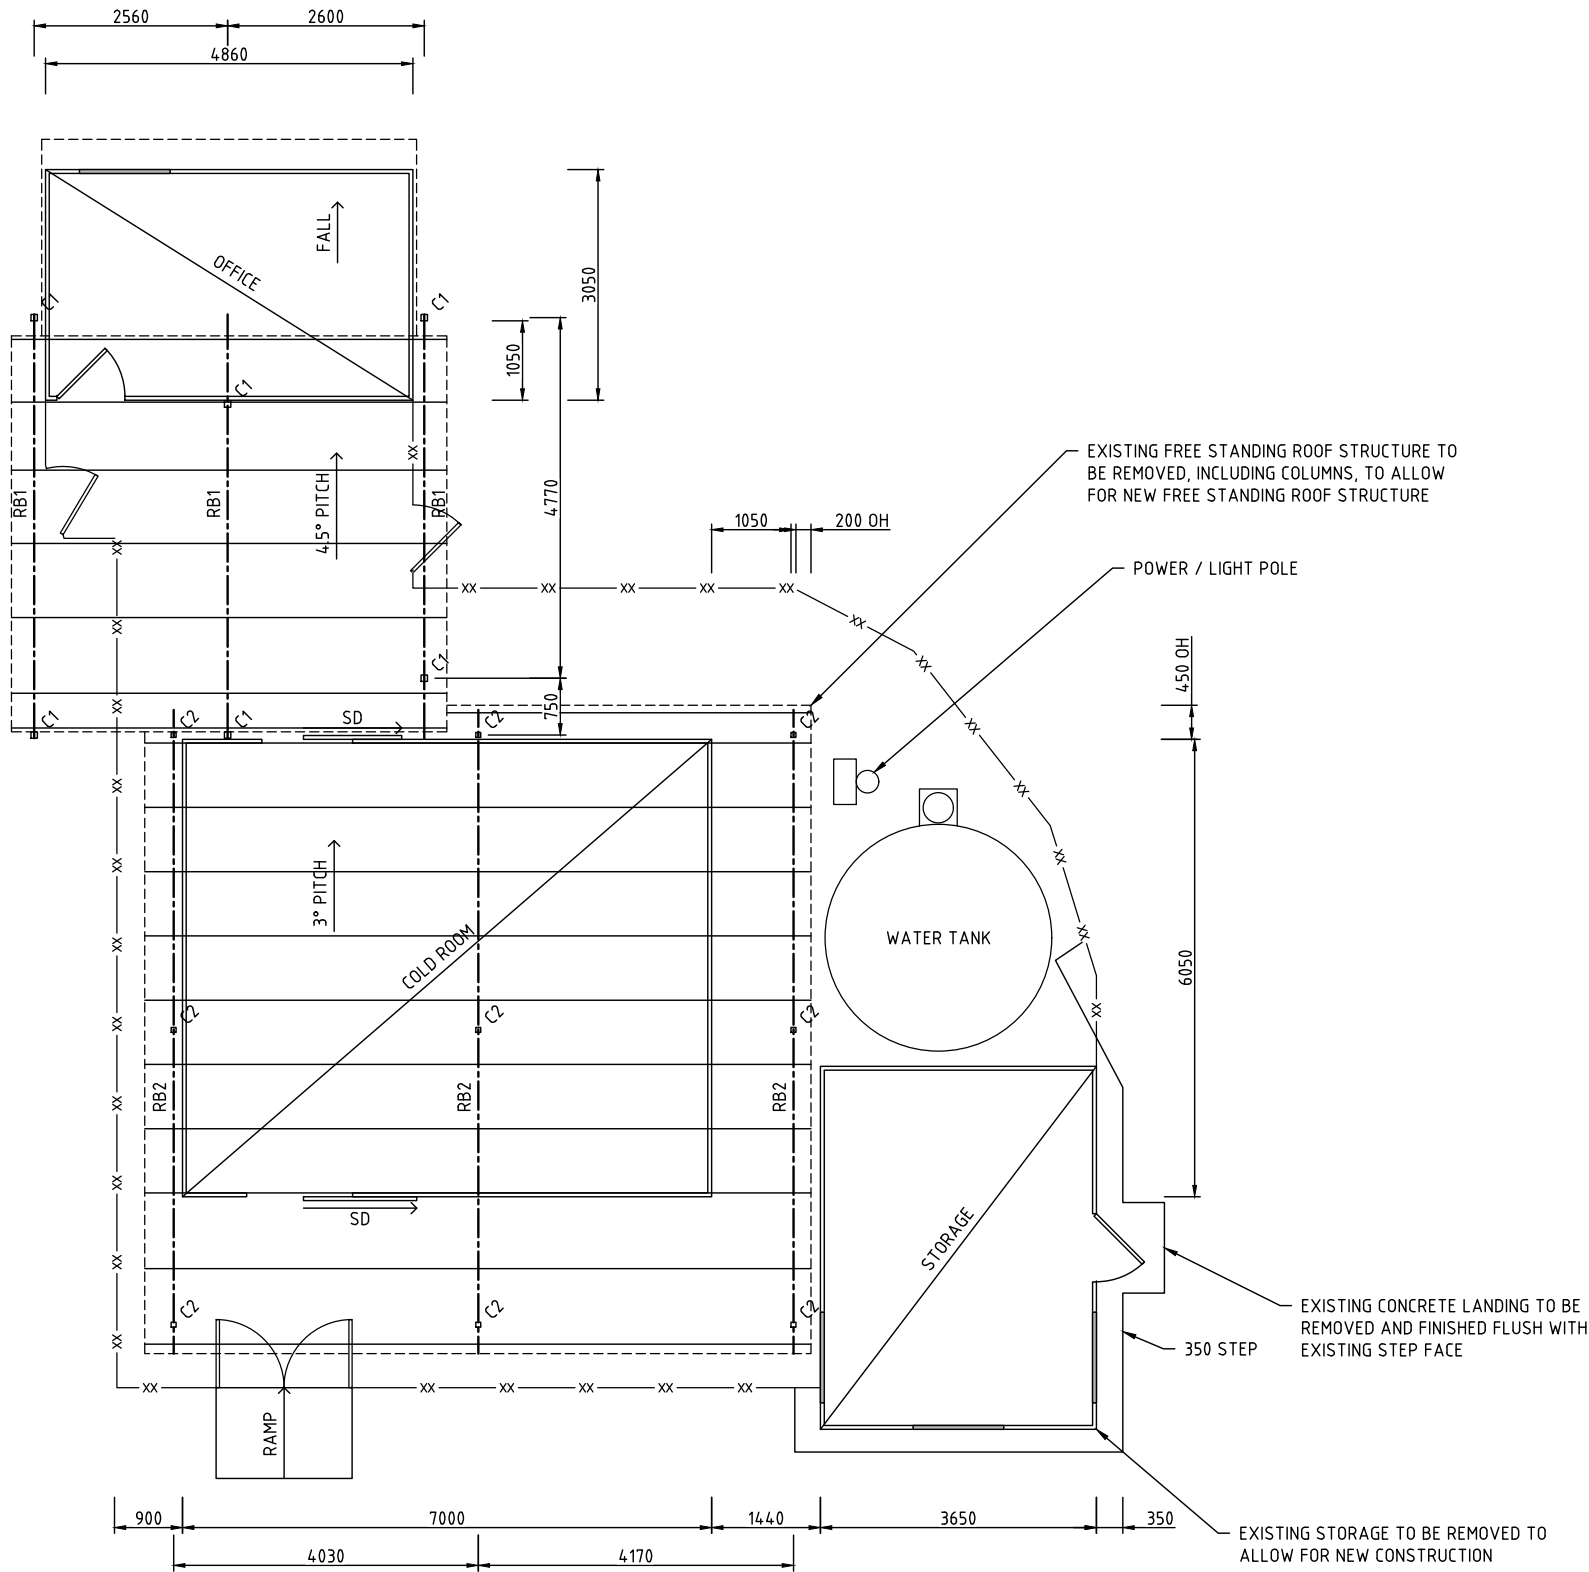

EXISTING LAYOUT & FRAMING PLAN
SCALE: 1:50



DRAWING FILE LOCATION / NAME
S:\2019\19345 Economic Development Social Ventures Support Package\CAD - DARNLEY\30033657 - PRELIMINARY.dwg

PLOT DATE
30 Jan 2020

TIME
10:26:25

EXTERNAL REFERENCE FILES
X_30033657_SHEC_A1.dwg

REV	DATE	AMENDMENT / REVISION DESCRIPTION
A	20.12.19	ISSUED FOR CLIENT REVIEW
B	29.01.20	ISSUED FOR CLIENT REVIEW

WVR No.

APPROVAL	TITLE	NAME
CT	DRAFTER	NATHAN PHILLIPS
CT	DRAFTING CHECK	DANIEL MANSFIELD
	DESIGNER	CHRIS TAIFALOS
	DESIGN CHECK	PETER WATTON
	PROJECT MANAGER	CHRIS TAIFALOS
	PROJECT DIRECTOR	PETER DE ROMA

SCALES AT A1 SIZE DRAWING
SCALE 1:50

DESIGNER

Australian Government

TSRA

www.tsra.gov.au

pdr

SMEC


ABN 47 065 475 149
LEVEL 2 20-32 LAKE STREET
CAIRNS QLD 4870
PH 07 4225 9800 FAX 07 3029 6650
PDR SMEC PROJECT No 30033657

FOR TENDER


ERUB FISHERIES
MANAGEMENT
TORRES STRAIT ISLANDER
CORPORATION

PROJECT TITLE		FREEZER ROOM UPGRADE DARNLEY ISLAND EXISTING LAYOUT PLAN	
SCALE	PHASE	PROJECT / DRAWING No.	REVISION
AS SHOWN	FOR TENDER	30033657 - SK01	B


150 mm ON ORIGINAL
A1
0 10 20 30 40 50 60 70 80 90 100 110 120 130 140 150

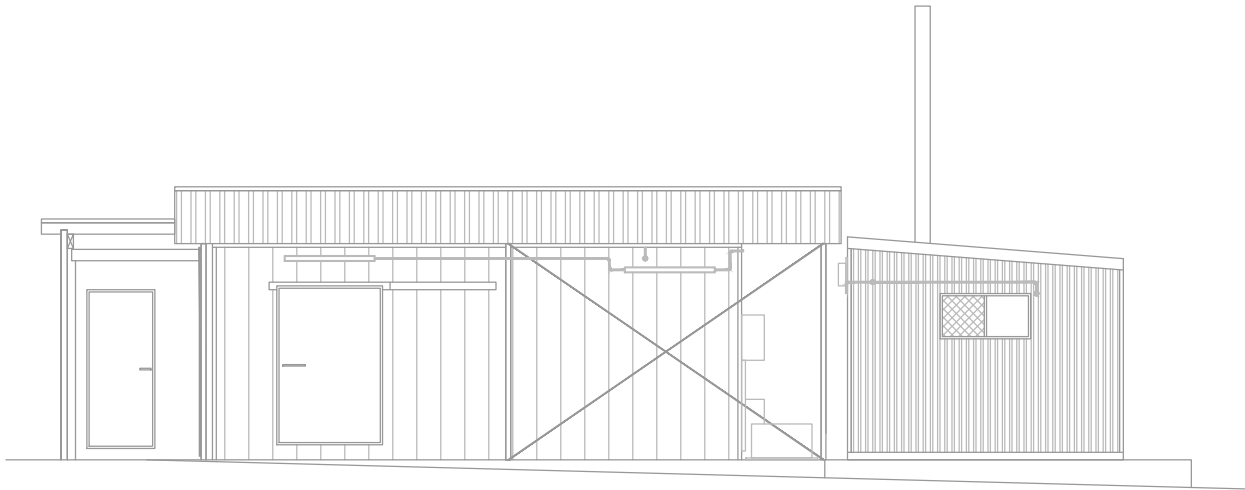


ELEVATION A
SCALE: 1:50

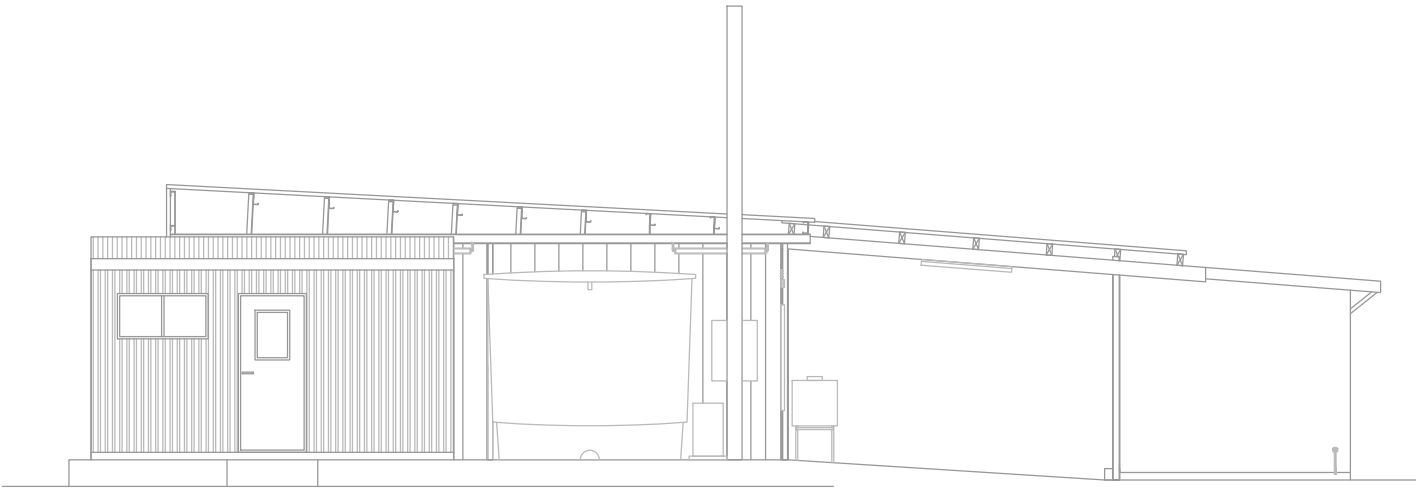

ELEVATION B
SCALE: 1:50

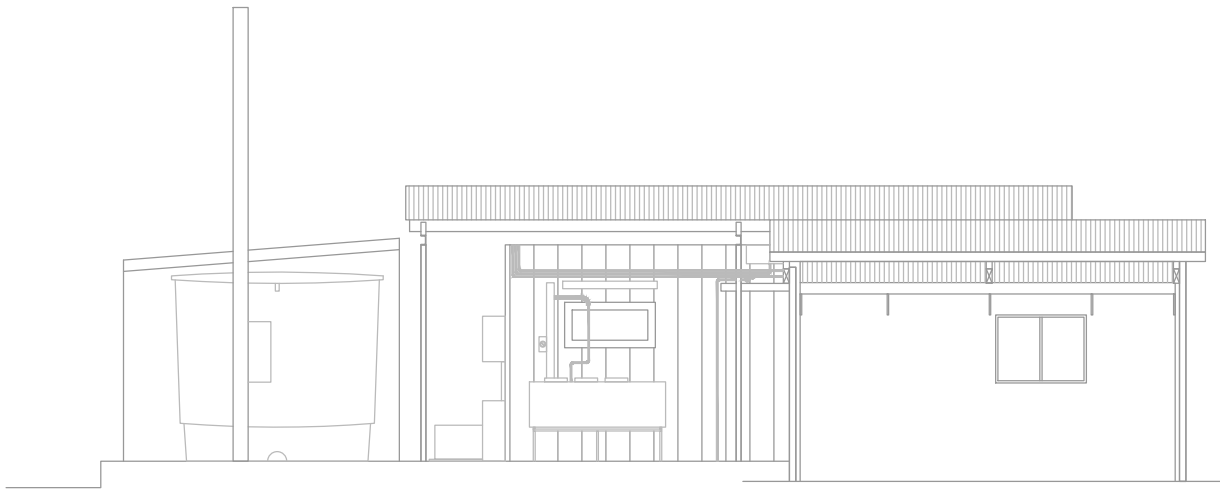

ELEVATION C
SCALE: 1:50

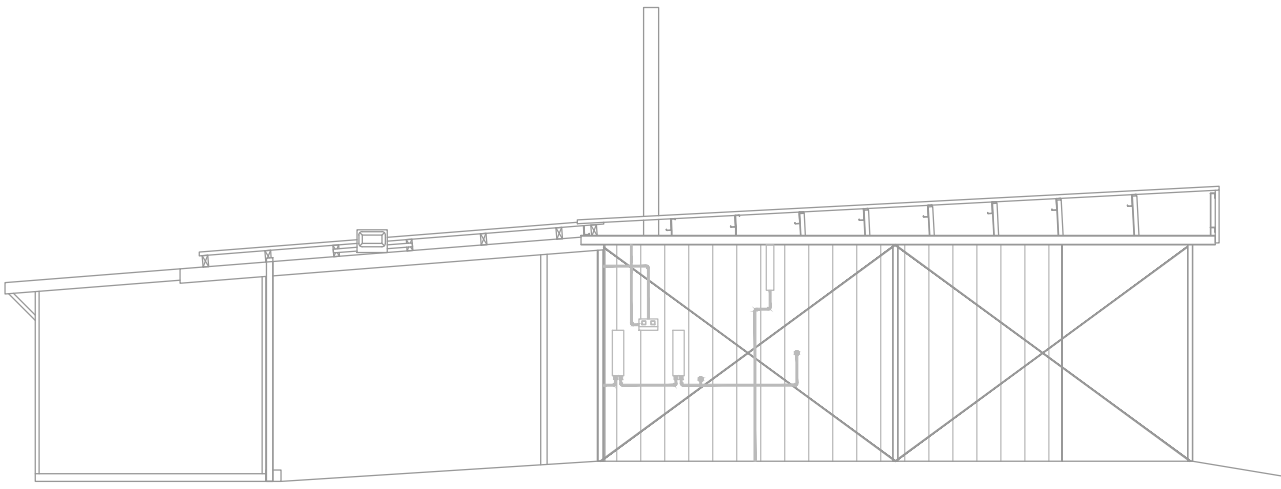


ELEVATION D
SCALE: 1:50

FOR TENDER


DRAWING FILE LOCATION / NAME S:\2019\19345 Economic Development Social Ventures Support Package\CAD – DARNLEY\30033657 – PRELIMINARY.dwg					PLOT DATE 30 Jan 2020		TIME 10:26:25									
EXTERNAL REFERENCE FILES		REV	DATE	AMENDMENT / REVISION DESCRIPTION	WVR No.	APPROVAL	TITLE	NAME	SCALES AT A1 SIZE DRAWING  SCALE 1:50	DESIGNER  www.tsra.gov.au  ABN 47 065 475 149 LEVEL 2 20-32 LAKE STREET CAIRNS QLD 4870 PH 07 4225 9800 FAX 07 3029 6650 PDR SMC PROJECT No 30033657	CLIENT ERUB FISHERIES MANAGEMENT TORRES STRAIT ISLANDER CORPORATION	PROJECT TITLE FREEZER ROOM UPGRADE DARNLEY ISLAND EXISTING ELEVATIONS	SCALE AS SHOWN	PHASE FOR TENDER	PROJECT / DRAWING No. 30033657 – SK02	REVISION B
X_30033657_SHEC_A1.dwg	A	20.12.19	ISSUED FOR CLIENT REVIEW		CT	DRAFTER	NATHAN PHILLIPS									
	B	29.01.20	ISSUED FOR CLIENT REVIEW			DRAFTING CHECK	DANIEL MANSFIELD									
						DESIGNER	CHRIS TAIFALOS									
						DESIGN CHECK	PETER WATTON									
						PROJECT MANAGER	CHRIS TAIFALOS									
			PROJECT DIRECTOR	PETER DE ROMA												

- NOTES:**
- ROOF SHEETING TO BE COLORBOND ULTRA
 - ALL FIXINGS AND EXPOSED STEEL WITH THE EXCEPTION OF COLUMNS THAT ARE TO BE GRADE 316 STAINLESS STEEL
 - ALL OTHER STEEL TO BE HOT DIP GALVANISED.

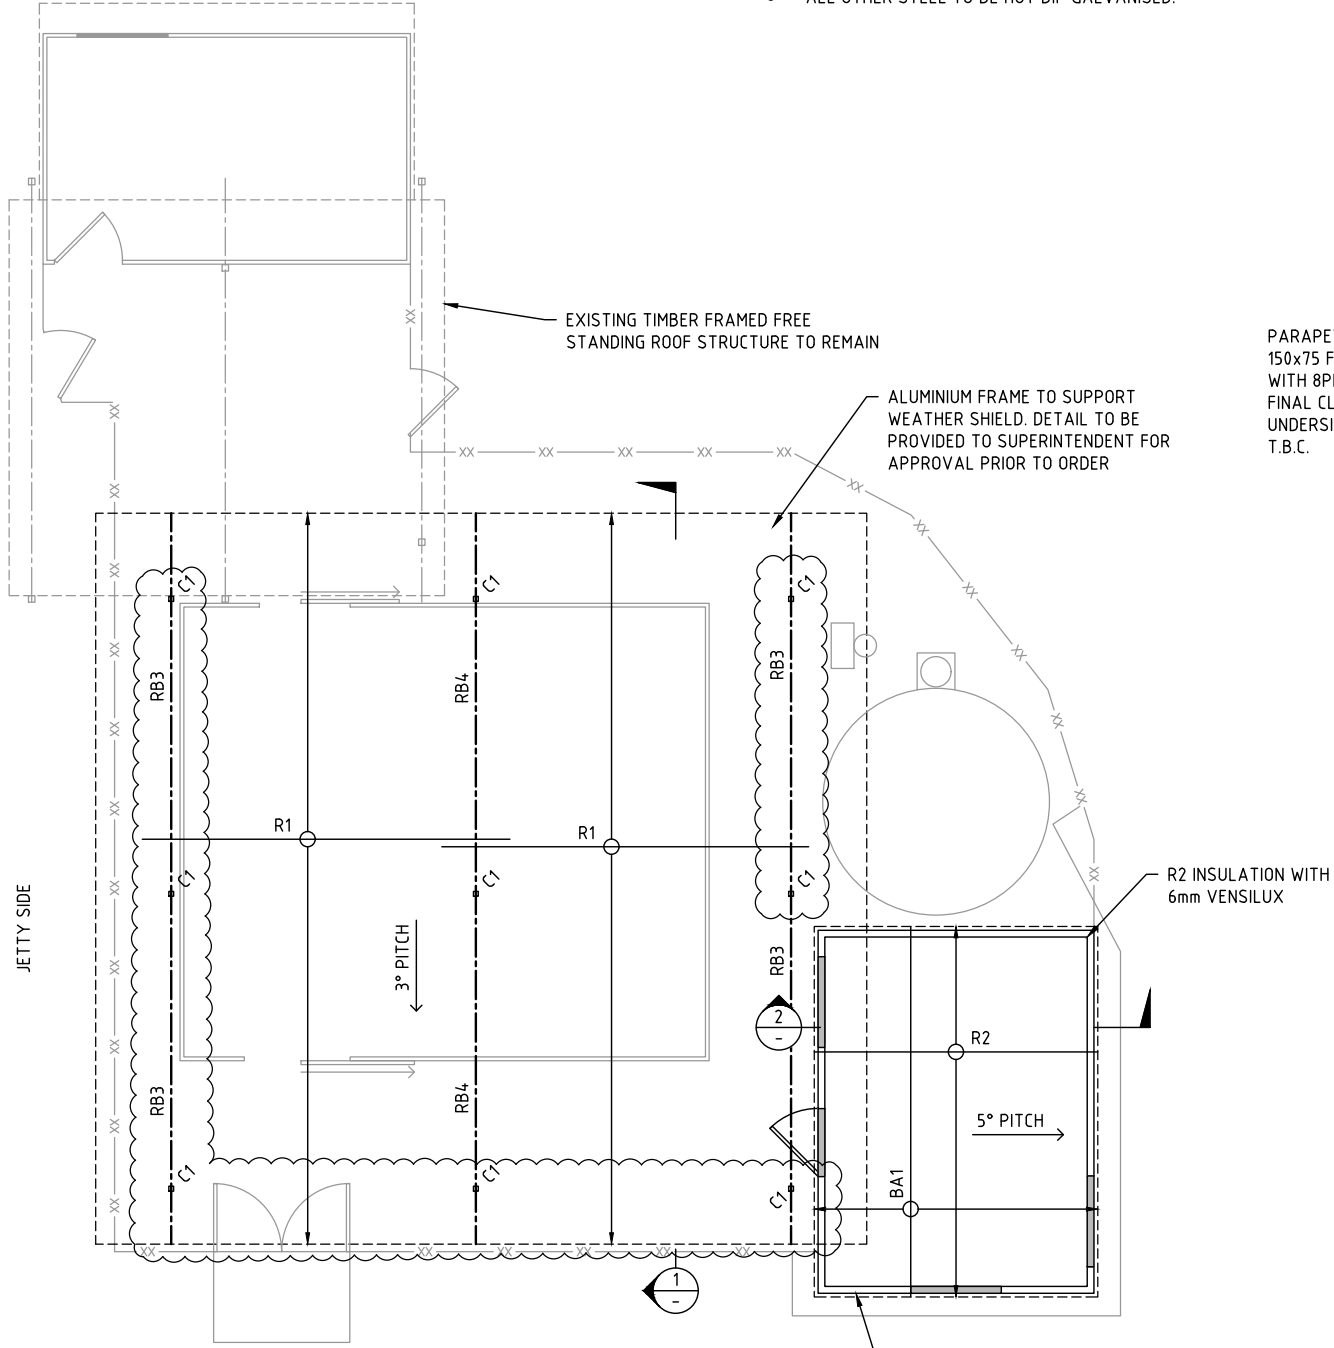


PROPOSED LAYOUT & FRAMING PLAN
SCALE: 1:50

NEW TIMBER FRAMED STORAGE STRUCTURE TO EXISTING SLAB ON GROUND, MIN. 2.7m HIGH WALL, TRIMDEK ULTRA WALL CLADDING
TOP PLATE: 2-35x90 MGP12 WITH M12 HD RODS @ 900 CRS & CORNERS
BTM PLATE: 35x90 MGP12
STUDS: 35x90 MGP12 @ 450 CRS
NOGGING: 35x90 MGP12 - 1 ROW
JAMB STUDS: 2-35x90 MGP12 ADJACENT OPENINGS
LINTELS: 130x44 HYNE LGL OR;130x35 SMART LVL14
2 No. S/S TRIP-L-GRIP, 4 NAILS PER FACE OR; 1 No. S/S OVER STRAP WITH 8 NAILS TOTAL

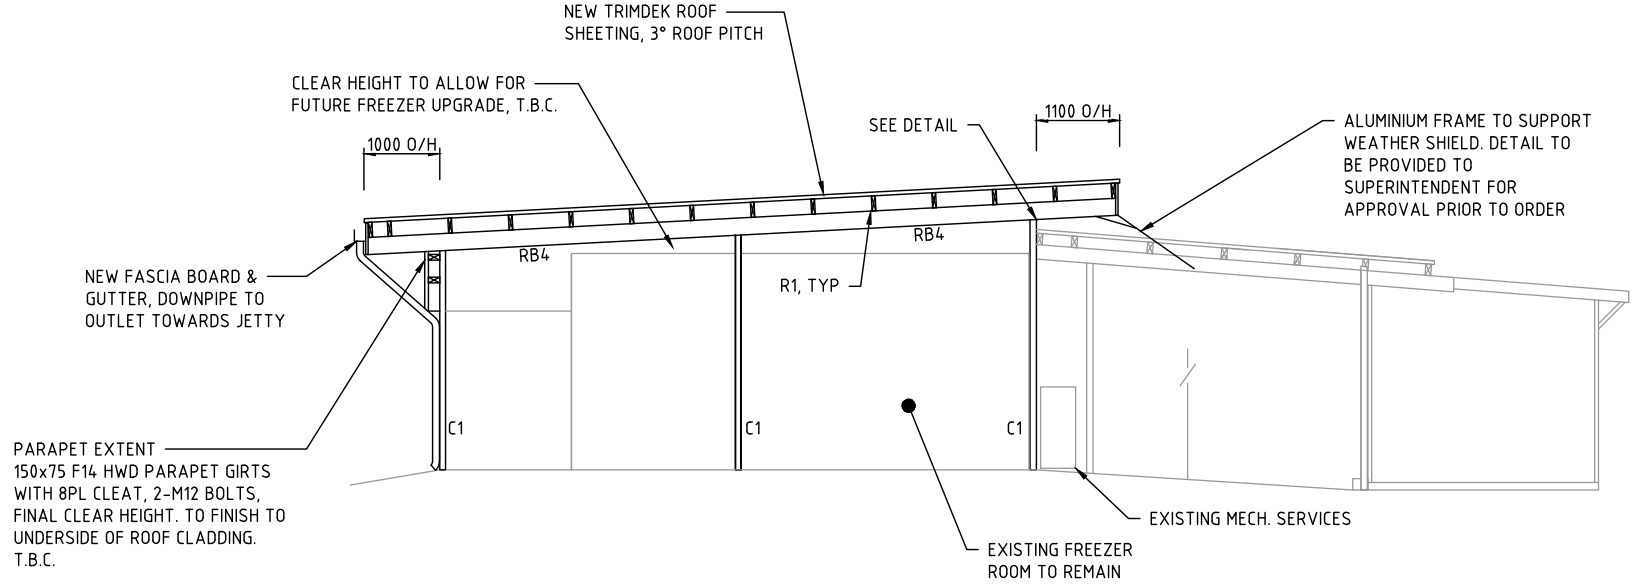


SECTION 1
SCALE 1:50

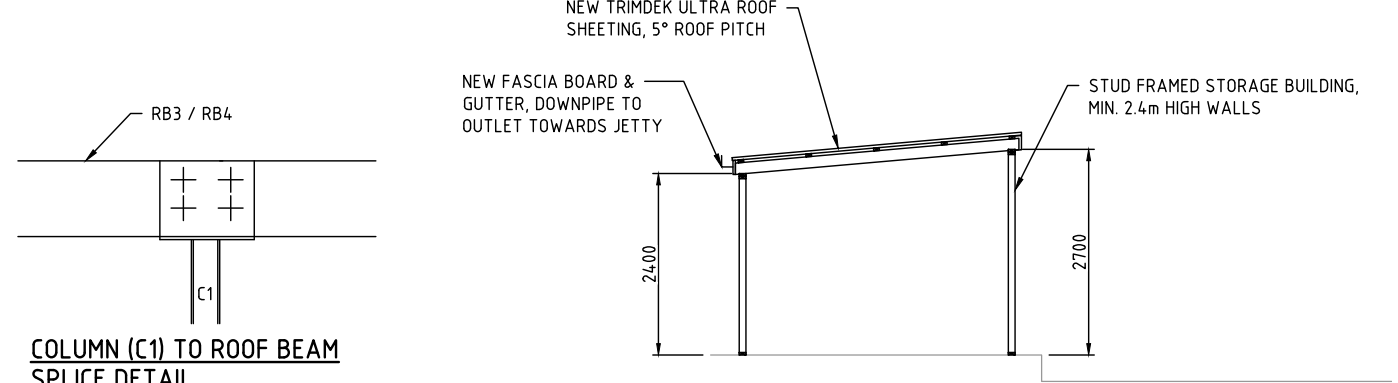


SECTION 2
SCALE 1:50

COLUMN (C1) TO ROOF BEAM SPLICE DETAIL
SCALE: 1:10

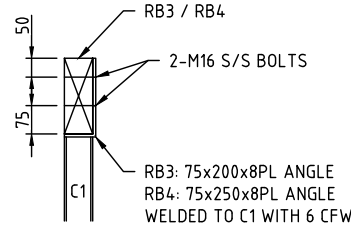

COLUMN (C1) TO ROOF BEAM (RB3/RB4) CONNECTION DETAIL
SCALE: 1:10

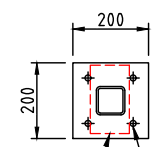

COLUMN (C1) BASE PLATE DETAIL
SCALE: 1:10

PROPOSED MEMBER SCHEDULE		
MEMBER	TAG	DESCRIPTION
COLUMN	C1	75x50 GALV. SHS
		10PL TOP PLATE WITH 2-M16 BOLTS THRU RB1, PROVIDE 10PL SANDWICH PLATE
ROOF BEAM	RB3	200x75 F17 HWD
		250x75 F17 HWD
RAFTER	R1	175x50 F14 HWD @ 800 MAX CRS FIXED AS BELOW: TO RB3 150x75x6 S/S EA WITH 1-M12 S/S THRU RAFTER & 1-M12 THRU RB1 OR: 1 No. S/S OVERSTRAP WITH 4 S/S NAILS TOTAL
		TO RB4: 150x75x6 EA WITH 1-M12 THRU RAFTER & 1-M12 THRU RB2 OR: 2 No. S/S OVERSTRAP WITH 8 S/S NAILS TOTAL
	R2	150x50 F14 HWD @ 800 MAX CRS FIXED TO TOP PLATE WITH 2 No. S/S TRIP-L-GRIPS WITH 4 NAILS PER FACE OR; 1 No. S/S OVERSTRAP WITH 4 NAILS TOTAL
BATTEN	BA1	75x50MGP12 BATTENS AT 850 MAX CRS, FIX IN ACCORDANCE WITH MANUFACTURERS SPECIFICATIONS
ROOF SHEETING	TYP	TRIMDEK ULTRA 0.48 BMT ROOF SHEETING, FIX IN ACCORDANCE WITH MANUFACTURERS SPECIFICATION
NOTE: S/S DENOTES STAINLESS STEEL		

FOR TENDER

DRAWING FILE LOCATION / NAME
S:\2019\19345 Economic Development Social Ventures Support Package\CAD - DARNLEY\30033657 - PRELIMINARY.dwg

EXTERNAL REFERENCE FILES

REV
A
B

DATE
20.12.19
29.01.20

AMENDMENT / REVISION DESCRIPTION
ISSUED FOR CLIENT REVIEW
ISSUED FOR CLIENT REVIEW

WVR No.

APPROVAL
CT
CT

TITLE
DRAFTER
DRAFTING CHECK
DESIGNER
DESIGN CHECK
PROJECT MANAGER
PROJECT DIRECTOR

NAME
NATHAN PHILLIPS
DANIEL MANSFIELD
CHRIS TAIFALOS
PETER WATTON
CHRIS TAIFALOS
PETER DE ROMA

SCALES AT A1 SIZE DRAWING

SCALE 1:10
SCALE 1:50

DESIGNER
Australian Government
pdr
TSRA
www.tsra.gov.au
SMEC

CLIENT
ERUB FISHERIES
MANAGEMENT
TORRES STRAIT ISLANDER
CORPORATION

PROJECT TITLE
FREEZER ROOM UPGRADE
DARNLEY ISLAND
PROPOSED REMEDIATION PLAN
AND SECTION

 
SCALE
AS SHOWN


PHASE
FOR TENDER

PROJECT / DRAWING No.
30033657 - SK03

REVISION
B

- NOTES:
- EXISTING SWITCHBOARD TO BE CHECKED BY A LICENSED PROFESSIONAL TO DETERMINE UPGRADE REQUIREMENTS. SUB-MAIN & SUPPLY TO BE CHECKED FOR LOAD CAPACITY.
 - NEW SPLIT SYSTEM AIR CONDITIONER UNITS SIZE & FRESH AIR INDUCTION TO BE CONFIRMED BY OTHERS.
 - A SMOKE DETECTION SYSTEM COMPLYING WITH BCA SPECIFICATION E2.2A CLAUSE 3.2 REFERRAL TO QFES.
 - SMOKE DETECTORS TO BE WIRED INTO EXISTING COMPLIANT SYSTEM.
 - ALL LIGHT SWITCHES TO BE 900-1100mm ABOVE FINISHED FLOOR LEVEL.
 - ALL LIGHTS TO BE SURFACE MOUNTED.
 - ALL LIGHT FITTING TO BE COMPATIBLE WITH COMPACT FLORESCENT BULBS AND HAVE REPLACEABLE B22 BAYONET OR E27 EDISON LED 'CORN' BULB INSTALLED.

- LEGEND:
- SO
- WEATHERPROOF DOUBLE SOCKET OUTLET
- 
- WEATHERPROOF LED FLURO LIGHT
WITH VANDAL PROOF COVERED
- 
- WEATHERPROOF LIGHT SWITCH
- 
- SPLITSYSTEM AIR CONDITIONER &
POWER POINT ON DEDICATED CIRCUIT

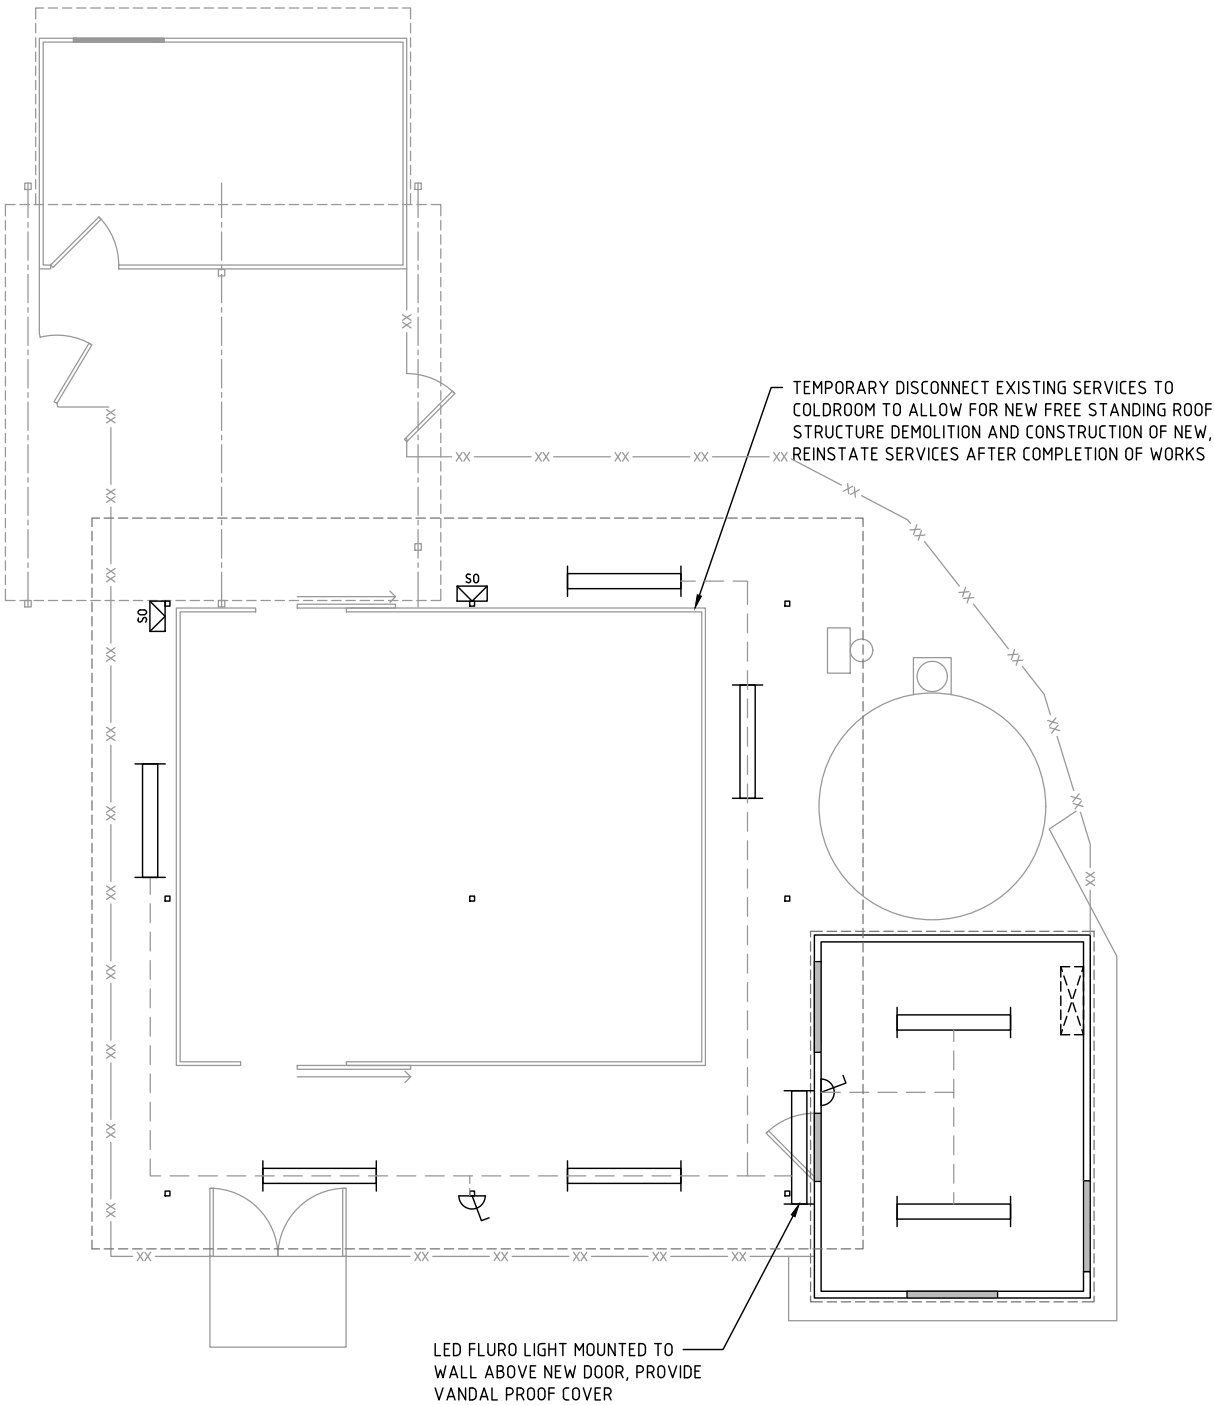

PROPOSED ELECTRICAL PLAN
SCALE: 1:50

FOR TENDER

DRAWING FILE LOCATION / NAME S:\2019\19345 Economic Development Social Ventures Support Package\CAD - DARNLEY\30033657 - PRELIMINARY.dwg					PLOT DATE 30 Jan 2020		TIME 10:26:26																	
EXTERNAL REFERENCE FILES X_30033657_SHEC_A1.dwg		REV A	DATE 29.01.20	AMENDMENT / REVISION DESCRIPTION ISSUED FOR CLIENT REVIEW	WVR No.	APPROVAL CT	TITLE	NAME	SCALES AT A1 SIZE DRAWING		DESIGNER     ABN 47 065 475 149 LEVEL 2 20-32 LAKE STREET CAIRNS QLD 4870 PH 07 4225 9800 FAX 07 3029 6650 PDR SMC PROJECT No 30033657		CLIENT ERUB FISHERIES MANAGEMENT TORRES STRAIT ISLANDER CORPORATION		PROJECT TITLE FREEZER ROOM UPGRADE DARNLEY ISLAND PROPOSED REMEDIATION PLAN ELECTRICAL SERVICES		SCALE AS SHOWN		PHASE FOR TENDER		PROJECT / DRAWING No. 30033657 - SK04		REVISION A	
							DRAFTER	NATHAN PHILLIPS	SCALE 1:50 															
							DRAFTING CHECK	DANIEL MANSFIELD																
							DESIGNER	CHRIS TAIFALOS																
							DESIGN CHECK	PETER WATTON																
							PROJECT MANAGER	CHRIS TAIFALOS																
							PROJECT DIRECTOR	PETER DE ROMA																